
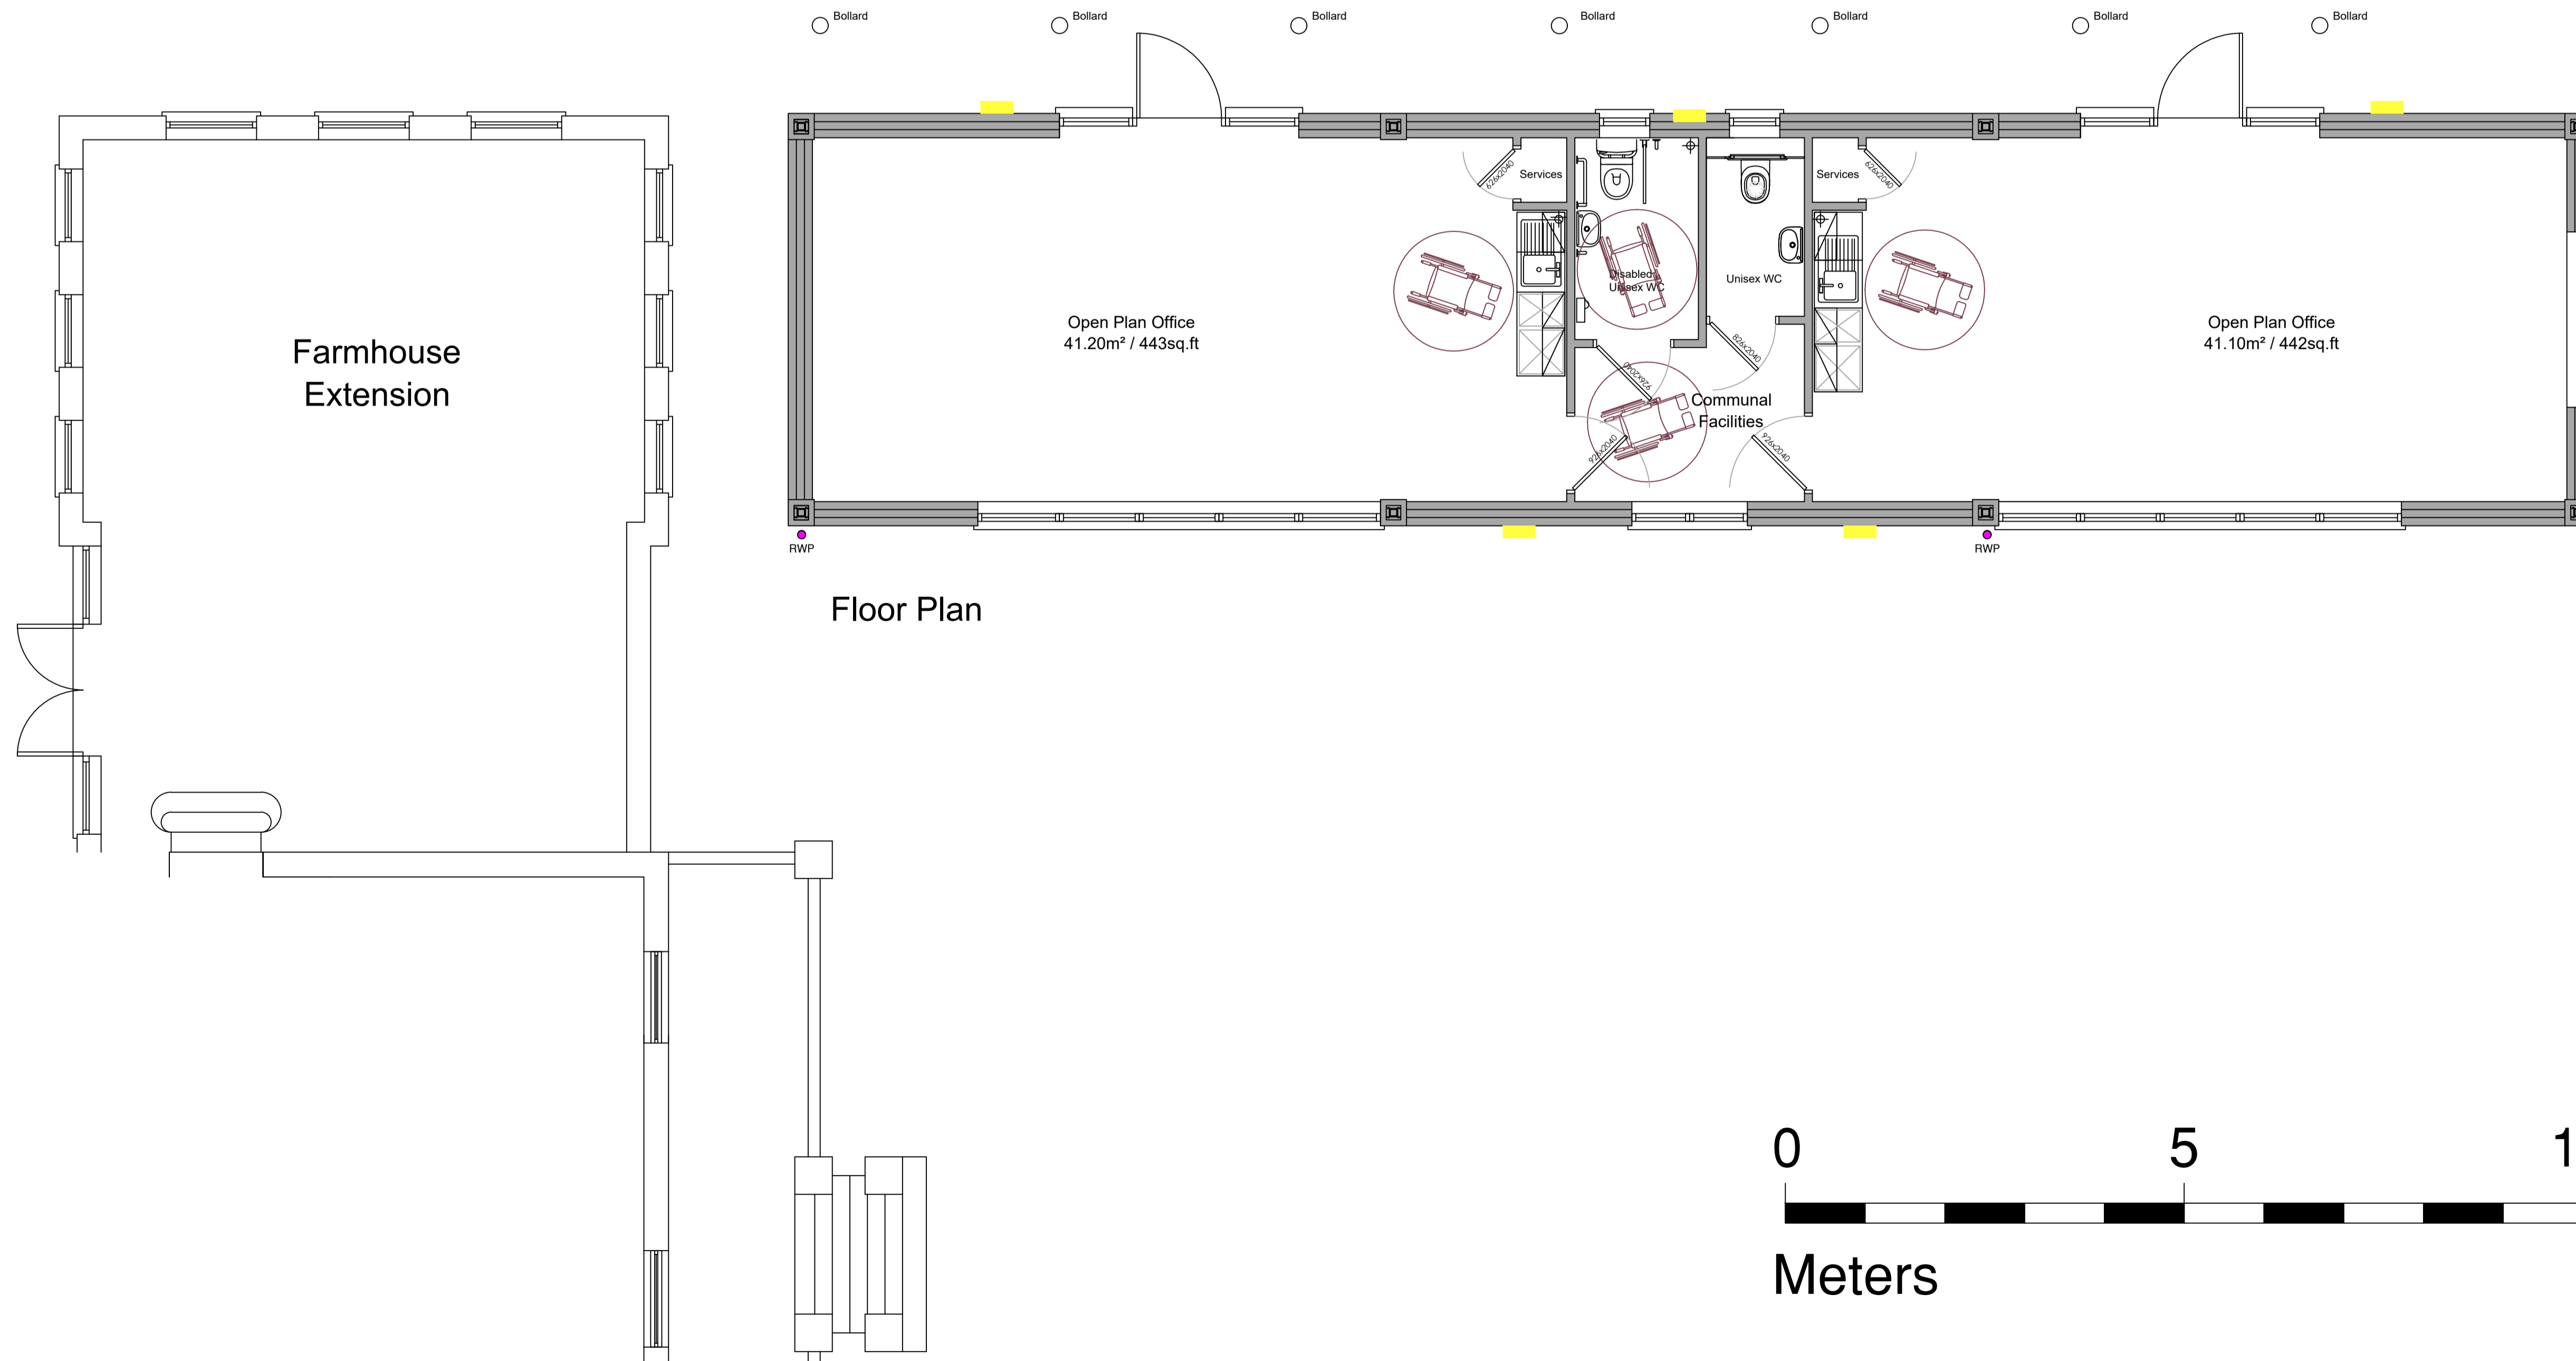


Wall mounted external light: ANSELL ADLED2/BV/CCT with eyelid bezel to prevent uplight BZ/EYE/B. All external lighting controlled on photocell and presence detectors.

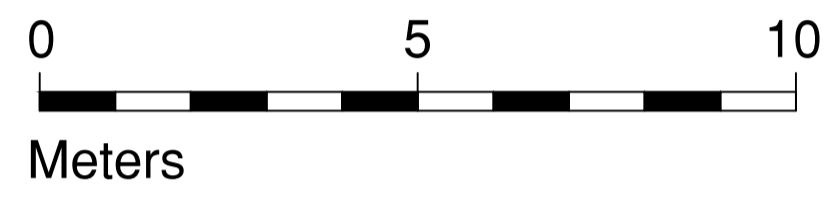

ROSPER ESTATES	
CLIENT Rosper Estates	
PROJECT Unit 2 Carport Conversion Stansted Courtyard Parsonage Road Takeley CM22 6PU	
DRAWING TITLE Carport Conversion - Lighting Plan	
JOB NO.	1384
DATE	15/01/2021
SCALES	1:50/1:100
DRAWN BY	W.V.
CHECKED BY	
DWG NO.	1384/03
SHEET NO.	Sheet 1
© Copyright Rosper Estates Limited	