
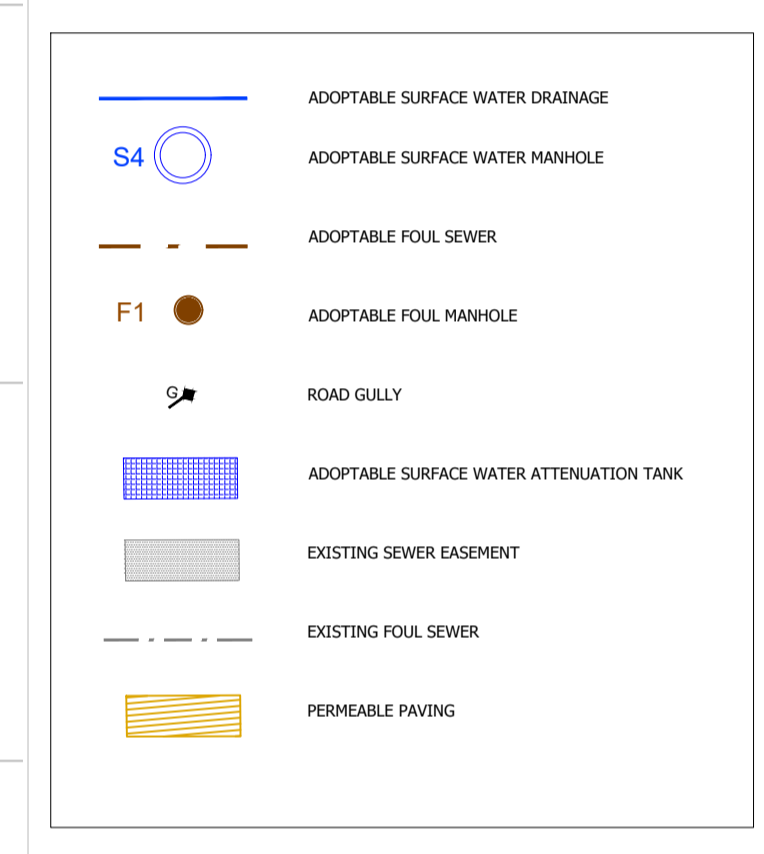


- General Notes
1. DO NOT SCALE.
 2. This drawing is to be read in conjunction with all other project drawings and specifications.
 3. All dimensions are in millimetre's unless otherwise stated.
 4. Should there be any conflict between the details indicated on this drawing and those indicated on other drawings the Project Engineer shall be informed PRIOR to construction on site.
 5. Until technical approval has been obtained from the relevant Authority, it should be understood that all drawings issued are Preliminary and NOT for construction. Should the Contractor commence site work prior to such approval being given, it is entirely at his own risk

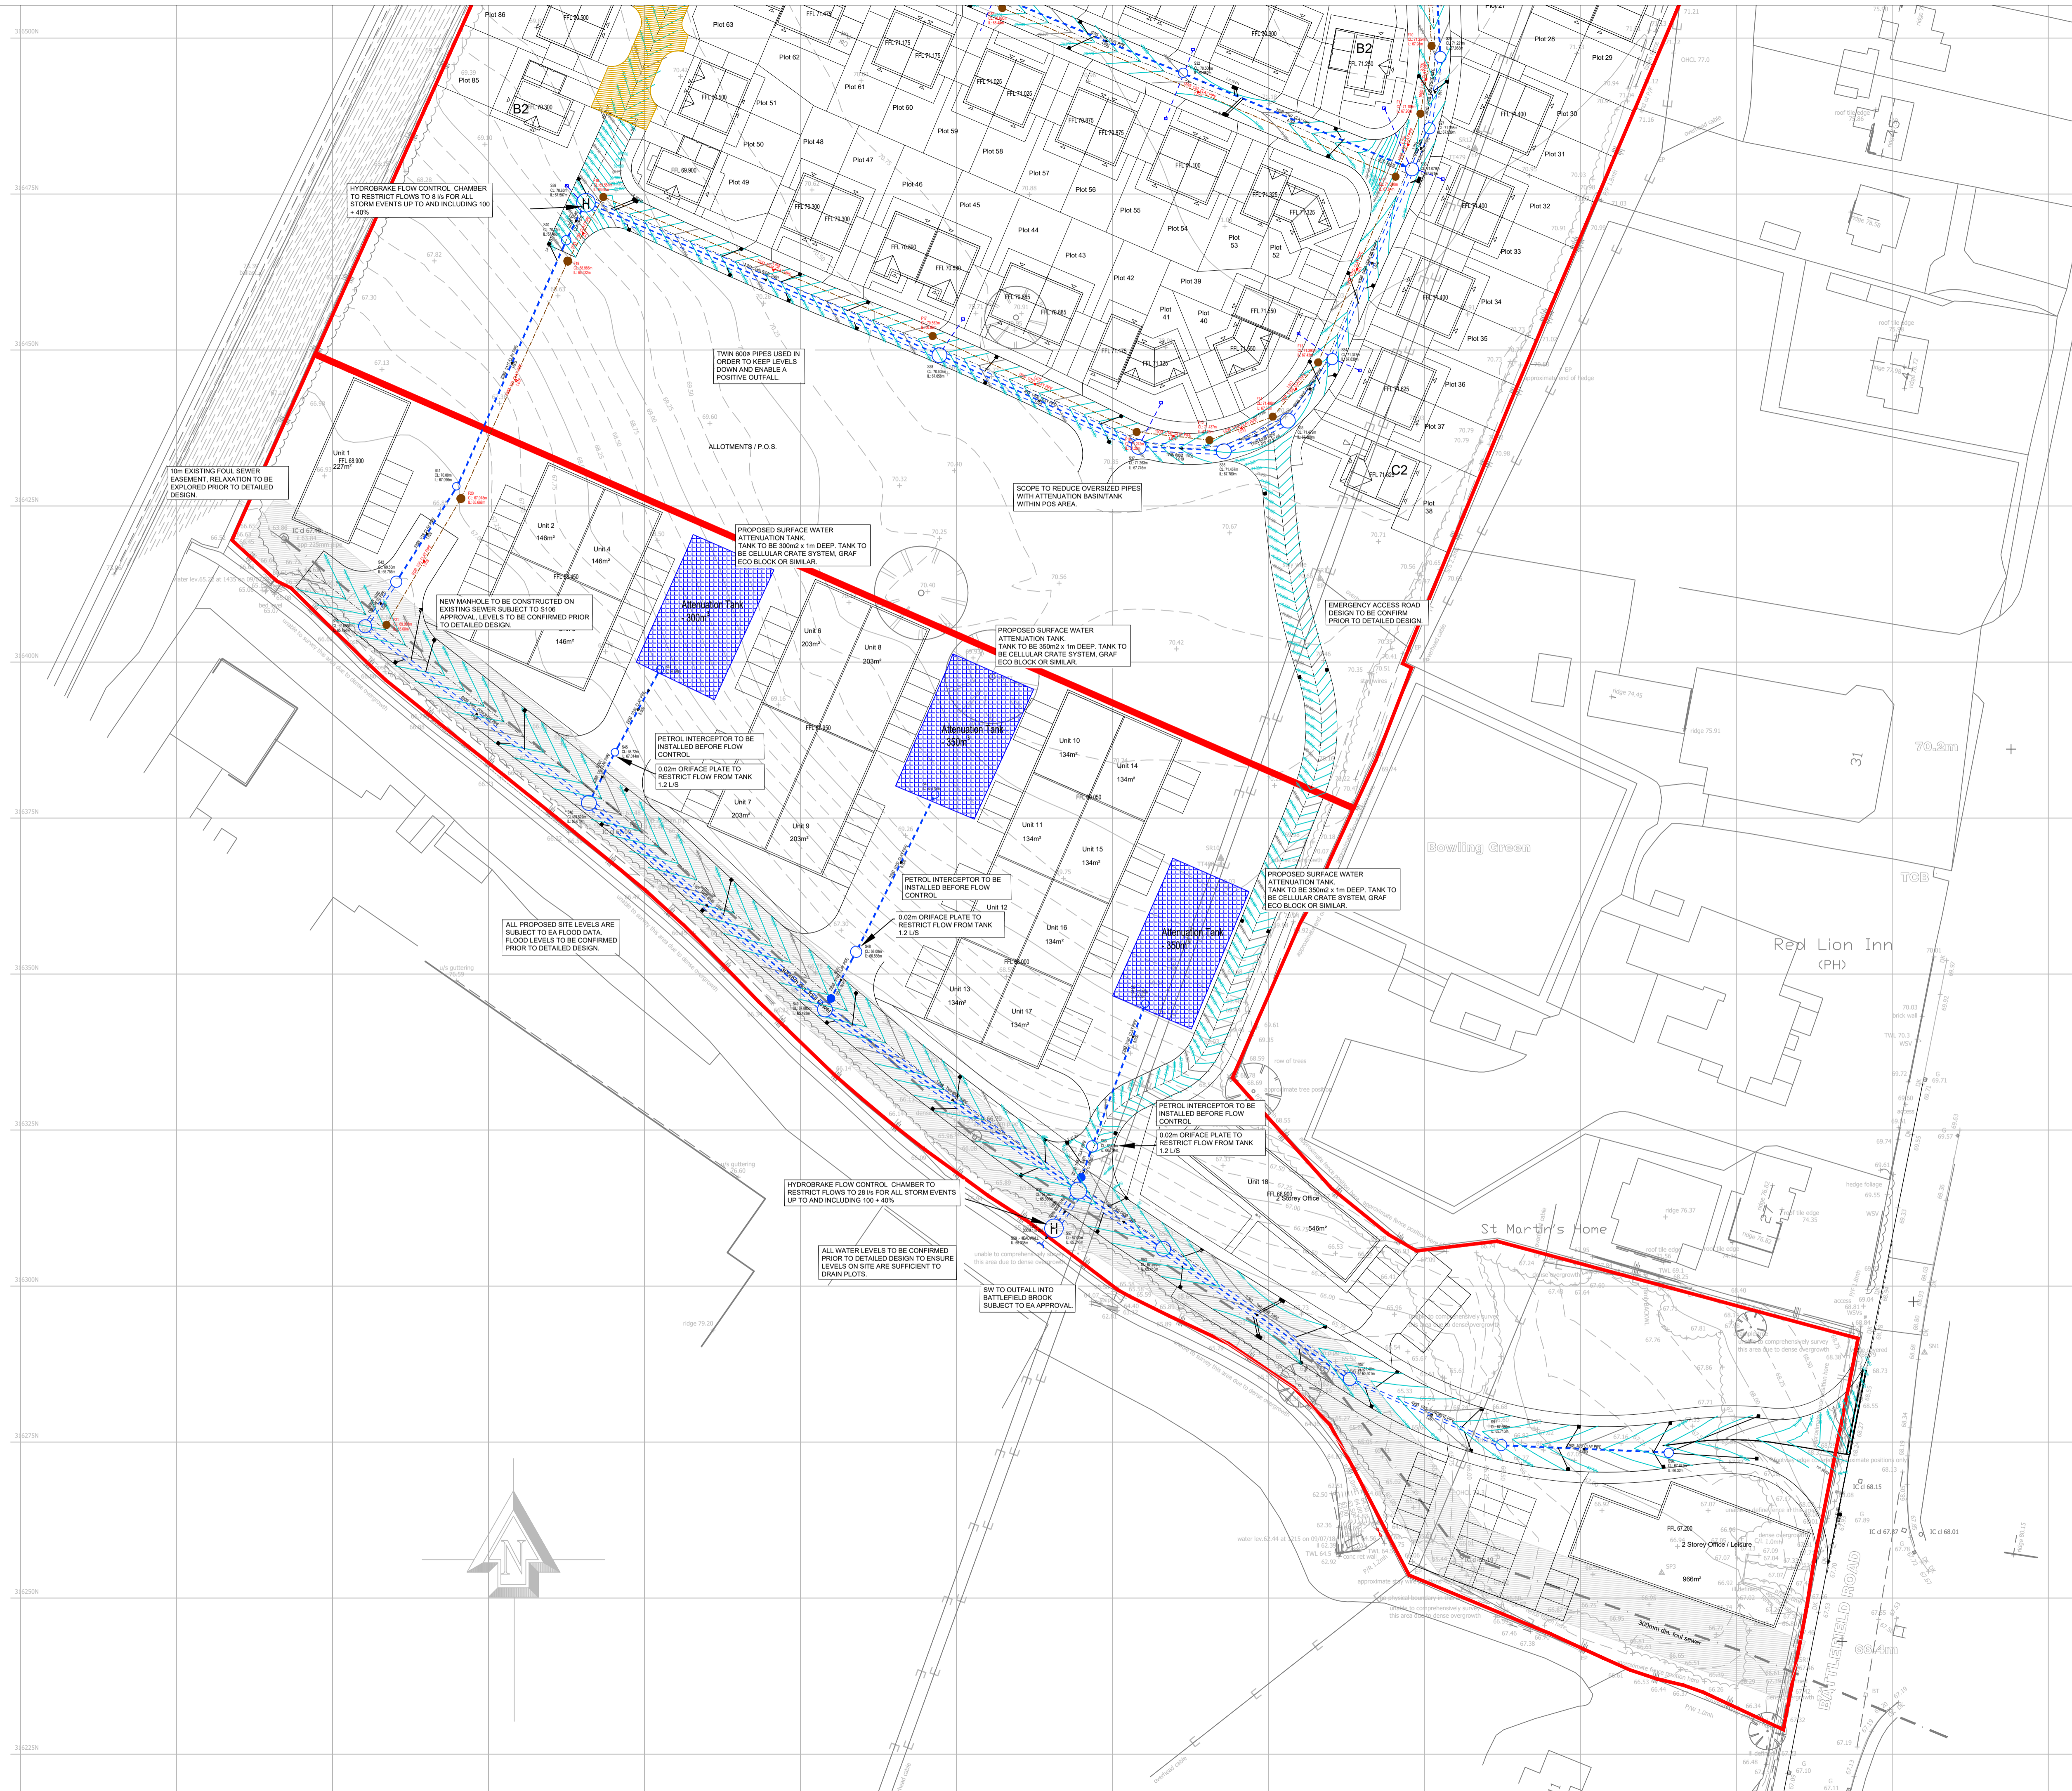

REV	AMENDMENT	BY	CHK	DATE	
 PROJECT EXECUTION CLASS: S3 <small>All materials supplied in relation to those specified on this drawing are to be CE marked in accordance with the European Union Declaration of conformity</small>					
DRAWING STATUS					
PRELIMINARY					
 CONSULTING ENGINEERS LTD CIVIL STRUCTURAL DESIGN The Old Church Offices Shelton New Road Hartshill, Stoke on Trent ST4 6DF Email: mail@2cconsulting.co.uk Telephone: 01782 980330					
CLIENT					
JESSUP BROTHERS LIMITED					
PROJECT					
BATTLEFIELDS					
DRAWING TITLE					
STRATEGIC DRAINAGE PLAN - Sheet 2 of 2					
SHEET SIZE	SCALE	DATE	DRAWN	CHECKED	STATUS
A1	1:500	29.10.20	DW	GS	S3
PROJECT No.	DRAWING No.				REV
200498	C2C - XX - XX - P - C		104		P01