
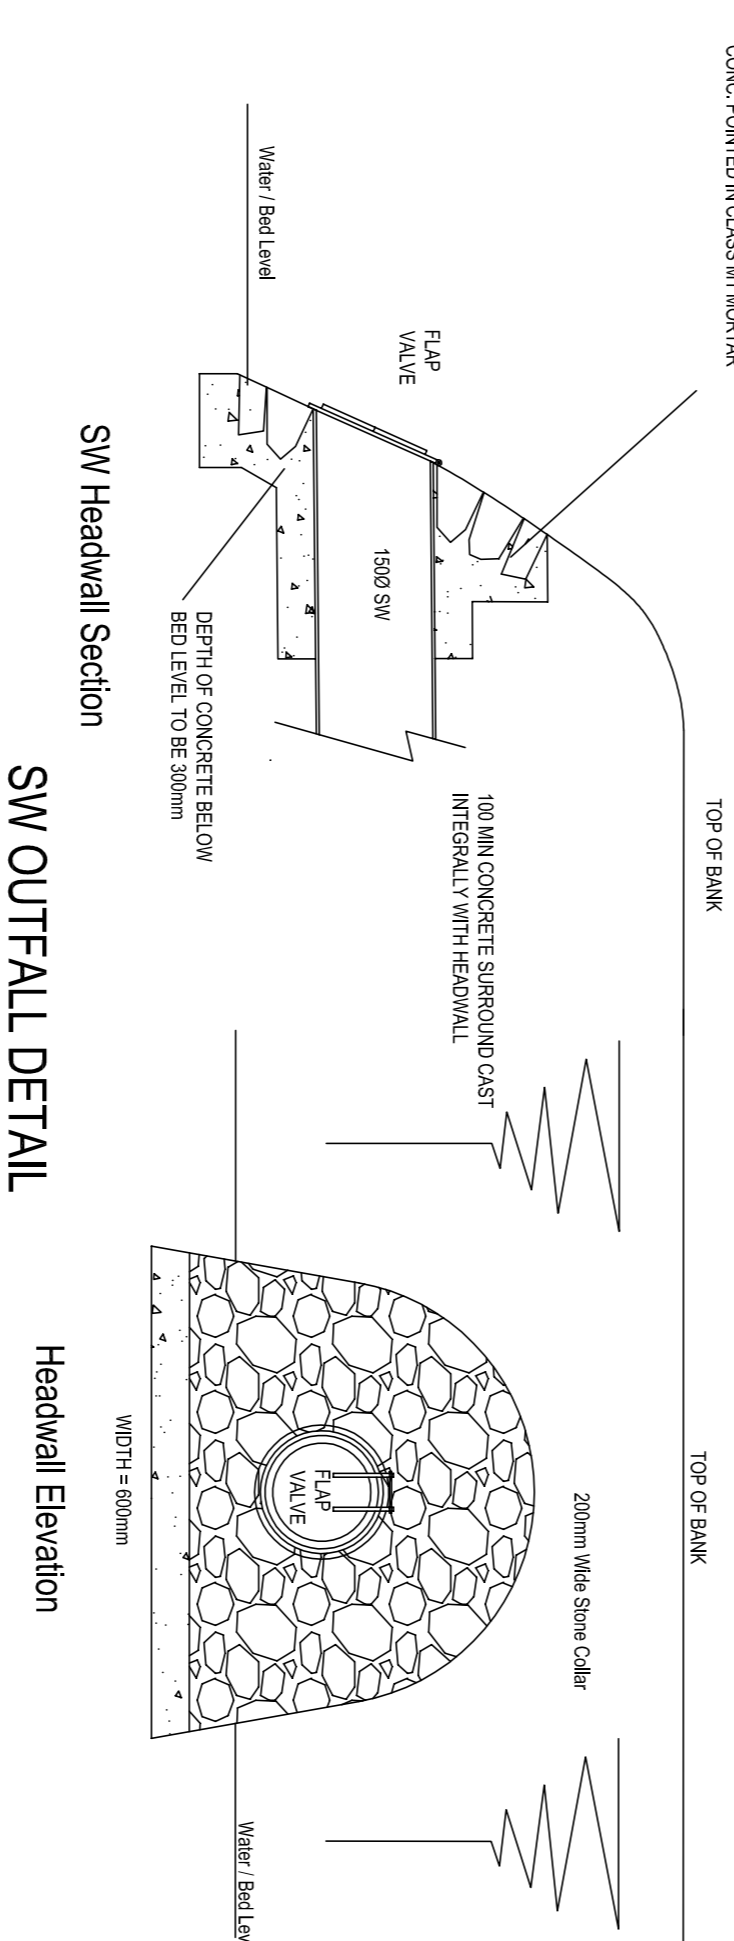
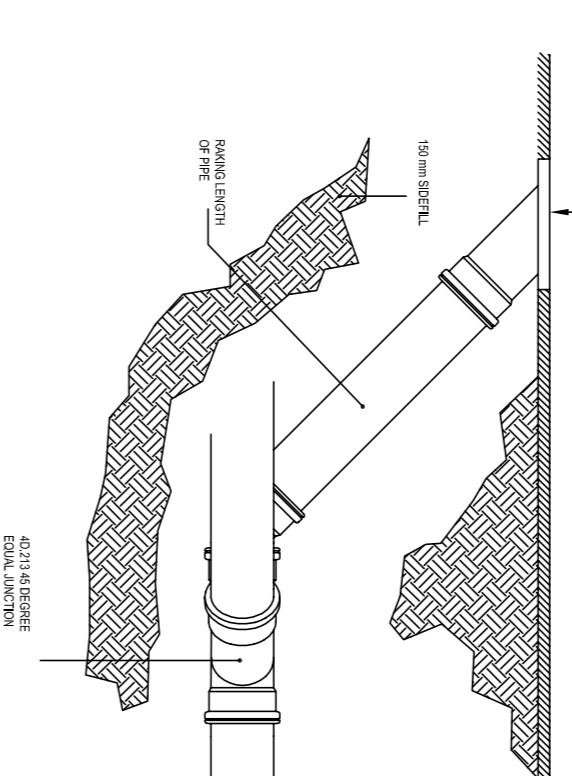
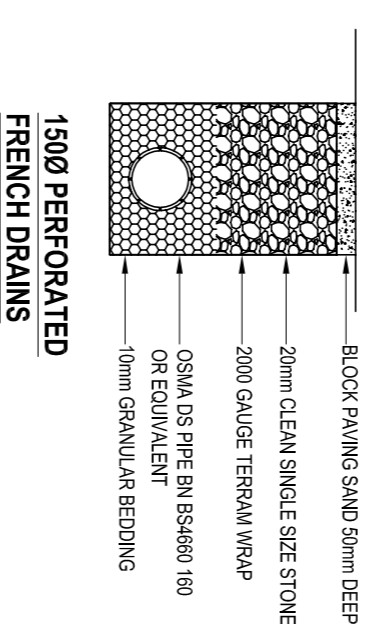
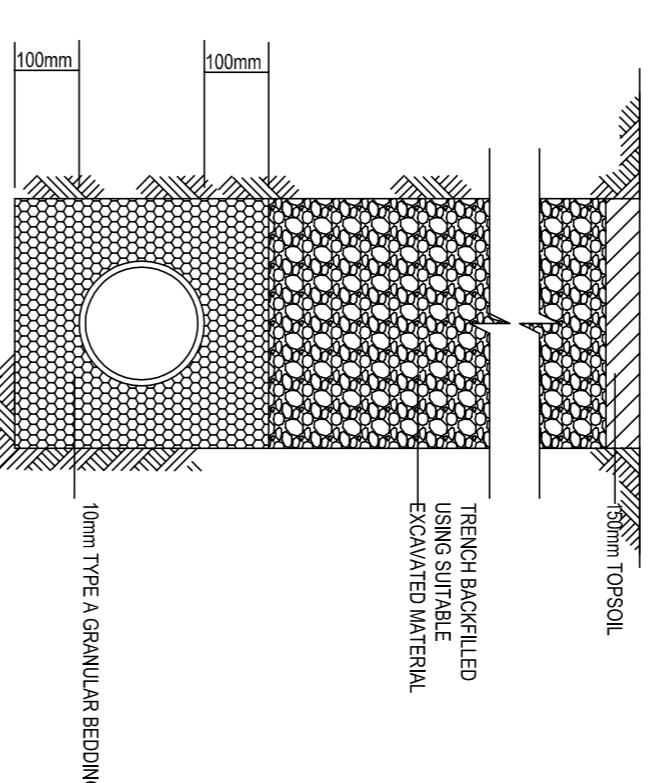
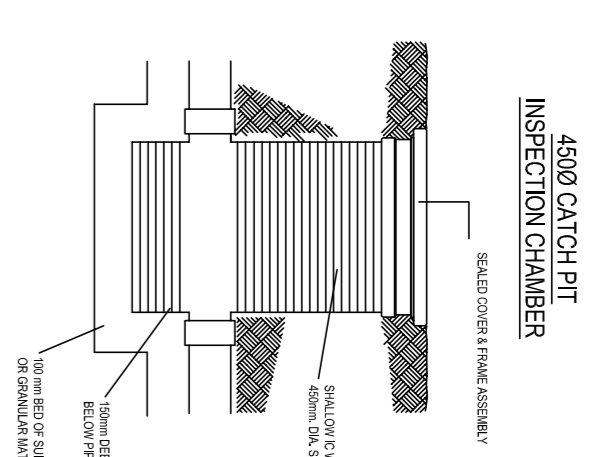
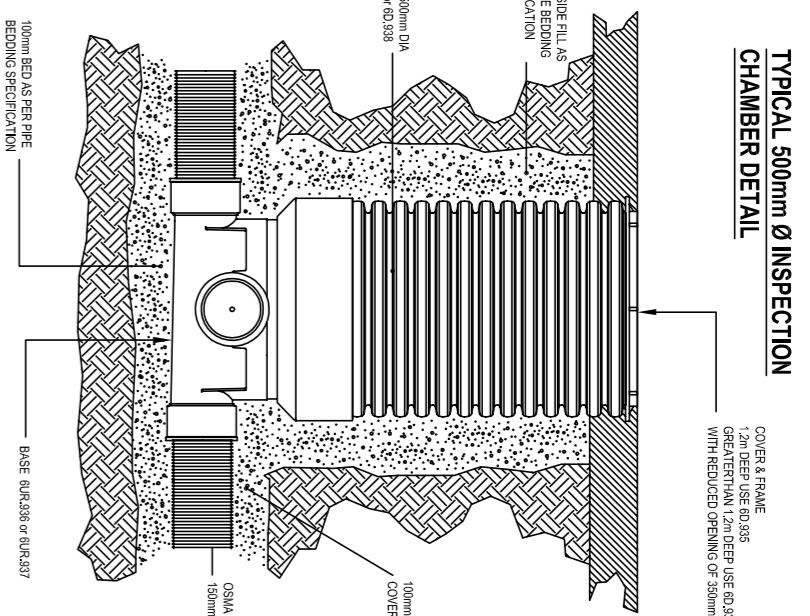
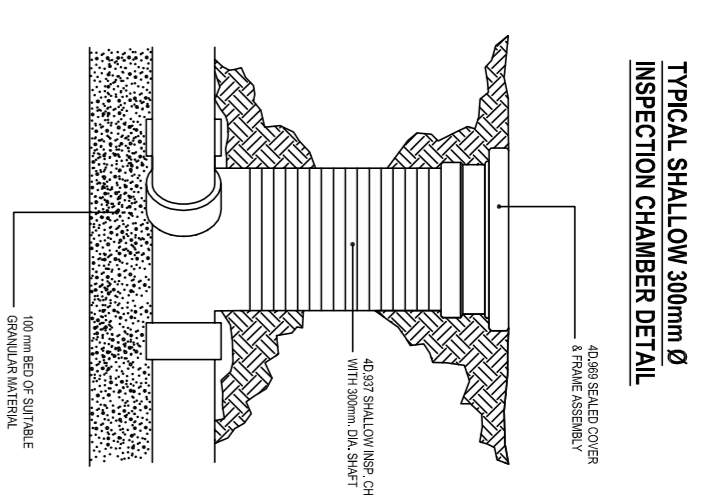


<<< LIGGARD BROOK

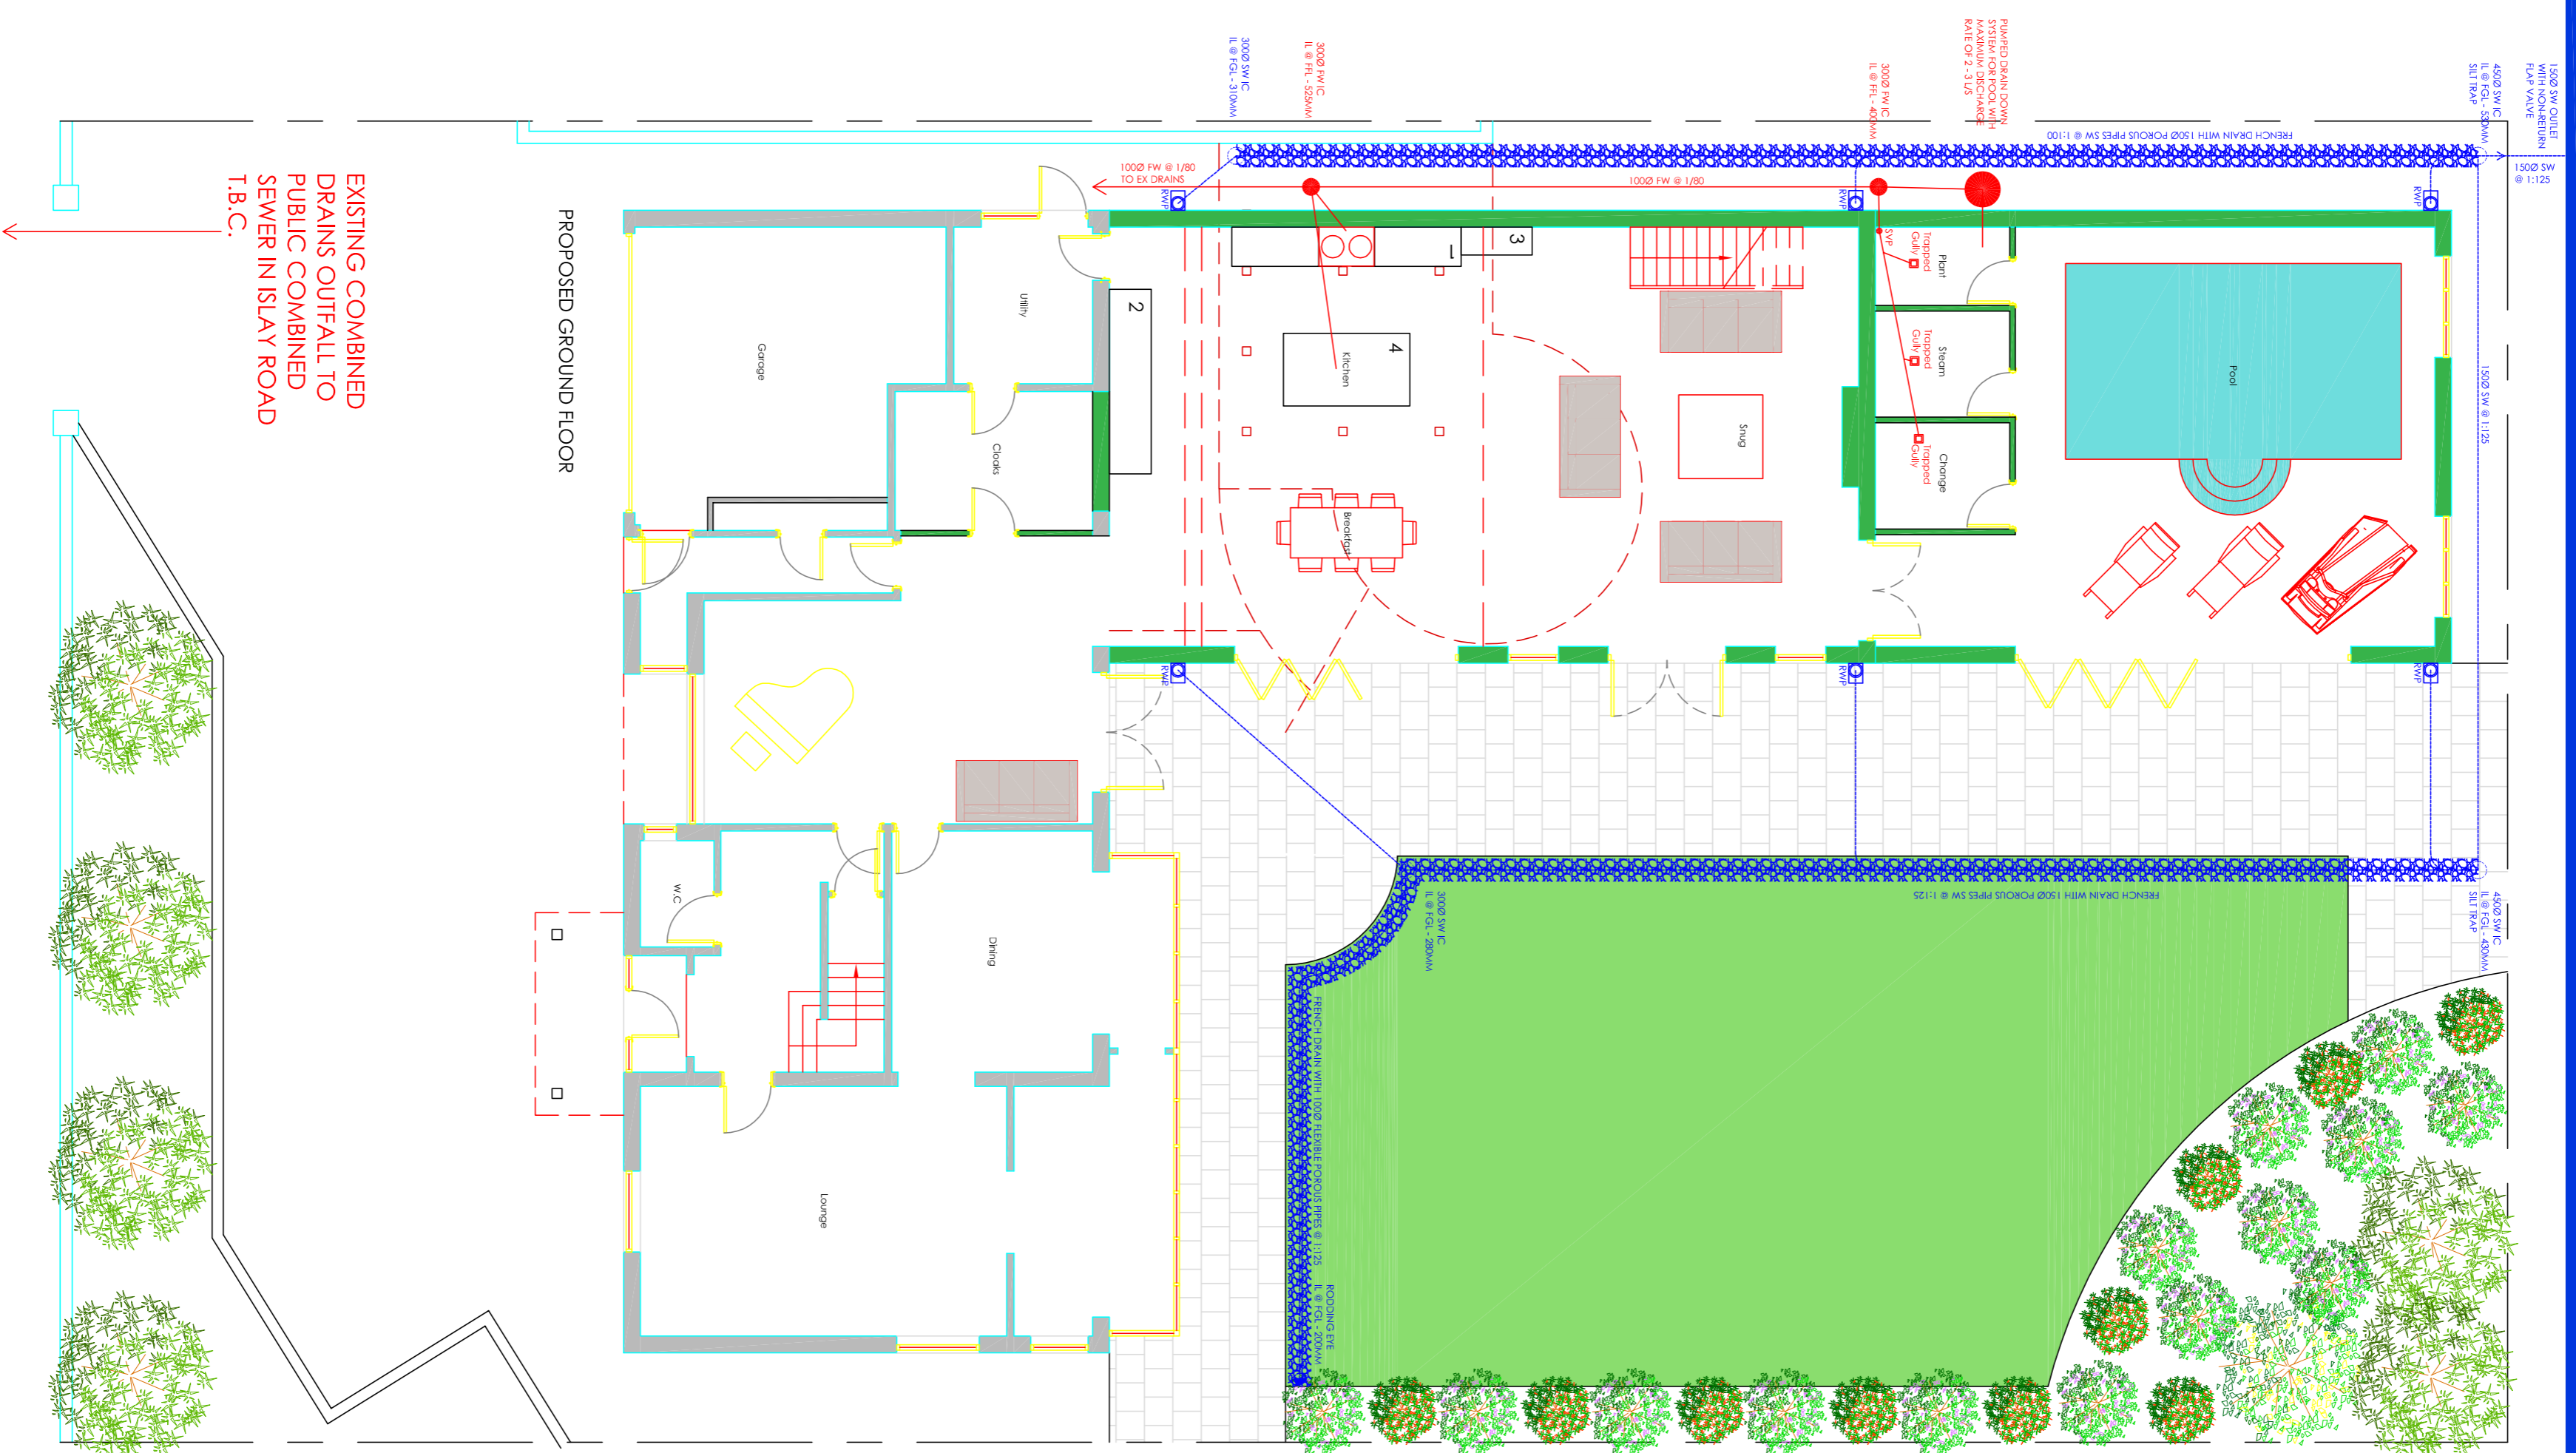

CONSTRUCTION DETAILS: 1/20

Rev	Details	By	Date

Hamilton Technical Services
 Civil & Environmental Engineering Consultants

1 Chiltern Ave.,
 Euxton, Chorley,
 Lancs., PR7 6NU

Tel: 01237 278838
 Mob: 07977 880913
 email: hte@hamiltonservices.com

Client: **MR BEN MORRIS**
 26 ISLAY ROAD
 LITTHAM

Project: **PROPOSED REAR EXTENSION**

Title: **PROPOSED DRAINAGE LAYOUT AND CONSTRUCTION DETAILS**

Project No: **C-0949-01**

Issue: 1
 Date: 17/12/2020
 Drawn: RSH
 Checked: TMO/BAH