


THIS DRAWING REFLECTS DESIGN INTENT ONLY.
 RYBKA LTD. DO NOT ACCEPT ANY LIABILITY REGARDING THE ACCURACY & VERACITY OF INFORMATION PROVIDED BY OTHERS USED IN THE PREPARATION OF THIS DRAWING.
 THIS DRAWING TO BE READ IN CONJUNCTION WITH ALL OTHER RELEVANT DRAWINGS & SPECIFICATIONS.
 ALL DIMENSIONS AND SIZES ARE IN MILLIMETRES UNLESS OTHERWISE STATED.
 DO NOT SCALE FROM THIS DRAWING.
 FOR KEY TO DRAWINGS GRAPHICAL SYMBOLS SEE SYMBOLS LEGEND.

NOTES

- ALL ELECTRICAL WORKS SHALL BE UNDERTAKEN IN ACCORDANCE WITH BS7671: 2018, INCLUDING ALL CURRENT AMENDMENTS, AND IN ACCORDANCE WITH BUILDING STANDARDS (SCOTLAND) REGULATIONS.
- ALL DRAWINGS SHALL BE READ IN CONJUNCTION WITH THE SPECIFICATION, SCHEDULES AND MECHANICAL SERVICES DRAWINGS.
- THE CONTRACTOR SHALL REFER ANY DISCREPANCIES ON THIS DRAWING BACK TO THE ORIGINATOR PRIOR TO THE COMMENCEMENT OF ANY PROCUREMENT OR INSTALLATION WORKS.
- ALL CABLE CLIPS, FIXINGS, SADDLES AND ACCESSORIES SHALL BE PROPRIETARY DEVICES AS APPROVED AND RECOMMENDED BY THE CABLE OR ELECTRICAL ACCESSORY MANUFACTURER.
- ANY PENETRATIONS CREATED THROUGH A FIRE COMPARTMENT OR FIRE SEALED WALL TO BE CORRECTLY SEALED/RE-SEALED TO MAINTAIN THE RESPECTIVE FIRE RATING OF THE FIRE COMPARTMENT.
- THE LOCATIONS OF ALL ELECTRICAL CONNECTIONS AND ACCESSORIES SHOWN ON THIS DRAWING ARE INDICATIVE AND SHOW DESIGN INTENT. UNLESS OTHERWISE NOTED, THE EXACT LOCATION OF THESE OUTLETS SHALL BE CO-ORDINATED ON SITE TO BE LOCATED TO SUIT THE EQUIPMENT THAT THEY SERVE.
- ALL WALL MOUNTED ACCESSORIES WITHIN FIRE OR ACOUSTIC RATED WALLS SHALL BE FITTED WITH INTUMESCENT PADS TO MAINTAIN THE FIRE/ACOUSTIC RATING OF THE RESPECTIVE WALL.
- THE ELECTRICAL CONTRACTOR SHALL BE RESPONSIBLE FOR MAKING ALL FINAL CONNECTIONS BETWEEN THE ISOLATING DEVICE AND THE EQUIPMENT BEING SERVED. ALL ISOLATORS TO BE LABELLED TO IDENTIFY THE EQUIPMENT SERVED.
- THE PHASING, PROGRAMMING AND SEQUENCING OF ALL WORKS TO BE AGREED PRIOR TO WORKS COMMENCING.
- THE CONTRACTOR SHALL ALLOW FOR ALL EARTHING AND EQUIPOTENTIAL BONDING REQUIRED TO PROVIDE COMPLIANCE WITH BS7671:2018 AND BS7430:2011 INCLUDING ALL CURRENT AMENDMENTS.
- ALL OUTLETS SHALL BE POSITIONED IN COMPLIANCE WITH BS 8300-2 :2018, INCLUDING ALL CURRENT AMENDMENTS. THIS APPLIES TO BOTH HORIZONTAL AND VERTICAL POSITIONING.
- THE ELECTRICAL CONTRACTOR SHALL BE RESPONSIBLE FOR CO-ORDINATING THE GENERAL POWER INSTALLATION WITH ALL MECHANICAL SERVICES INSTALLATIONS BEING INSTALLED.
- ALL ISOLATORS AND FUSED CONNECTION UNITS THAT SUPPLY FIXED ELECTRICAL EQUIPMENT SHALL BE LABELLED TO NOTE THE ITEM OF EQUIPMENT BEING SERVED.
- ALL ELECTRICAL ACCESSORIES AND ISOLATORS SHALL BE LABELLED TO NOTE THEIR SOURCE DISTRIBUTION BOARD AND FINAL CIRCUIT REFERENCE.
- OUTLETS INSTALLED WITHIN INTERNAL PARTITION WALLS SHALL NOT BE INSTALLED DIRECTLY 'BACK-TO-BACK' AND SHALL INSTEAD BE OFFSET IN ORDER TO MINIMISE ACOUSTIC LEAKAGE THROUGH THE WALLS.
- ALL FIRE ALARM WORKS SHALL BE UNDERTAKEN IN ACCORDANCE WITH BSS839 PART 1: 2017 INCLUDING ALL CURRENT AMENDMENTS.
- ALL FIRE ALARM WIRING SHALL BE CARRIED OUT IN RED SHEATHED SOFTSKIN ENHANCED FIRE RATED CABLING.
- ON COMPLETION OF THE FIRE ALARM INSTALLATION THE CONTRACTOR SHALL;
 - TEST AND COMMISSION THE FIRE ALARM SYSTEM AS REQUIRED BY BS 5839 AND ALL CURRENT AMENDMENTS.
 - PREPARE AND SUBMIT TO THE CLIENT ALL APPROPRIATE CERTIFICATION AND LOG BOOKS.

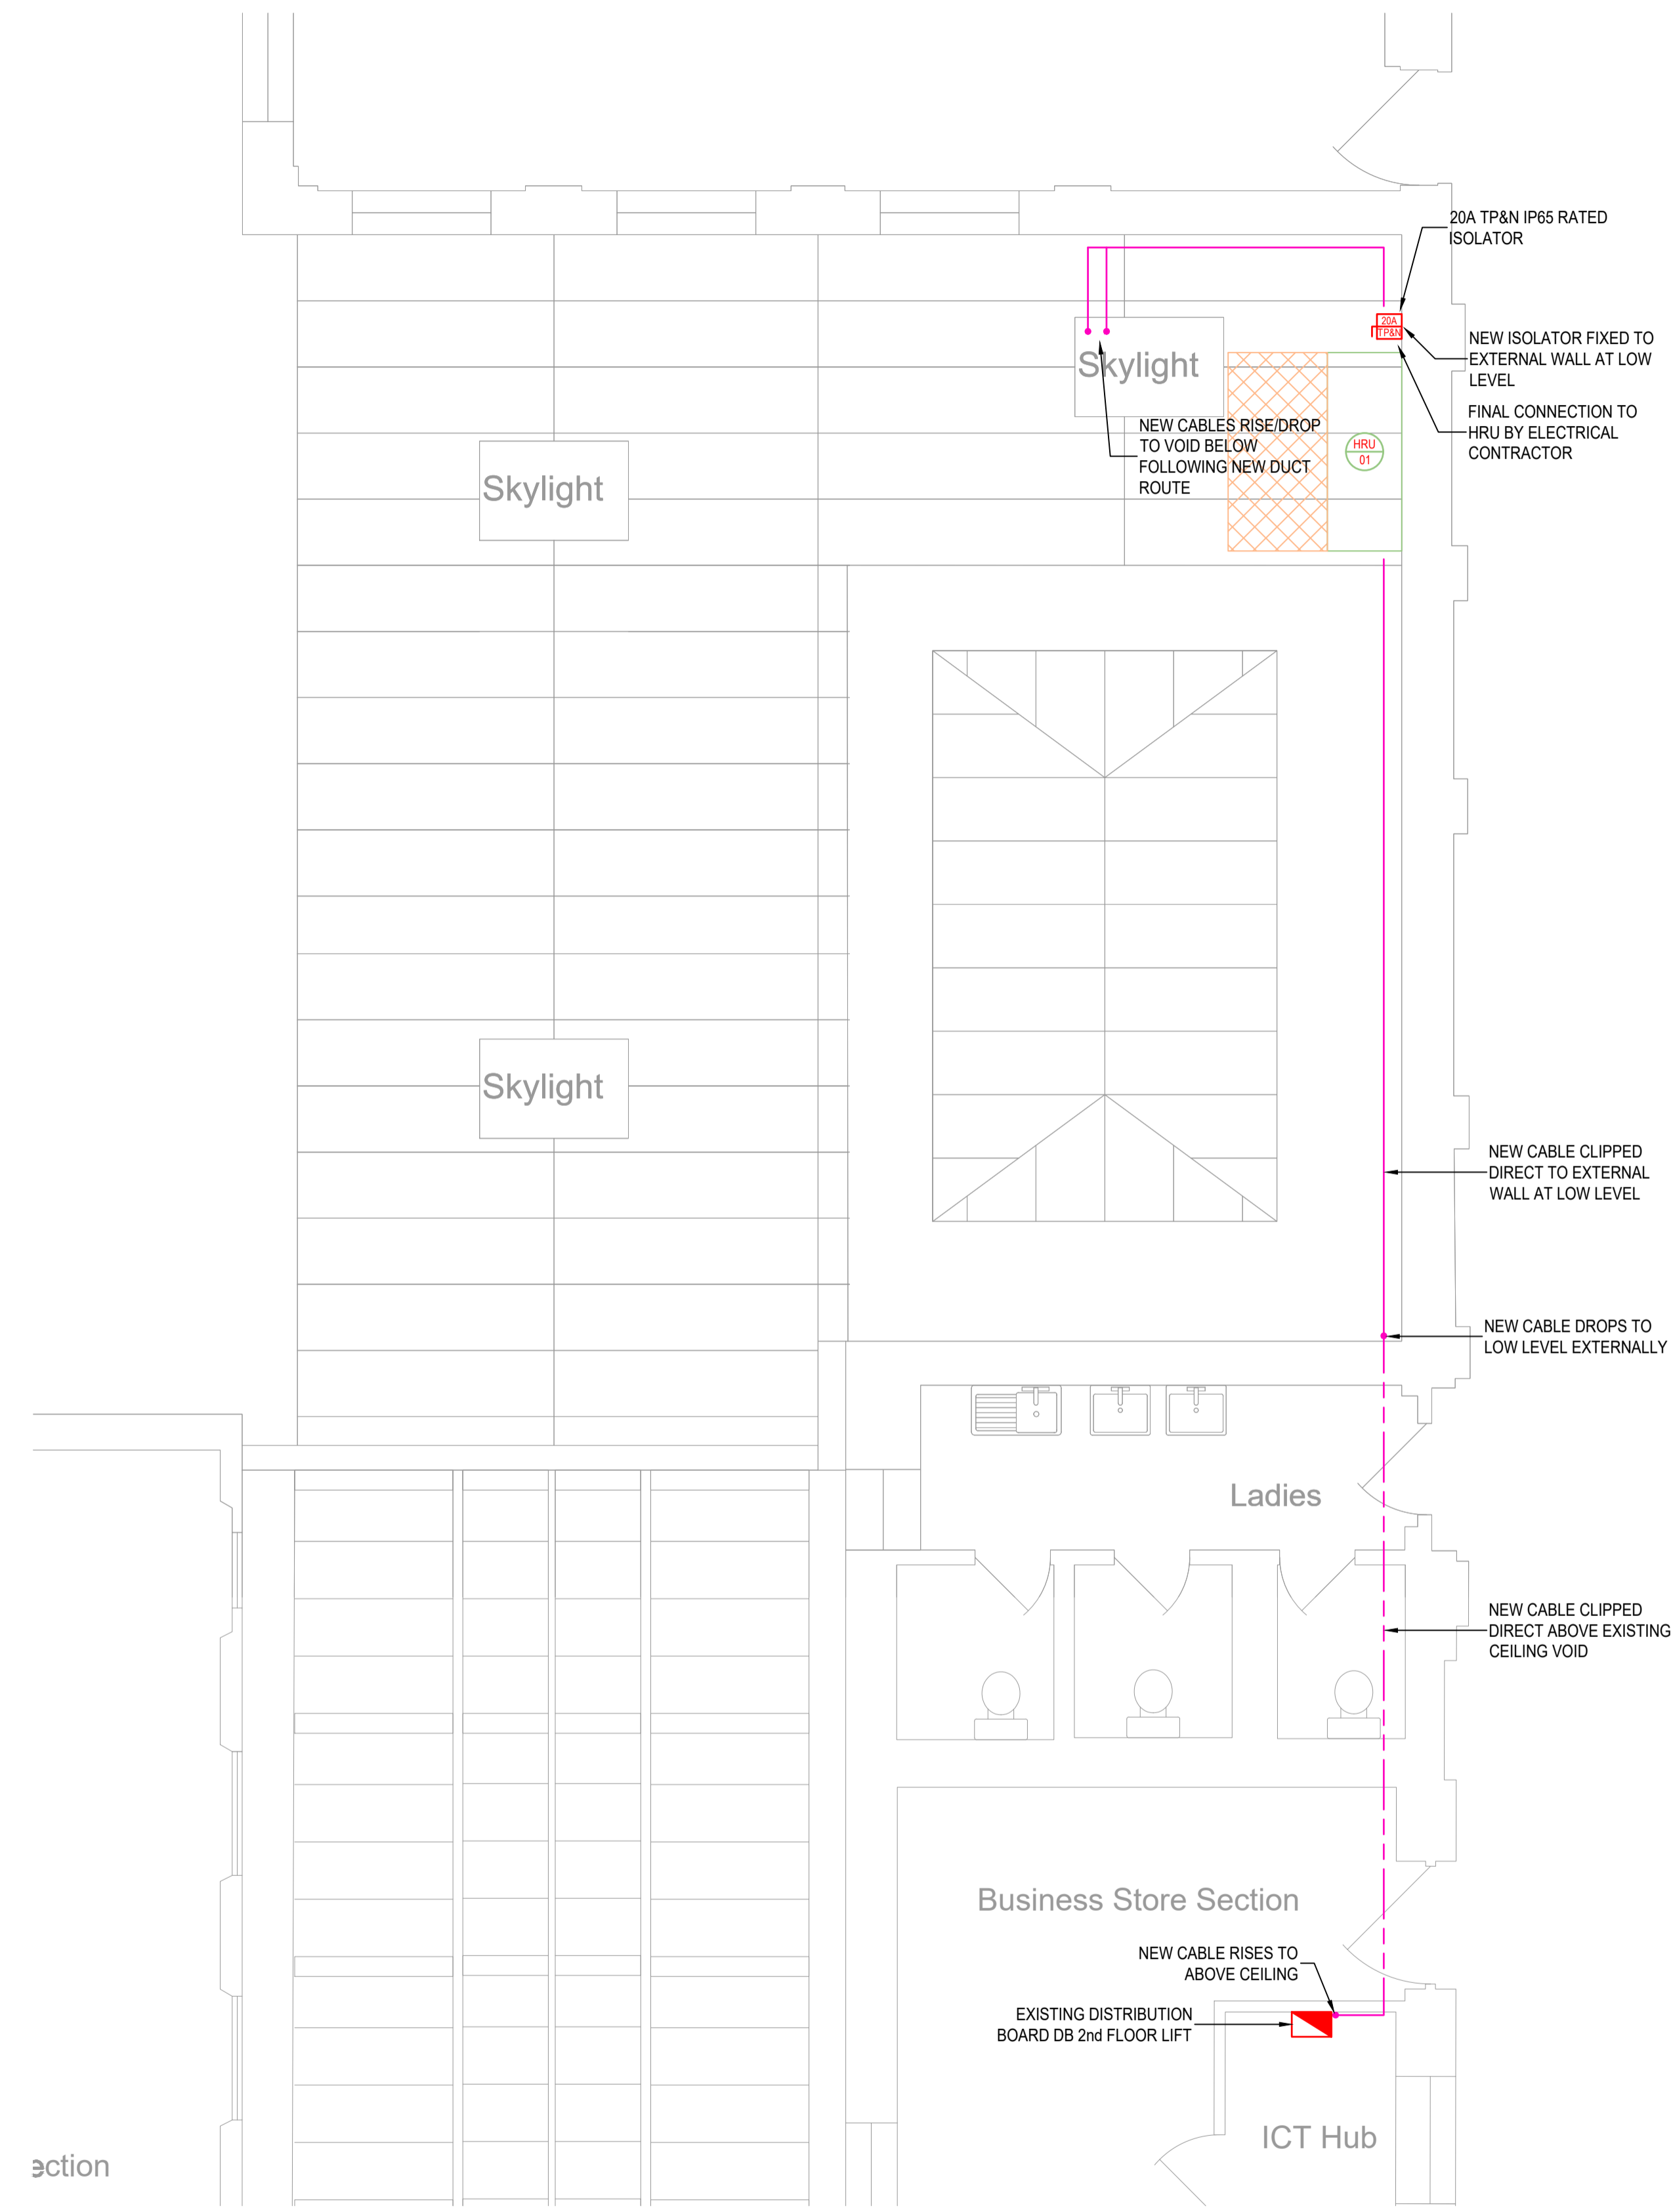

REV	DATE	BY	DESCRIPTION	CHKD
02	18/12/20	AKS	TENDER ISSUE	AKS
01	09/10/20	SR	TENDER ISSUE	AKS

DRAWING STATUS	TENDER
CLIENT	INVERCLYDE COUNCIL
PROJECT NUMBER	520.007.00
PROJECT TITLE	GREENOCK MUNICIPAL BUILDINGS AHU
DRAWING TITLE	SECOND FLOOR PLAN, PROPOSED ELECTRICAL WORKS

RYBKA

Cadell House, 27 Waterloo Street, Glasgow, G2 6BZ
 t +44 (0)141 221 2334
 e info@rybka.co.uk w rybka.co.uk
 Rybka Limited, Building Services Engineering Consultants

SCALE	DRAWN	DATE	CHECKED	PASSED
1:50@A1	SR	01/10/20	SR	-
DRAWING NUMBER	GMB-RYB-XX-02-DR-E-6001			REVISION
				02