



FLOOR PLAN

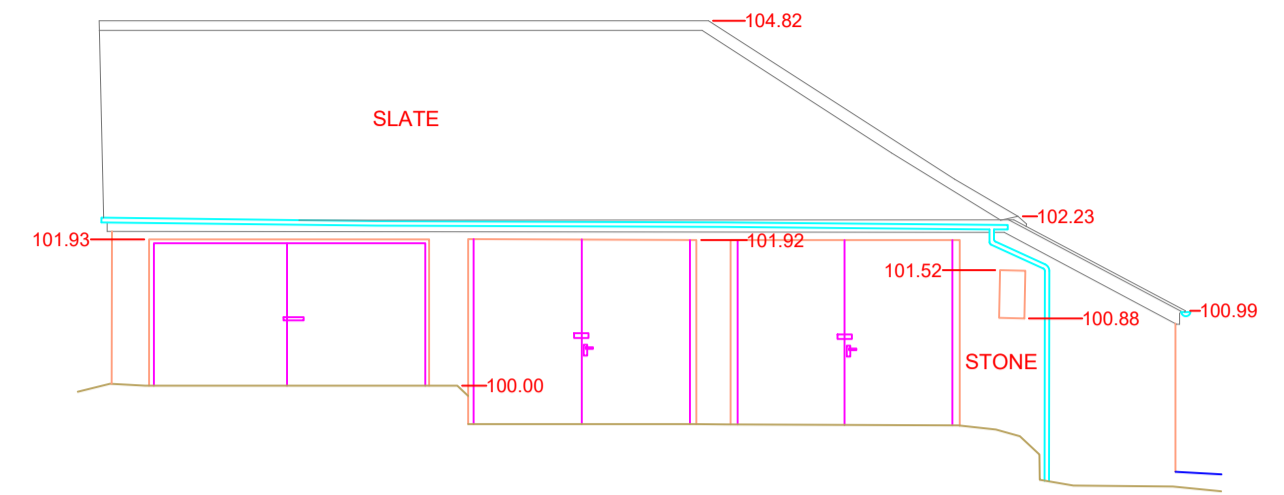


FRONT ELEV

DATUM 90M

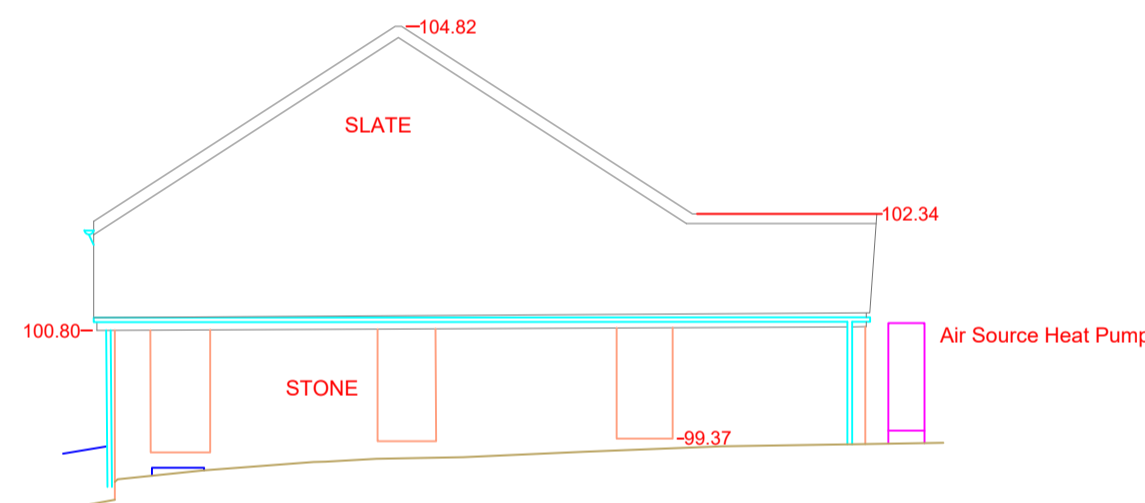


RIGHT ELEV

DATUM 90M

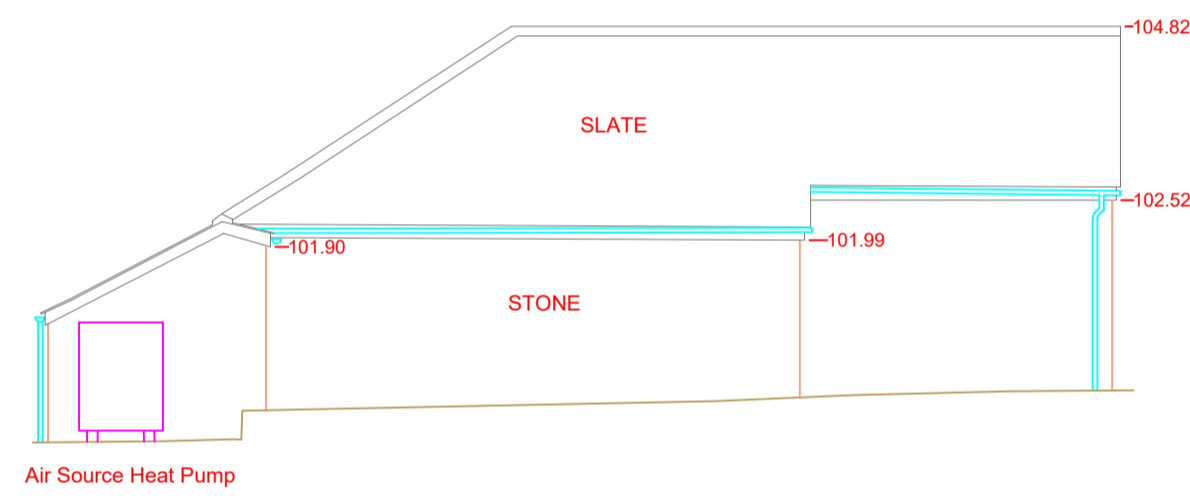

REAR ELEV

DATUM 90M

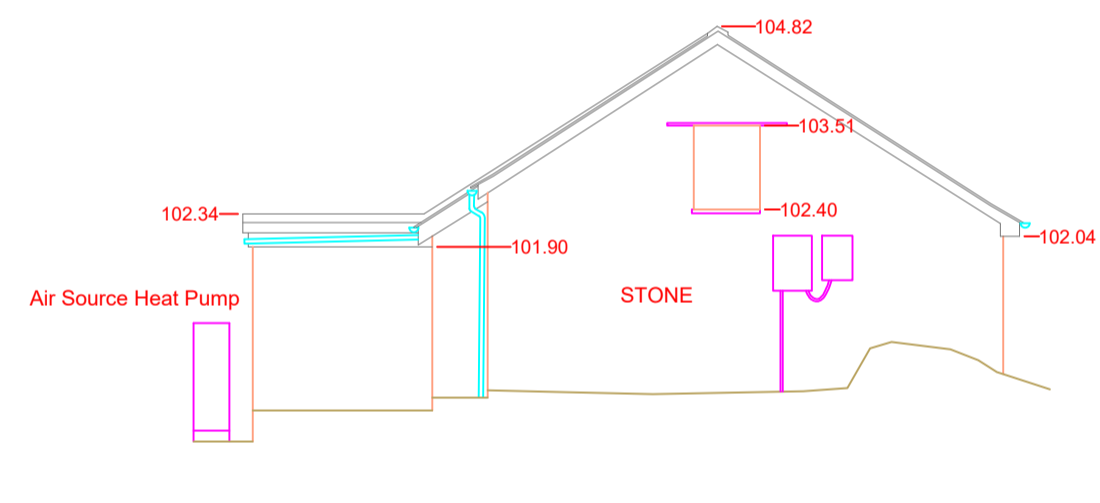

LEFT ELEV

DATUM 90M



SCALE BAR (METERS)

LEGEND			
UTILITY LINETYPES	Gas	Heating Pipes	Multiple Services Route
British Telecom	Gas	Heating Pipes	Multiple Services Route
Cable Television	Gas	Heating Pipes	Multiple Services Route
Closed Circuit Television	Gas	Heating Pipes	Multiple Services Route
Communications	Gas	Heating Pipes	Multiple Services Route
Drainage	Gas	Heating Pipes	Multiple Services Route
Drainage - Combined Water	Gas	Heating Pipes	Multiple Services Route
Drainage - Fuel Water	Gas	Heating Pipes	Multiple Services Route
Drainage - Storm Water	Gas	Heating Pipes	Multiple Services Route
Empty Duct	Gas	Heating Pipes	Multiple Services Route
Electric	Gas	Heating Pipes	Multiple Services Route
Fire Hydrant Man	Gas	Heating Pipes	Multiple Services Route
Fire Duct	Gas	Heating Pipes	Multiple Services Route
Fuel	Gas	Heating Pipes	Multiple Services Route
Assumed Service Route - See GENERAL NOTES (Using abbreviation of service and colour as above)	Gas	Heating Pipes	Multiple Services Route
UTILITY SURVEY INFORMATION	Unable to Survey	Unable to Trace	Unable to Trace Further
Located by Ground Penetrating Radar	GPR	Unable to Trace	Unable to Trace Further
Area of Concern	Unable to Trace	Unable to Trace Further	End of Trace
Contracted Survey Area	Unable to Trace	Unable to Trace Further	End of Trace
Previous Survey Area	Unable to Trace	Unable to Trace Further	End of Trace
Depth to Top of Service (metres)	(0.000)	Unable to Trace Further	End of Trace
ABREVIATIONS used on a PAS 128 Survey (0.050 B2P) 0.050 = Depth in metres, B2 = Quality Level, P = Post processed GPR	Unable to Trace	Unable to Trace Further	End of Trace
TOPOGRAPHIC & UTILITY DETAILS	Unable to Trace	Unable to Trace Further	End of Trace
Barrier (symbol - sized)	Post (symbol)	Rain Water Pipe (symbol)	UTL
Beltline Beacon (symbol)	Road Sign (symbol)	Road Sign (symbol)	UTL
Bollard (symbol)	Road Sign (symbol)	Road Sign (symbol)	UTL
Bombhole (symbol)	Road Sign (symbol)	Road Sign (symbol)	UTL
British Telecoms IC	Road Sign (symbol)	Road Sign (symbol)	UTL
Building (incomplete detail)	Road Sign (symbol)	Road Sign (symbol)	UTL
Cable into Ground (symbol)	Road Sign (symbol)	Road Sign (symbol)	UTL
Cable TV Box (symbol)	Road Sign (symbol)	Road Sign (symbol)	UTL
CCTV Camera	Road Sign (symbol)	Road Sign (symbol)	UTL
Cover Level in metres	Road Sign (symbol)	Road Sign (symbol)	UTL
Direction of Flow (Drainage)	Road Sign (symbol)	Road Sign (symbol)	UTL
Distribution Board (symbol)	Road Sign (symbol)	Road Sign (symbol)	UTL
Earth Rod (symbol)	Road Sign (symbol)	Road Sign (symbol)	UTL
Electric Cabinet	Road Sign (symbol)	Road Sign (symbol)	UTL
Electric Pole (symbol)	Road Sign (symbol)	Road Sign (symbol)	UTL
Electric Sign (symbol)	Road Sign (symbol)	Road Sign (symbol)	UTL
Embankment	Road Sign (symbol)	Road Sign (symbol)	UTL
Fender Pipe	Road Sign (symbol)	Road Sign (symbol)	UTL
Fire Hydrant	Road Sign (symbol)	Road Sign (symbol)	UTL
Flag Pole (symbol)	Road Sign (symbol)	Road Sign (symbol)	UTL
Fall Roof Level in metres	Road Sign (symbol)	Road Sign (symbol)	UTL
Flood Light (symbol)	Road Sign (symbol)	Road Sign (symbol)	UTL
Gas Valve (symbol)	Road Sign (symbol)	Road Sign (symbol)	UTL
Gate	Road Sign (symbol)	Road Sign (symbol)	UTL
Ground Level in metres	Road Sign (symbol)	Road Sign (symbol)	UTL
Gully	Road Sign (symbol)	Road Sign (symbol)	UTL
Inspection Cover	Road Sign (symbol)	Road Sign (symbol)	UTL
Insert Level in metres	Road Sign (symbol)	Road Sign (symbol)	UTL
Junction Box - BT	Road Sign (symbol)	Road Sign (symbol)	UTL
Junction Box - Comm	Road Sign (symbol)	Road Sign (symbol)	UTL
Junction Box - Elec	Road Sign (symbol)	Road Sign (symbol)	UTL
Light Bollard (symbol)	Road Sign (symbol)	Road Sign (symbol)	UTL
Light in ground (symbol)	Road Sign (symbol)	Road Sign (symbol)	UTL
Manhole	Road Sign (symbol)	Road Sign (symbol)	UTL
Manhole Capped Port	Road Sign (symbol)	Road Sign (symbol)	UTL
Parapet Level in metres	Road Sign (symbol)	Road Sign (symbol)	UTL
Pipe Diameter in millimetres	Road Sign (symbol)	Road Sign (symbol)	UTL
Pipe into Ground (symbol)	Road Sign (symbol)	Road Sign (symbol)	UTL

Rev	Notes	Drawn	Date
-----	-------	-------	------

Notes:

Survey is referenced to OS Grid and Level Datum.



Survey Dimensions Ltd T +44 (0)7970 205 932  
T +44 (0)7970 205 935  
E info@SurveyDimensions.co.uk  
W www.SurveyDimensions.co.uk

Title: Plans and Elevations

Client: Mr and Mrs Gay

Project: Garages At Mulvra Stables, London Apprentice.

Date Completed: 28/11/20 Post Code: PL26 7AP

Surveyed: ATC Scale: 1:100 / A1 Sheet  
Drawn: Pdw  
Checked: ATC

Job No: 201131 Dwg No: 01 Rev: -