


# EXISTING




Front Elevation

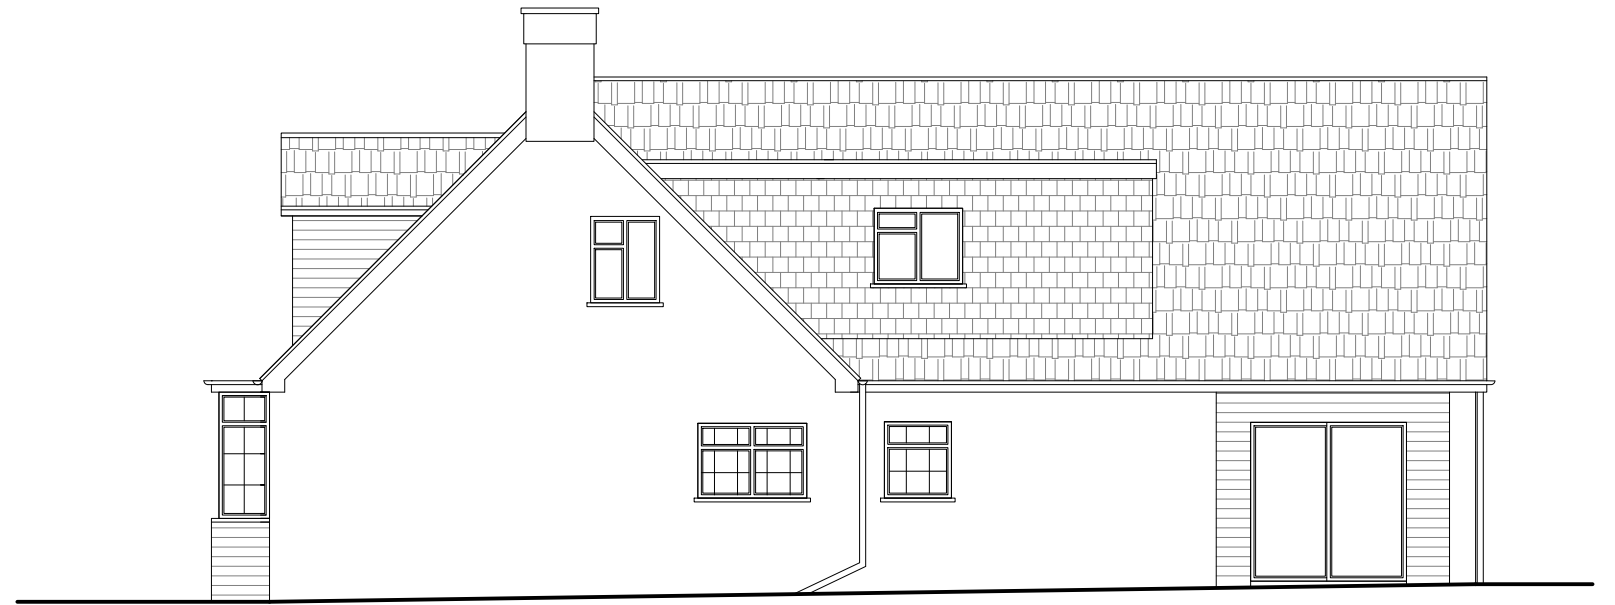


Side Elevation



Rear Elevation

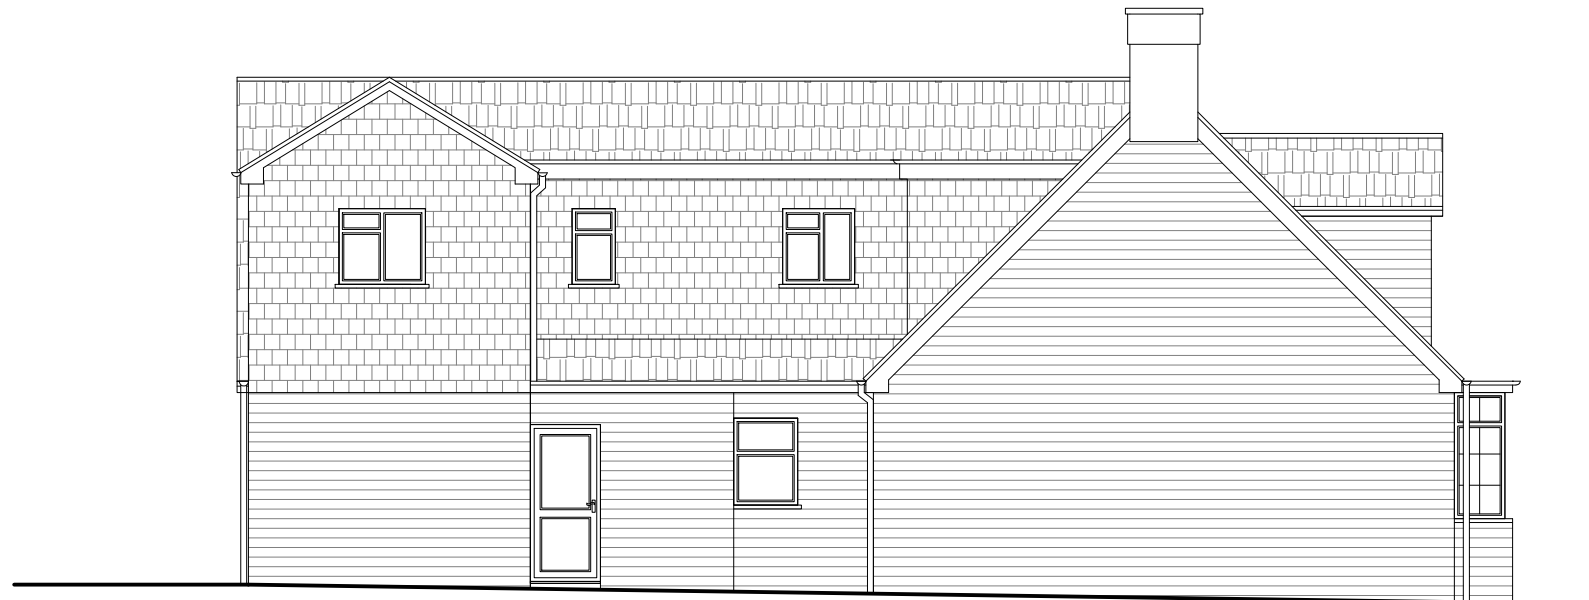

Side Elevation

 

**Revision notes:**

Rev:	Date:	Notes:
001		The Contractor must carry out His/Her own measured survey prior to works commencing on site to verify site dimensions and to report any discrepancies to the Designer. Contractor to refer to Building Control Notes. Contractor is responsible for final on site design using on site dimensions.  Contractor responsible for on site drainage layout/runs - to be agreed by Building Control prior to Construction starting on site. All Details to be approved by Building Control prior to construction starting on site.

**Drawn by:**

FD

**Client:**

**Project:**

155 London Road,  
Wickford, Essex,  
SS12 0EX

**Drawing Title:**

EXISTING ELEVATIONS

**Date:**

20.01.2021

**Scale @ A3:**

1:100

**Issue:**

BUILDING CONTROL

