



Notes


1. This drawing to be read in conjunction with the following:
Drawing No's :
2. Structural Engineers Details and Specification.
3. Mechanical & Electrical Details and Specification.
4. All fitout specifications and finishes to be to clients own specification.

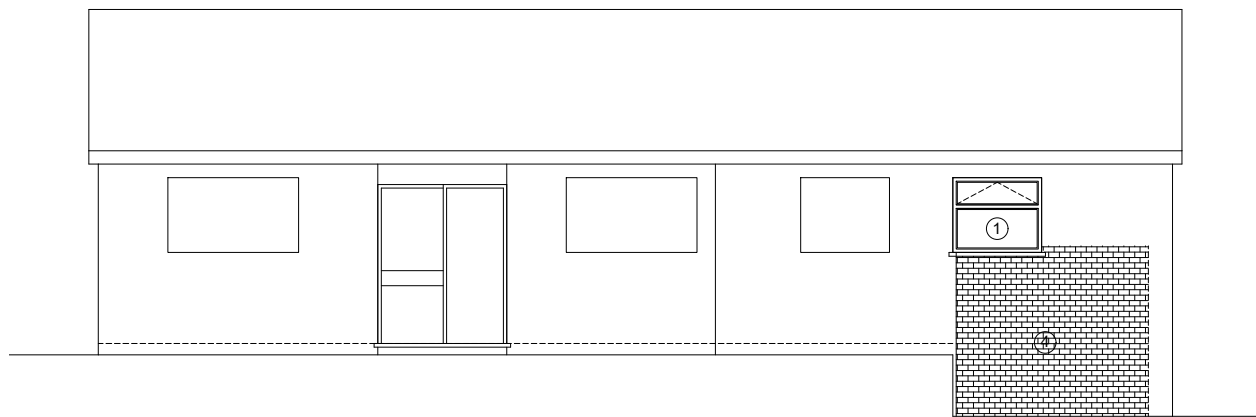


Proposed Front Elevation 1 - 1

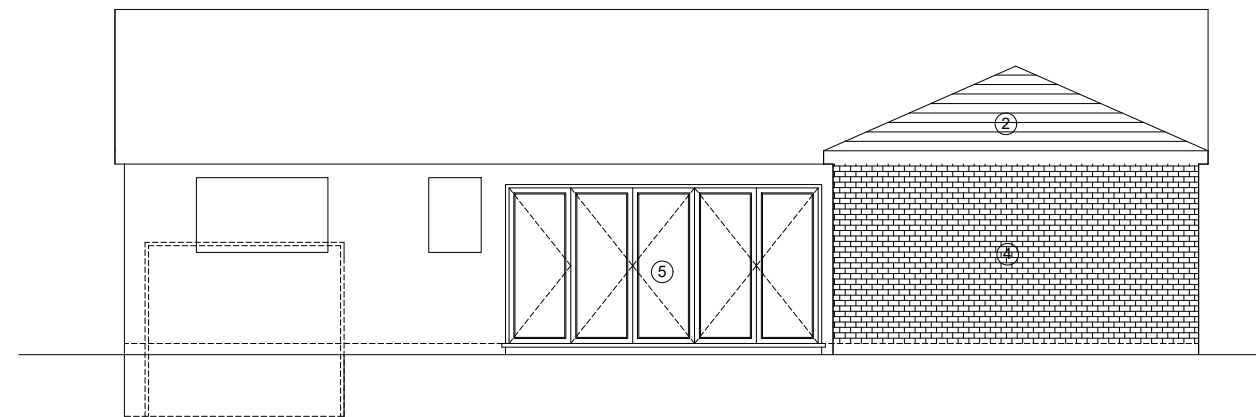

Proposed Rear Elevation 2 - 2

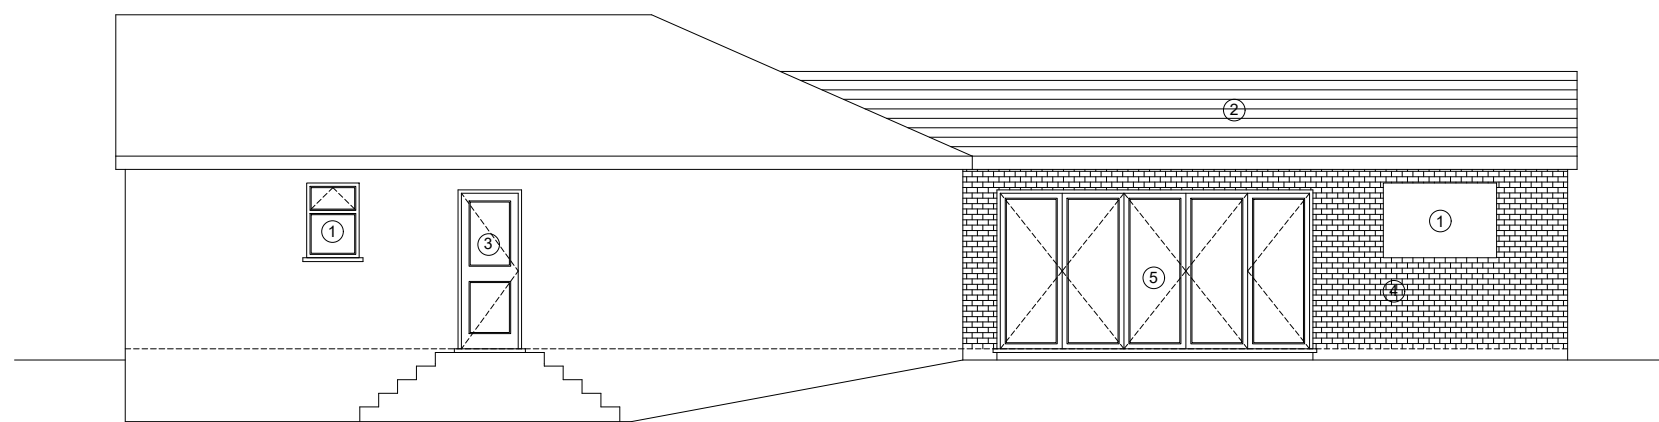

Proposed Side Elevation 3 - 3

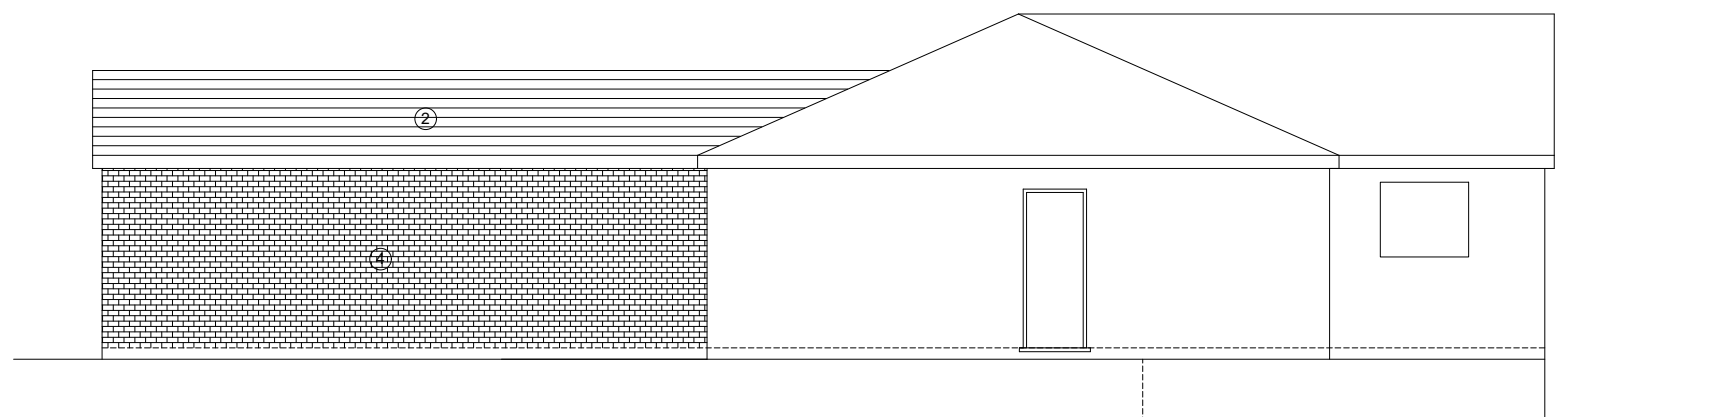


Proposed Side Elevation 4 - 4

Legend

- ① New windows to match existing to clients specification
- ② New roof tiles/slates to match existing.
- ③ New timber doors to match existing.
- ④ New brickwork to match existing.
- ⑤ New aluminum bi folds doors to clients specification.

Scale Bar

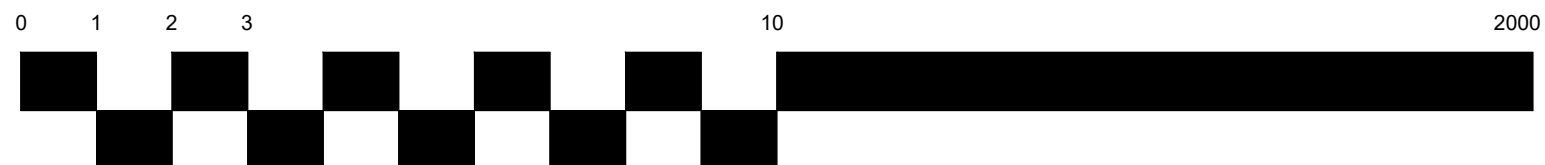

1 = 1 metre

A	Elevation 3 - 3 amended scale bar added.	15.01.2021
rev	details	date



client
Ryan Mahon

project
35a Beauty Bank
Cradley Heath
B64 7HZ

drawing title
Proposed Elevations
PLANNING

date	15.12.2019	scale	1 : 100 @ A3
project no.	2019 - 114	drawing no.	114 - 003
		revision	A

This drawing is copy right of loveridge design limited.
All dimensions to be checked on site.
Do not scale from this drawing.