


- KEY:**
- ▼ DOUBLE SWITCH SOCKET (LOW LEVEL)
  - ▼ DOUBLE SWITCH SOCKET (HIGH LEVEL)
  - ▼ SINGLE SWITCH SOCKET (LOW LEVEL)
  - ▼ SINGLE SWITCH SOCKET (HIGH LEVEL)
  - ONE WAY LIGHT SWITCH
  - TWO WAY LIGHT SWITCH
  - SPUR OUTLET WITH REMOTE SWITCH
  - SHAVER SOCKET 110 VOLTS
  - TV AERIAL OUTLET
  - TELEPHONE POINT
  - PENDANT/ FEATURE LIGHT FITTING
  - DOWNLIGHTER
  - UPLIGHTER
  - FLUORESCENT LIGHT FITTING
  - EXTERNAL SENSOR SECURITY LIGHT
  - SMOKE ALARM
  - CARBON MONOXIDE DETECTOR
  - HEAT DETECTOR
  - SHOWER
  - SHOWER PULL SWITCH
  - DOOR BELL/ SOUNDER
  - DISTRIBUTION BOARD/ ELEC METER
  - GAS METER
  - CH CENTRAL HEATING CONTROL
  - RADIATOR
  - MECHANICAL EXTRACT FAN
  - BOILER FLUE
  - BOILER
  - ALARM CONTROL PANEL
  - MJ MOVEMENT JOINT
  - EEW EMERGENCY ESCAPE WINDOW

EXISTING FIRST FLOOR PLAN 1:50



EXISTING GROUND FLOOR PLAN 1:50

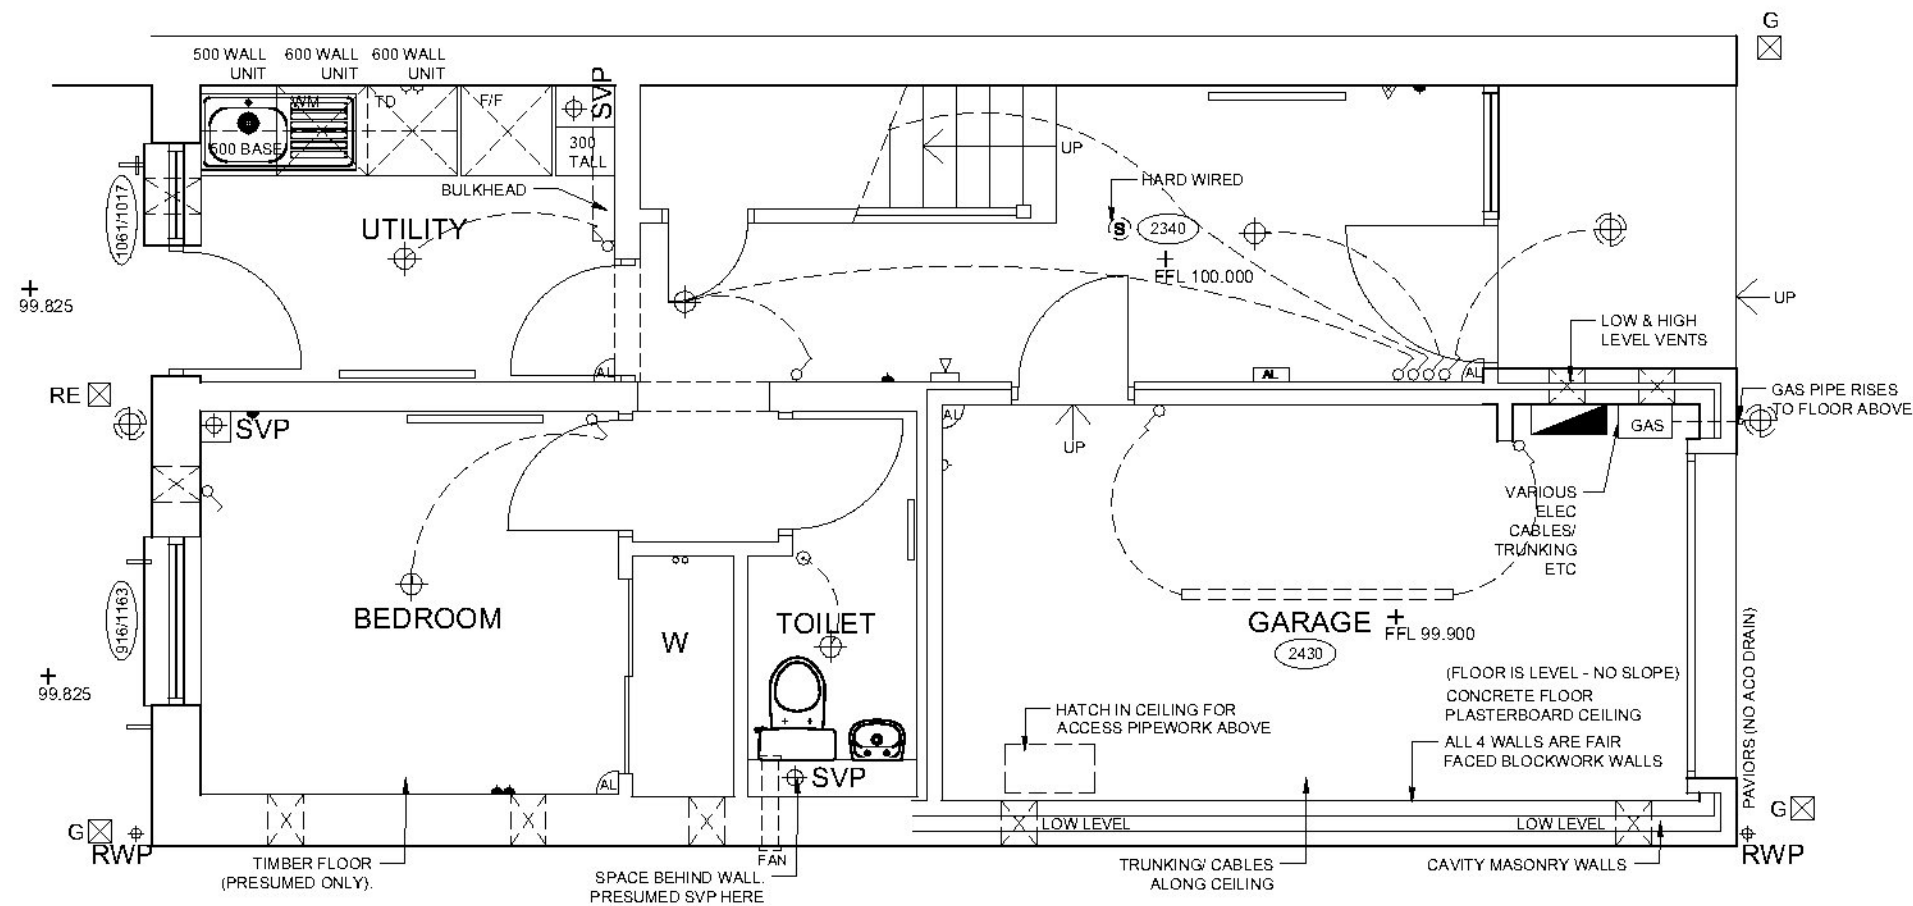

**A:B Studio**  
Chartered Architects Ltd  
www.ab-architects.co.uk  
32 Langside Place, Glasgow, G41 3DL

CLIENT: BARRY COYNE & WILLIAM TURNER  
PROJECT: 70 MANSIONHOUSE GARDENS  
DRAWING TITLE: EXISTING GROUND & FIRST FLOOR PLANS  
DRAWING STATUS: PLANNING/ WARRANT  
DATE: 13-12-17 DRAWING NO: 16018/02 SCALE: 1:50 @ A3