





NOTES:

1. Do not scale from this drawing.
2. All dimensions are in millimeters unless noted otherwise.
3. This drawing is to be read in conjunction with all relevant Architect's and Engineer's drawings.

Legend

-  Existing levels
-  Proposed levels

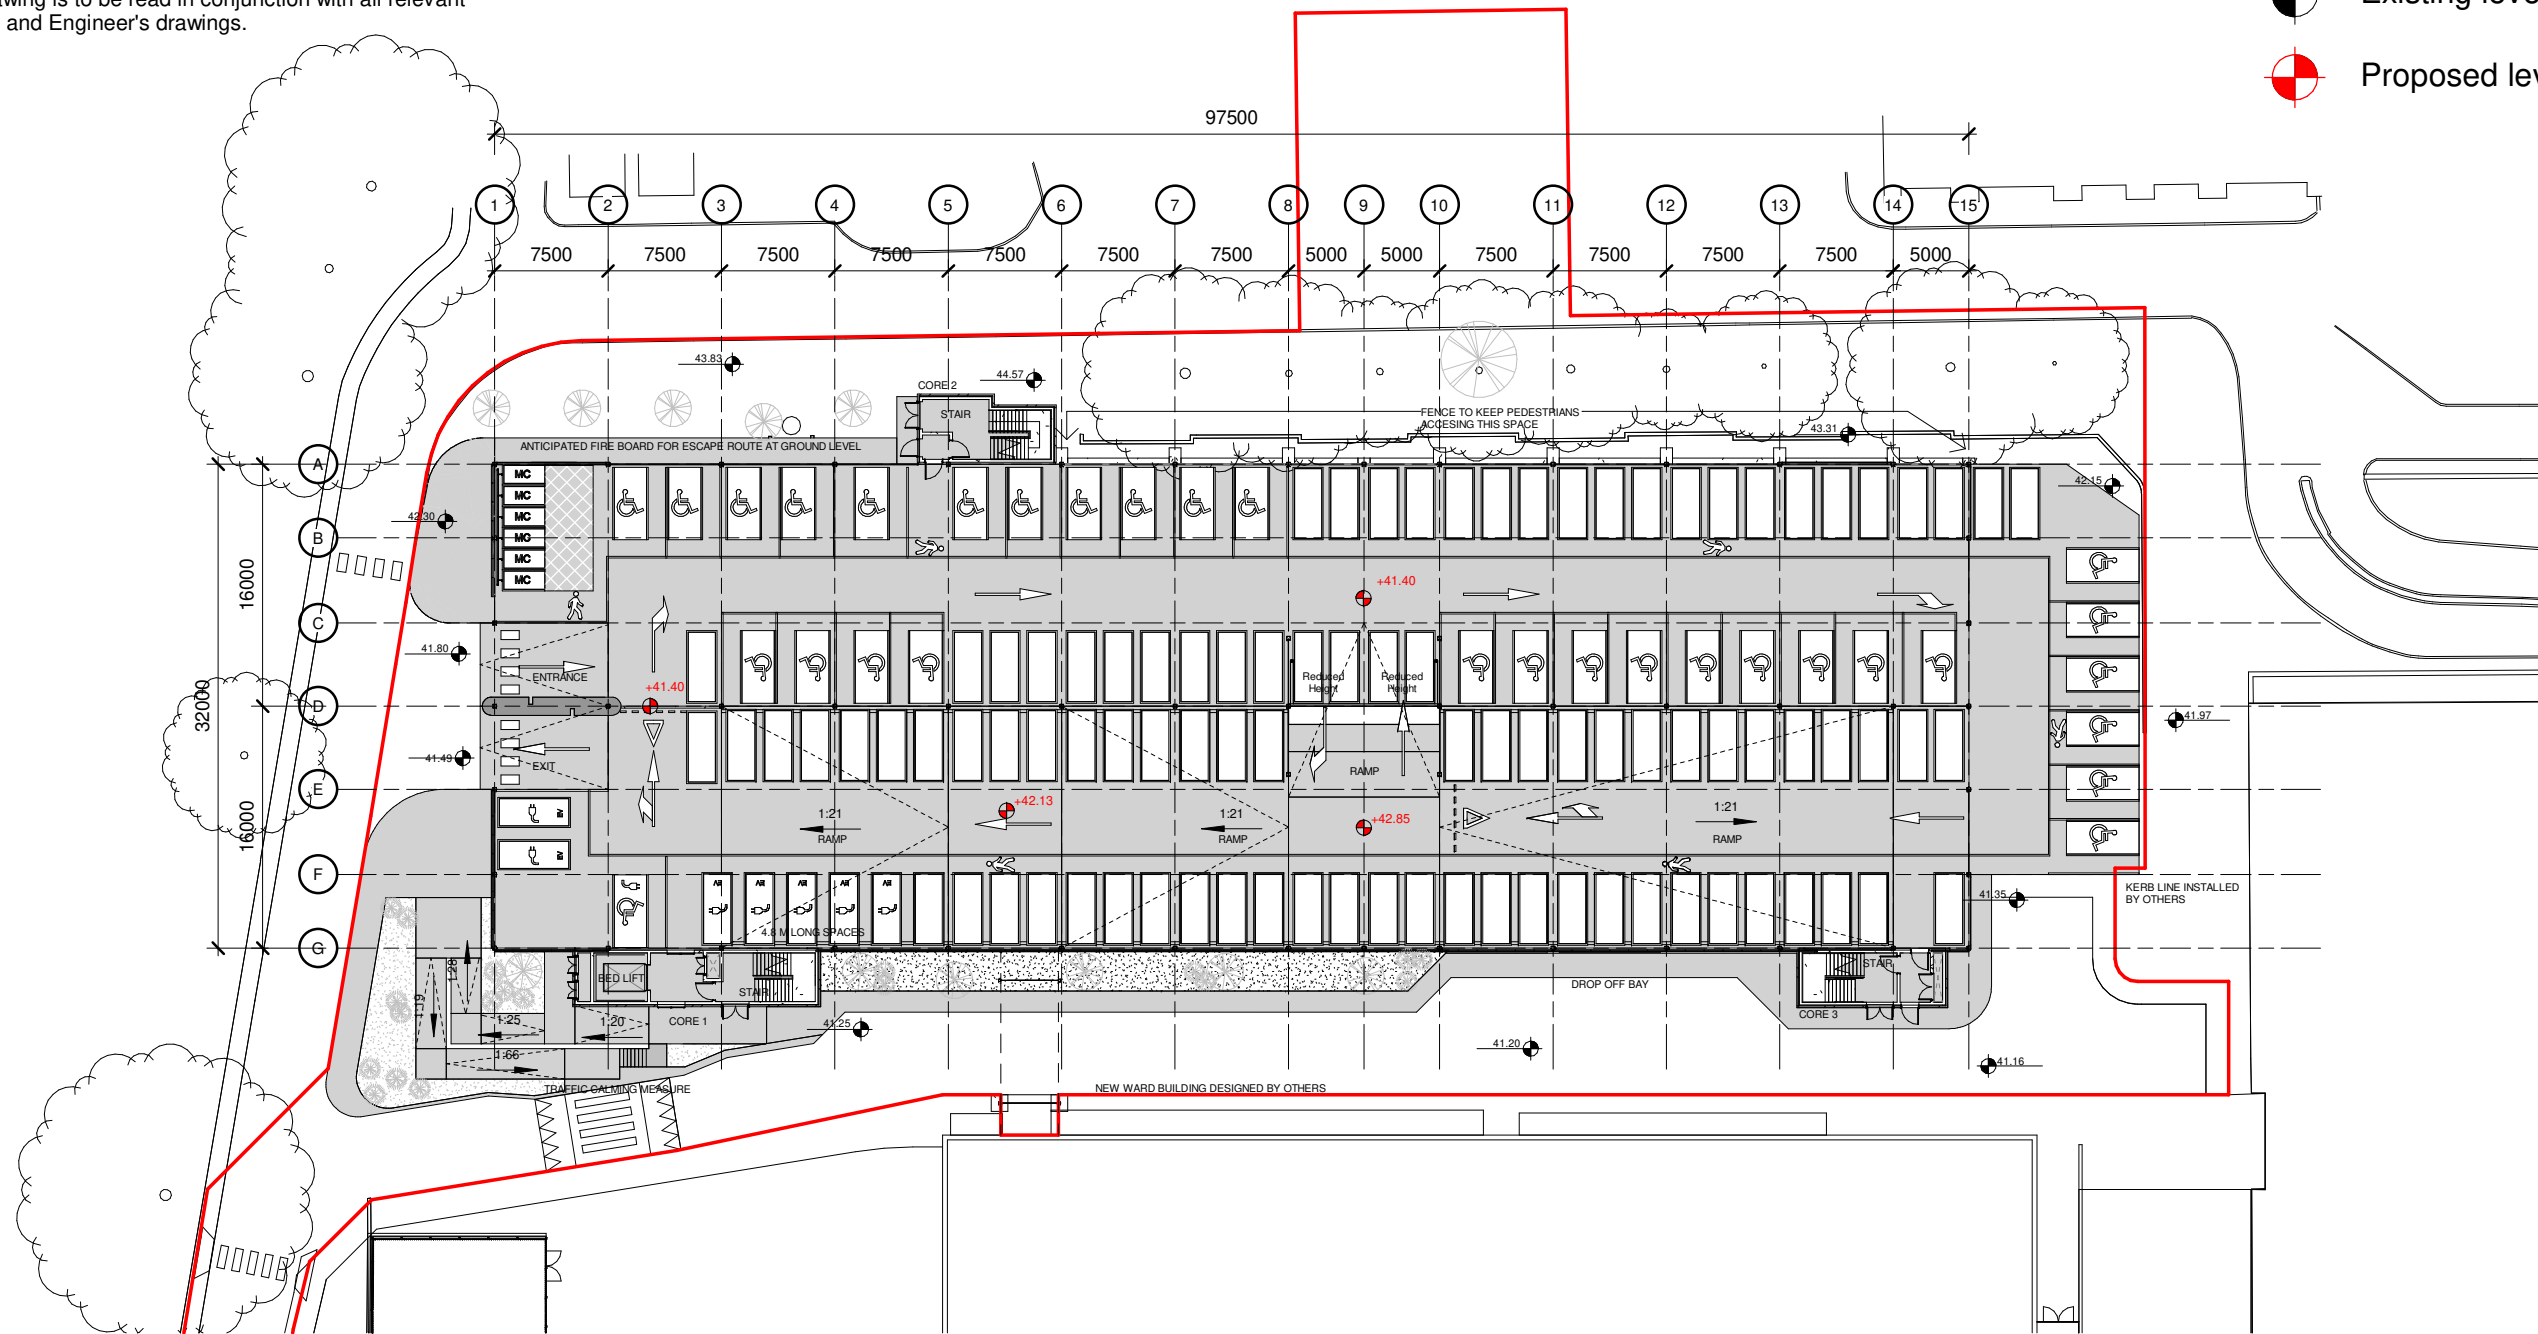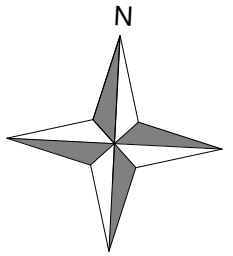


00 GA - Proposed site plan

1 : 500



PARKING BAY SCHEDULE						
Level	Standard	Disabled	Disabled EV	EV	Motorcycle	TOTAL
Ground Floor	91	30	1	7	6	129
LEVEL 01	135	-	-	-	-	135
LEVEL 02	137	-	-	-	-	137
LEVEL 03	140	-	-	-	-	140
TOTAL	503	30	1	7	6	541

Project: QA HOSPITAL MSCP PORTSMOUTH	Draftsman MY	Control VV	Authorisation CPB
Reference: Proposed Site Plan/ Level 0 Plan	Phase: Preliminary		
	Client: Noviniti		Scale: 1:500 @ A3
Ballast Nedam Parking 3rd Floor 70 Gracechurch Street London EC3V 0HR United Kingdom			Date: 12/02/2021 Version P04
Tel: +31 (0)30 285 30 30 E-mail: office@bnparking.co.uk	Project Number: 0039 Drawing Number: J1708-STRIPE-XX-00-DR-AX-90002		ext. rev: int. rev:
© Ballast Nedam Parking			