
 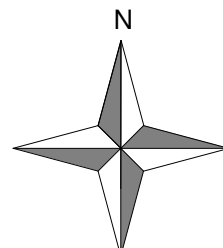



- NOTES:
1. Do not scale from this drawing.
  2. All dimensions are in millimeters unless noted otherwise.
  3. This drawing is to be read in conjunction with all relevant Architect's and Engineer's drawings.

1 Existing site plan  
1 : 500



Project: <b>QA HOSPITAL MSCP PORTSMOUTH</b>	Draftsman MY	Control VV	Authorisation CPB
Reference: <b>Existing site plan</b>	Phase: Preliminary		
	Client: Noviniti		Scale: 1:3000 @ A3
Ballast Nedam Parking 3 <sup>rd</sup> Floor 70 Gracechurch Street London EC3V 0HR United Kingdom			Date: 12/02/2021      Version P02
	Project Number: 0039		
	Drawing Number: J1708-STRIPE-XX-00-DR-AX-91001		
	© Ballast Nedam Parking		ext. rev:    int. rev:

Tel: +31 (0)30 285 30 30  
E-mail: office@bnparking.co.uk