

SIDE ELEVATION



FRONT ELEVATION





SIDE ELEVATION




REAR ELEVATION



PROPOSED ELEVATIONS

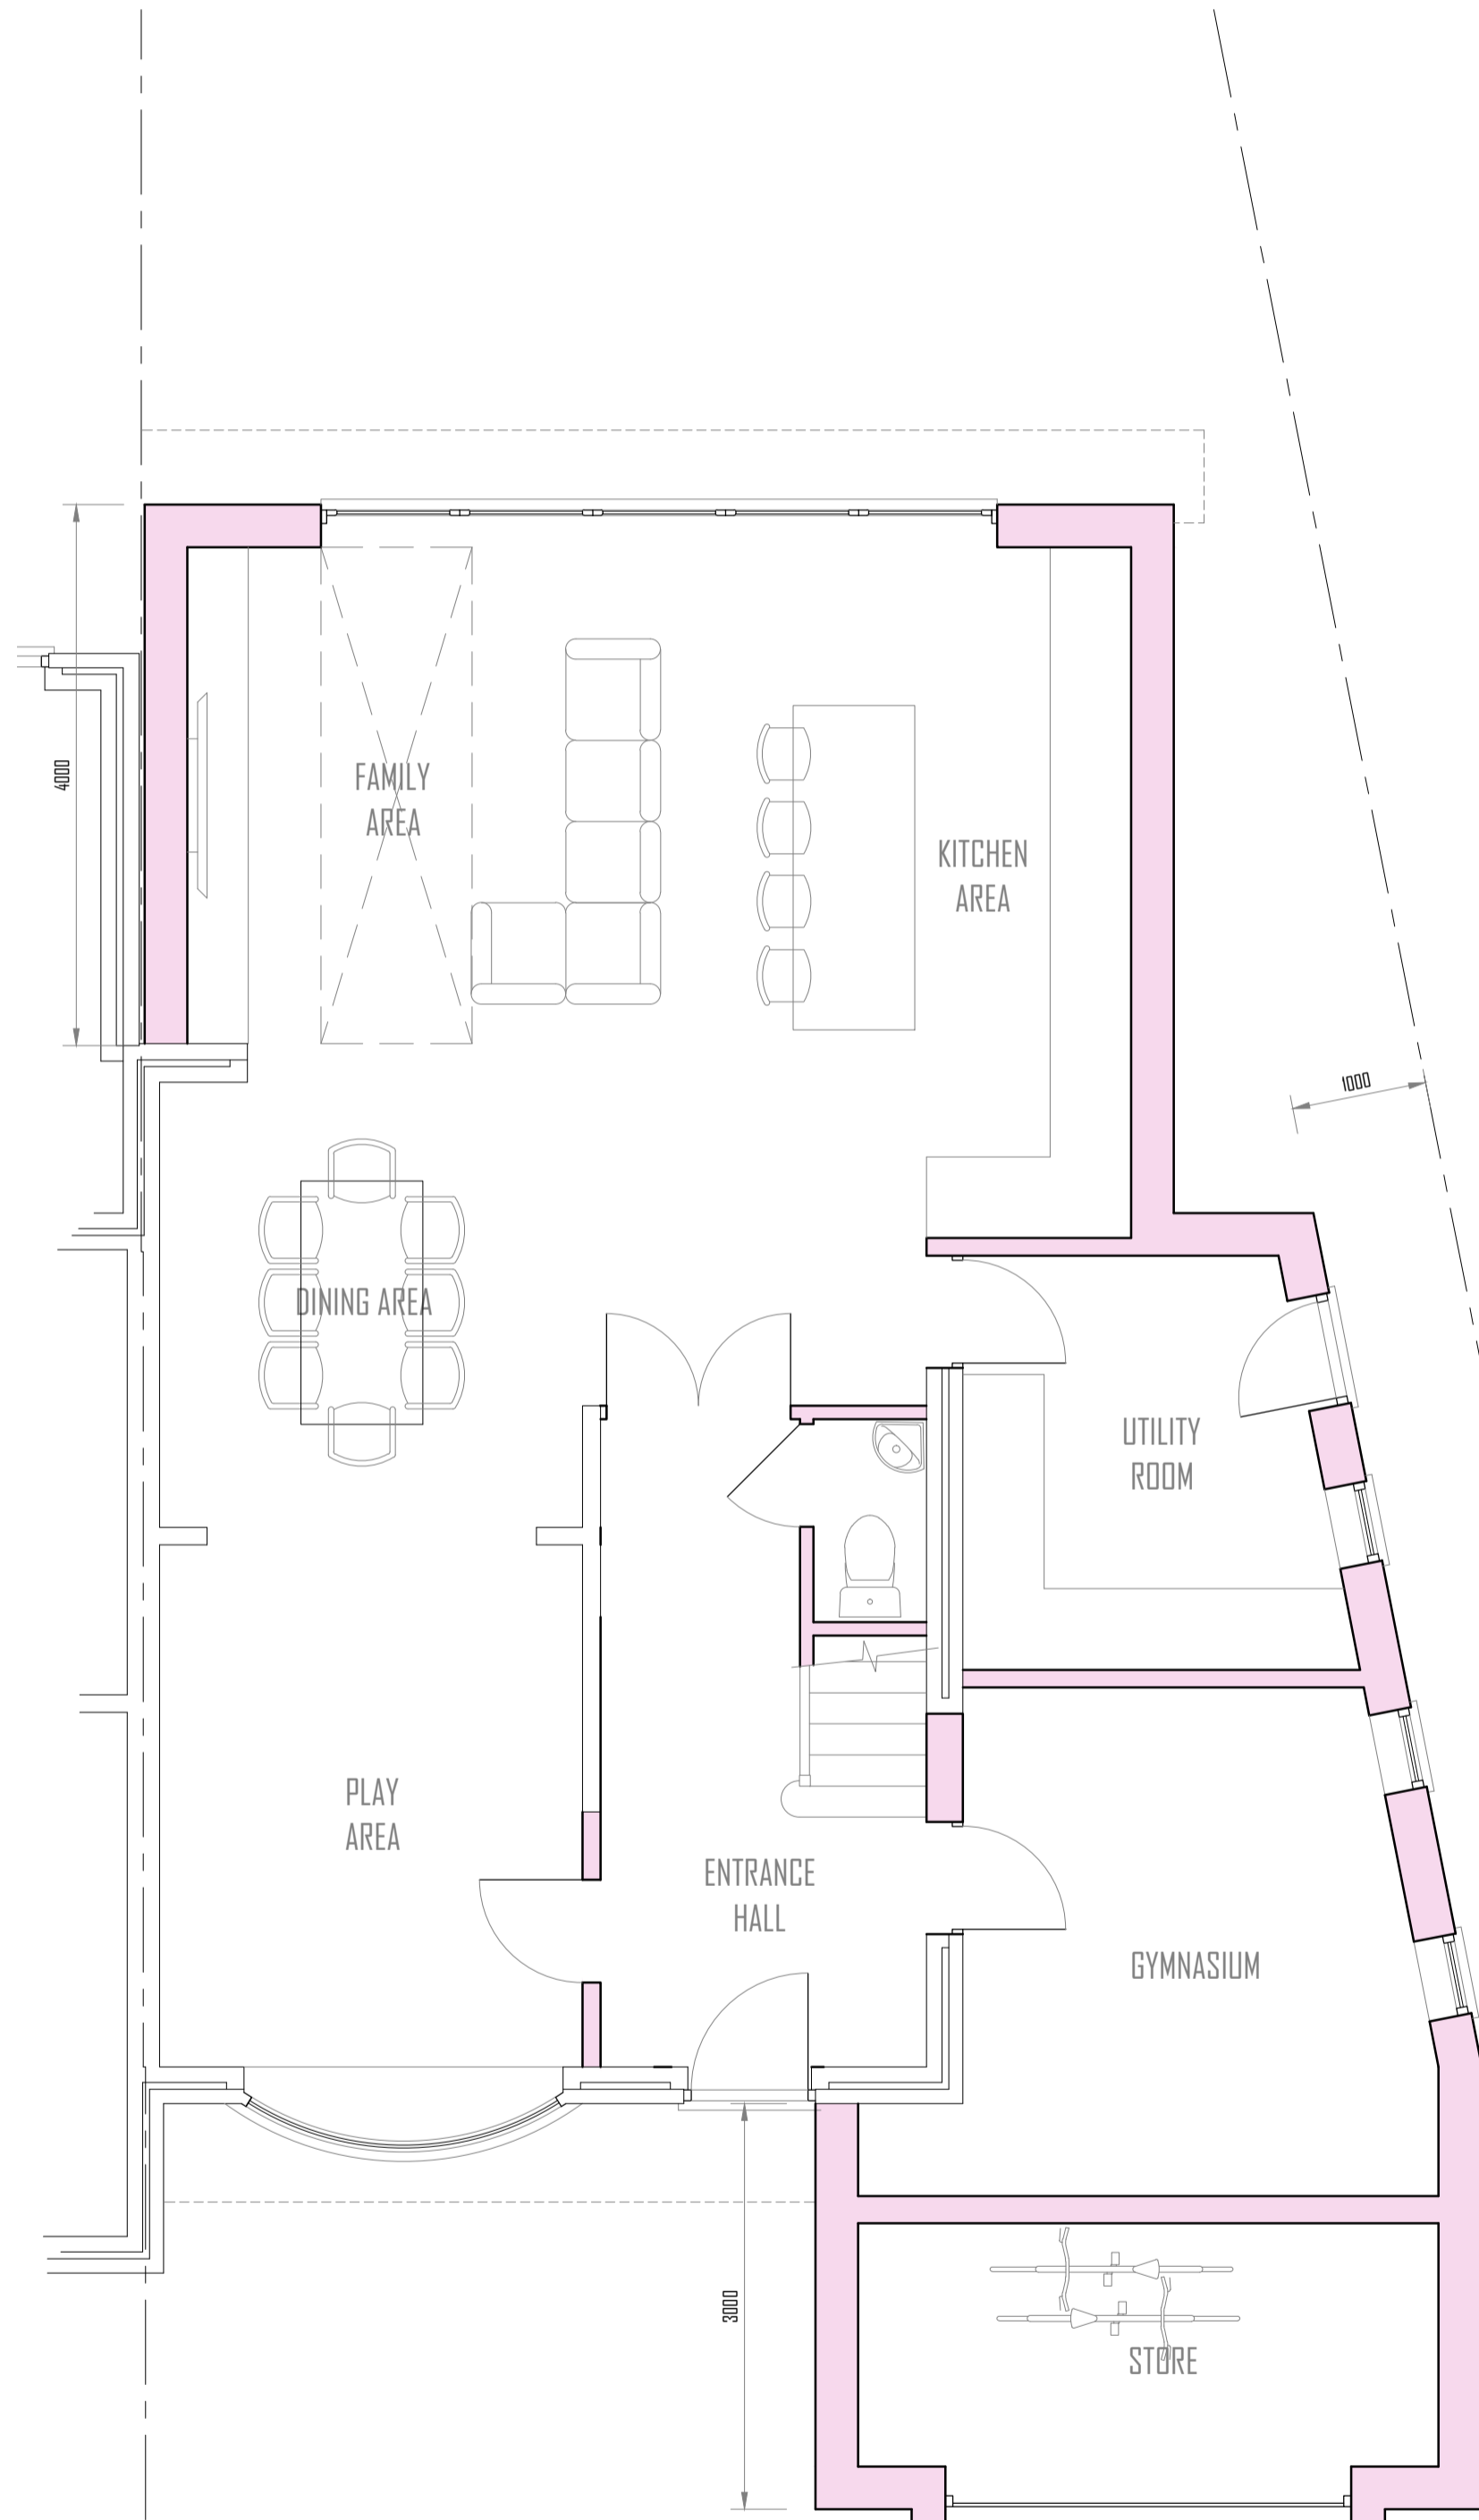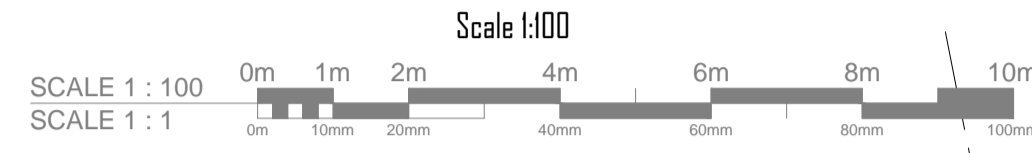

PROPOSED GROUND FLOOR PLAN Scale 1:50

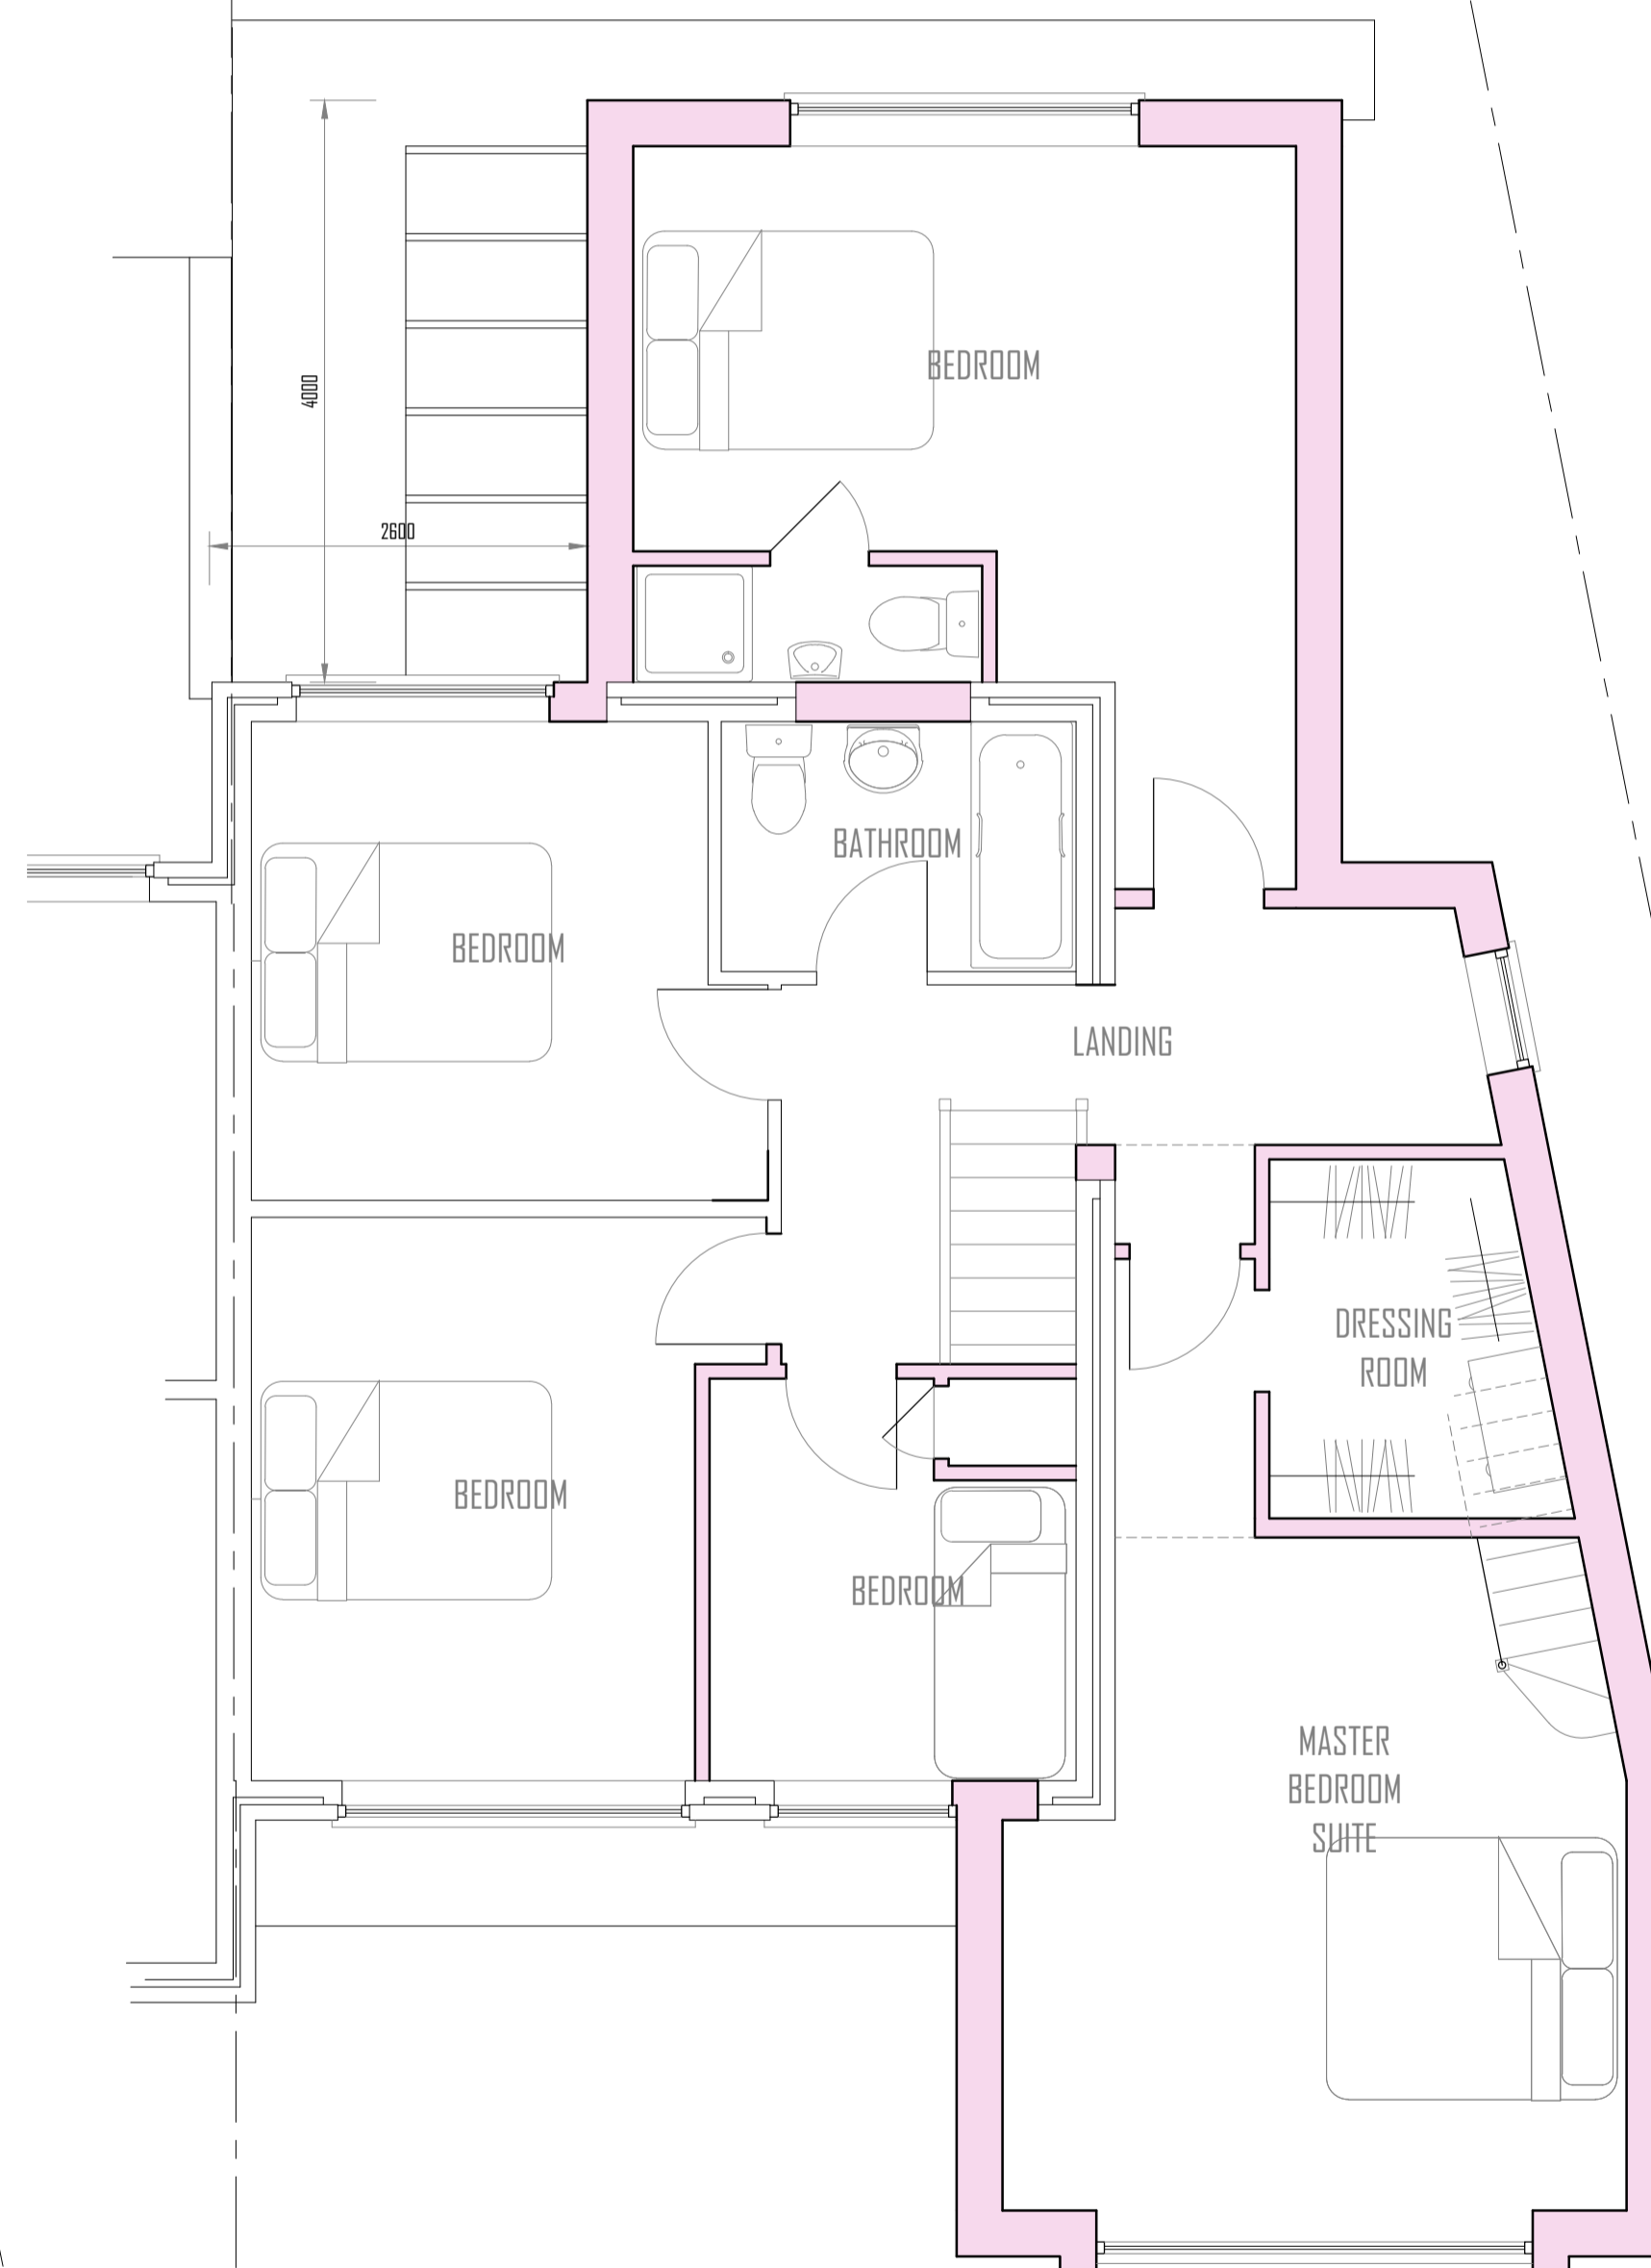

PROPOSED FIRST FLOOR PLAN Scale 1:50

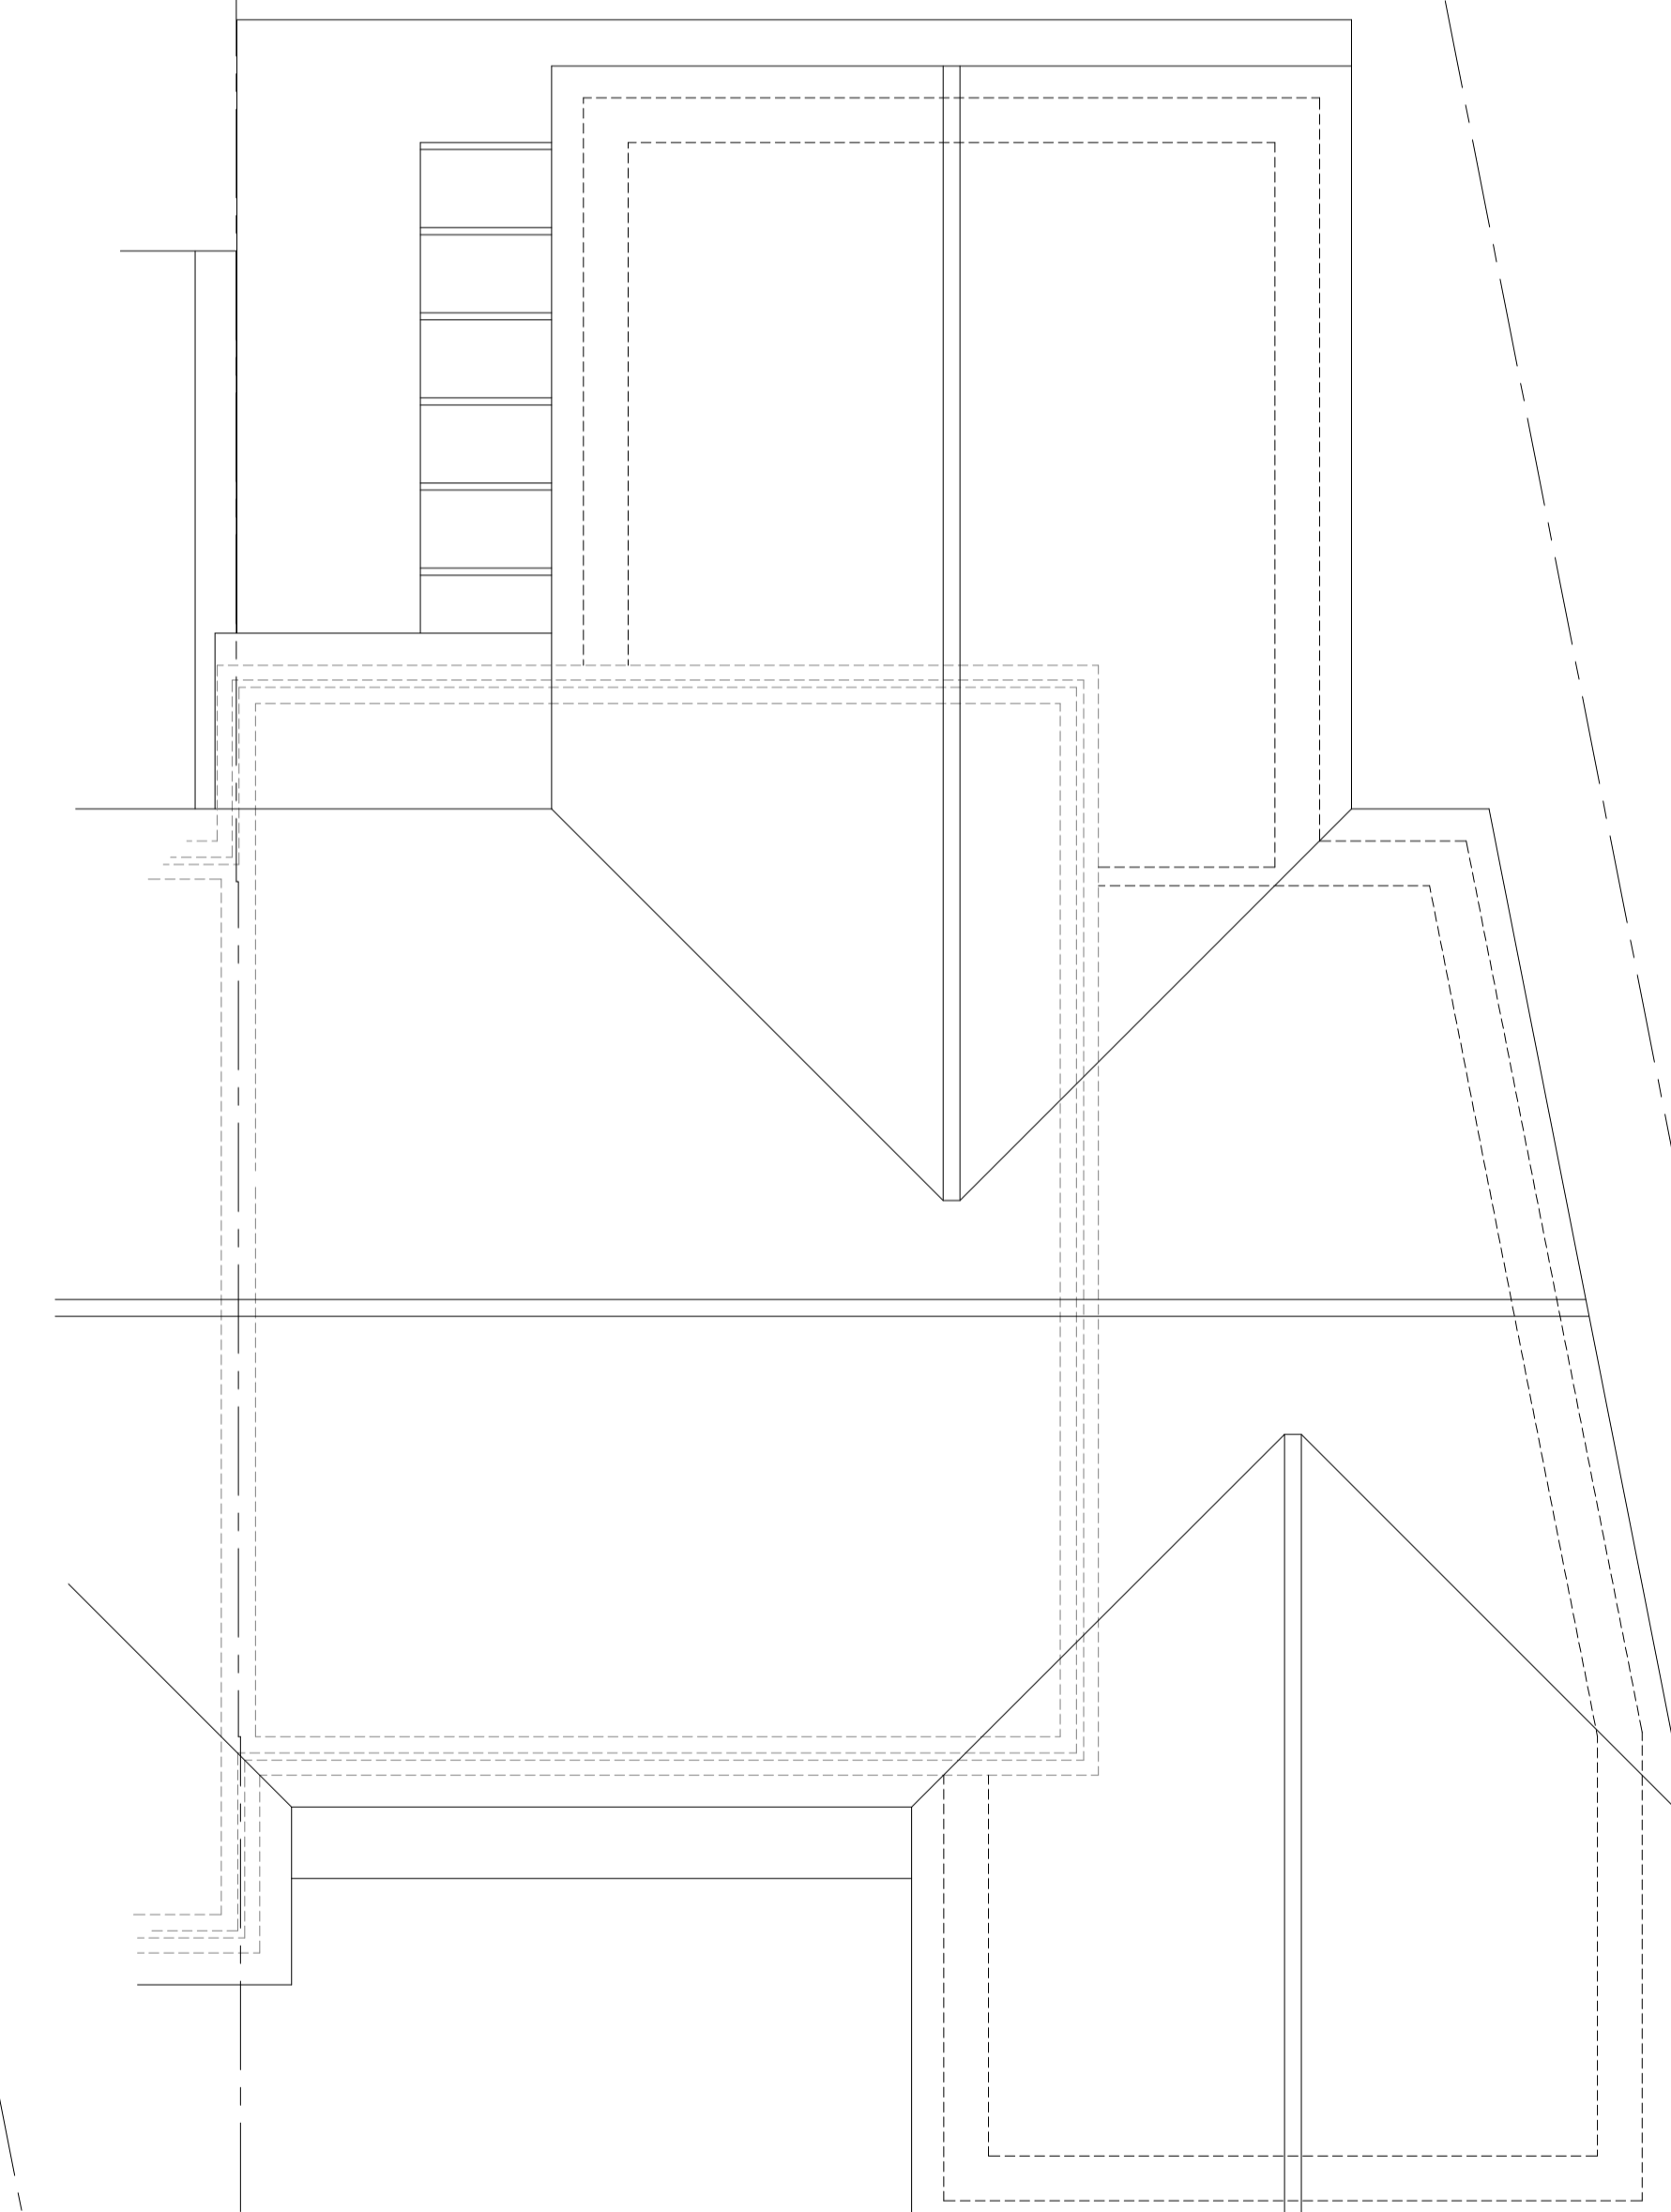 

PROPOSED ROOF PLAN Scale 1:50

This drawing is not yet approved and is therefore subject to variation

PROPOSED FLOOR & ROOF PLANS

for presentation under the Town Planning Act 1996

Proposed Alterations & Additions

67 Hartswood Road

Warley Brentwood CM14 5AG


March 2021

Scales as shown @ A1



MARK HIPSEY
92 London Road
Southend on Sea
Essex SSI 1PG
Office: 07702 300 101
Mobile: 07850 933 845
E-mail: mark@markhipsey.co.uk
Website: markhipsey.co.uk

3005 12

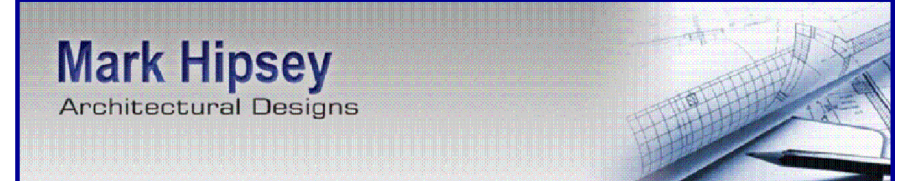

67 Hartswood Road