


SIDE ELEVATION





FRONT ELEVATION

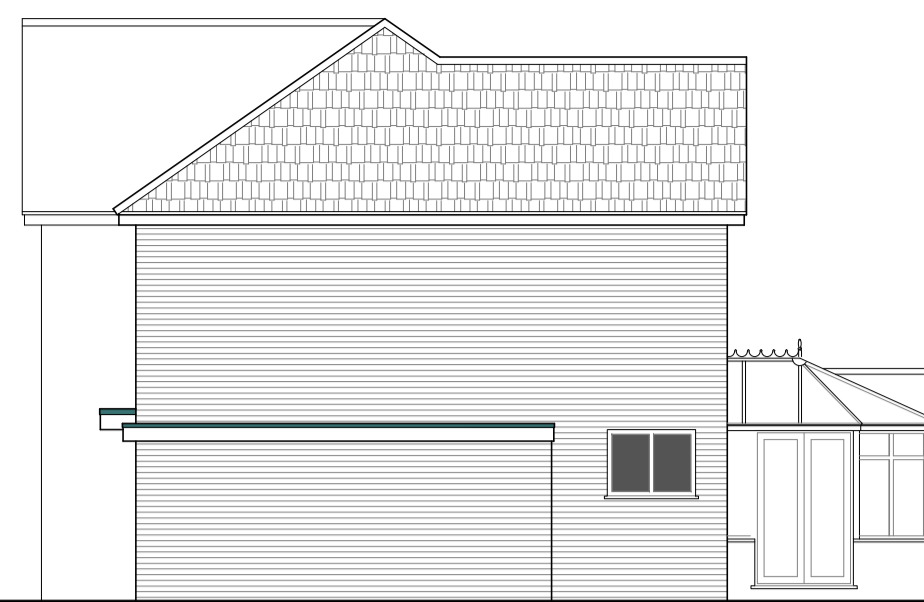


SIDE ELEVATION





REAR ELEVATION

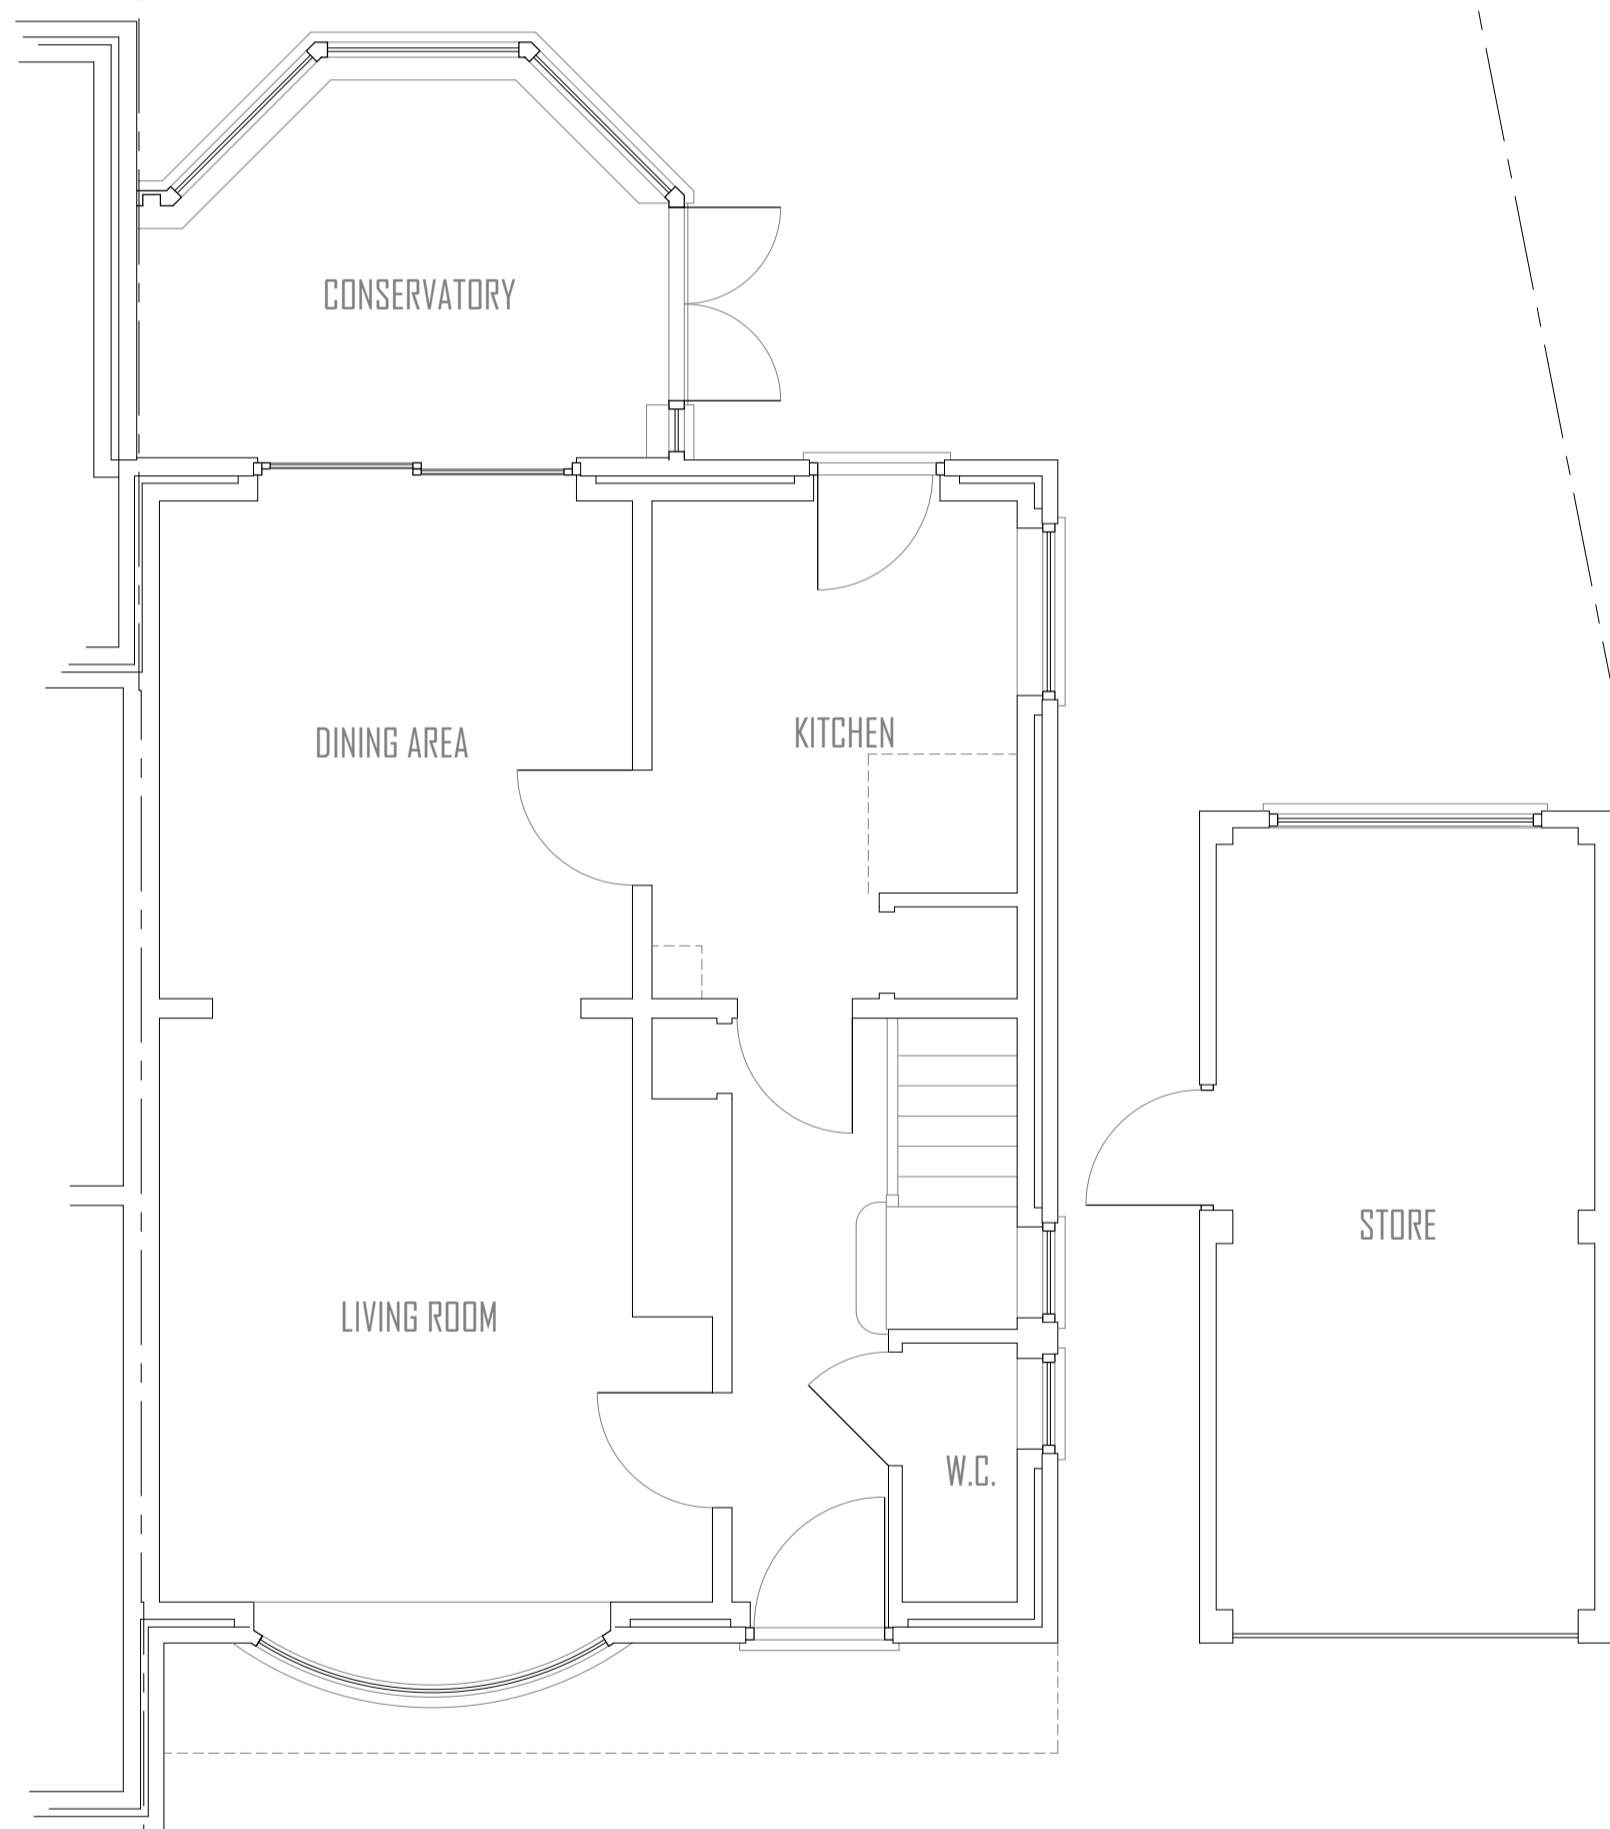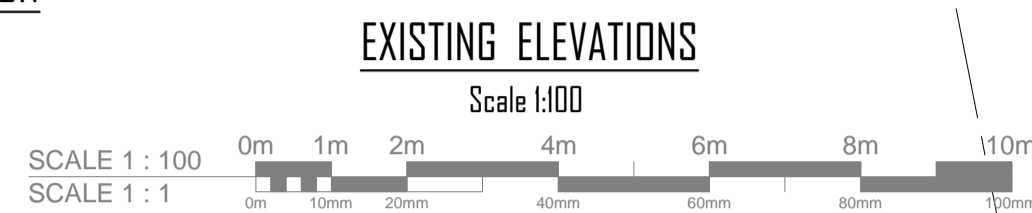

EXISTING GROUND FLOOR PLAN Scale 1:50

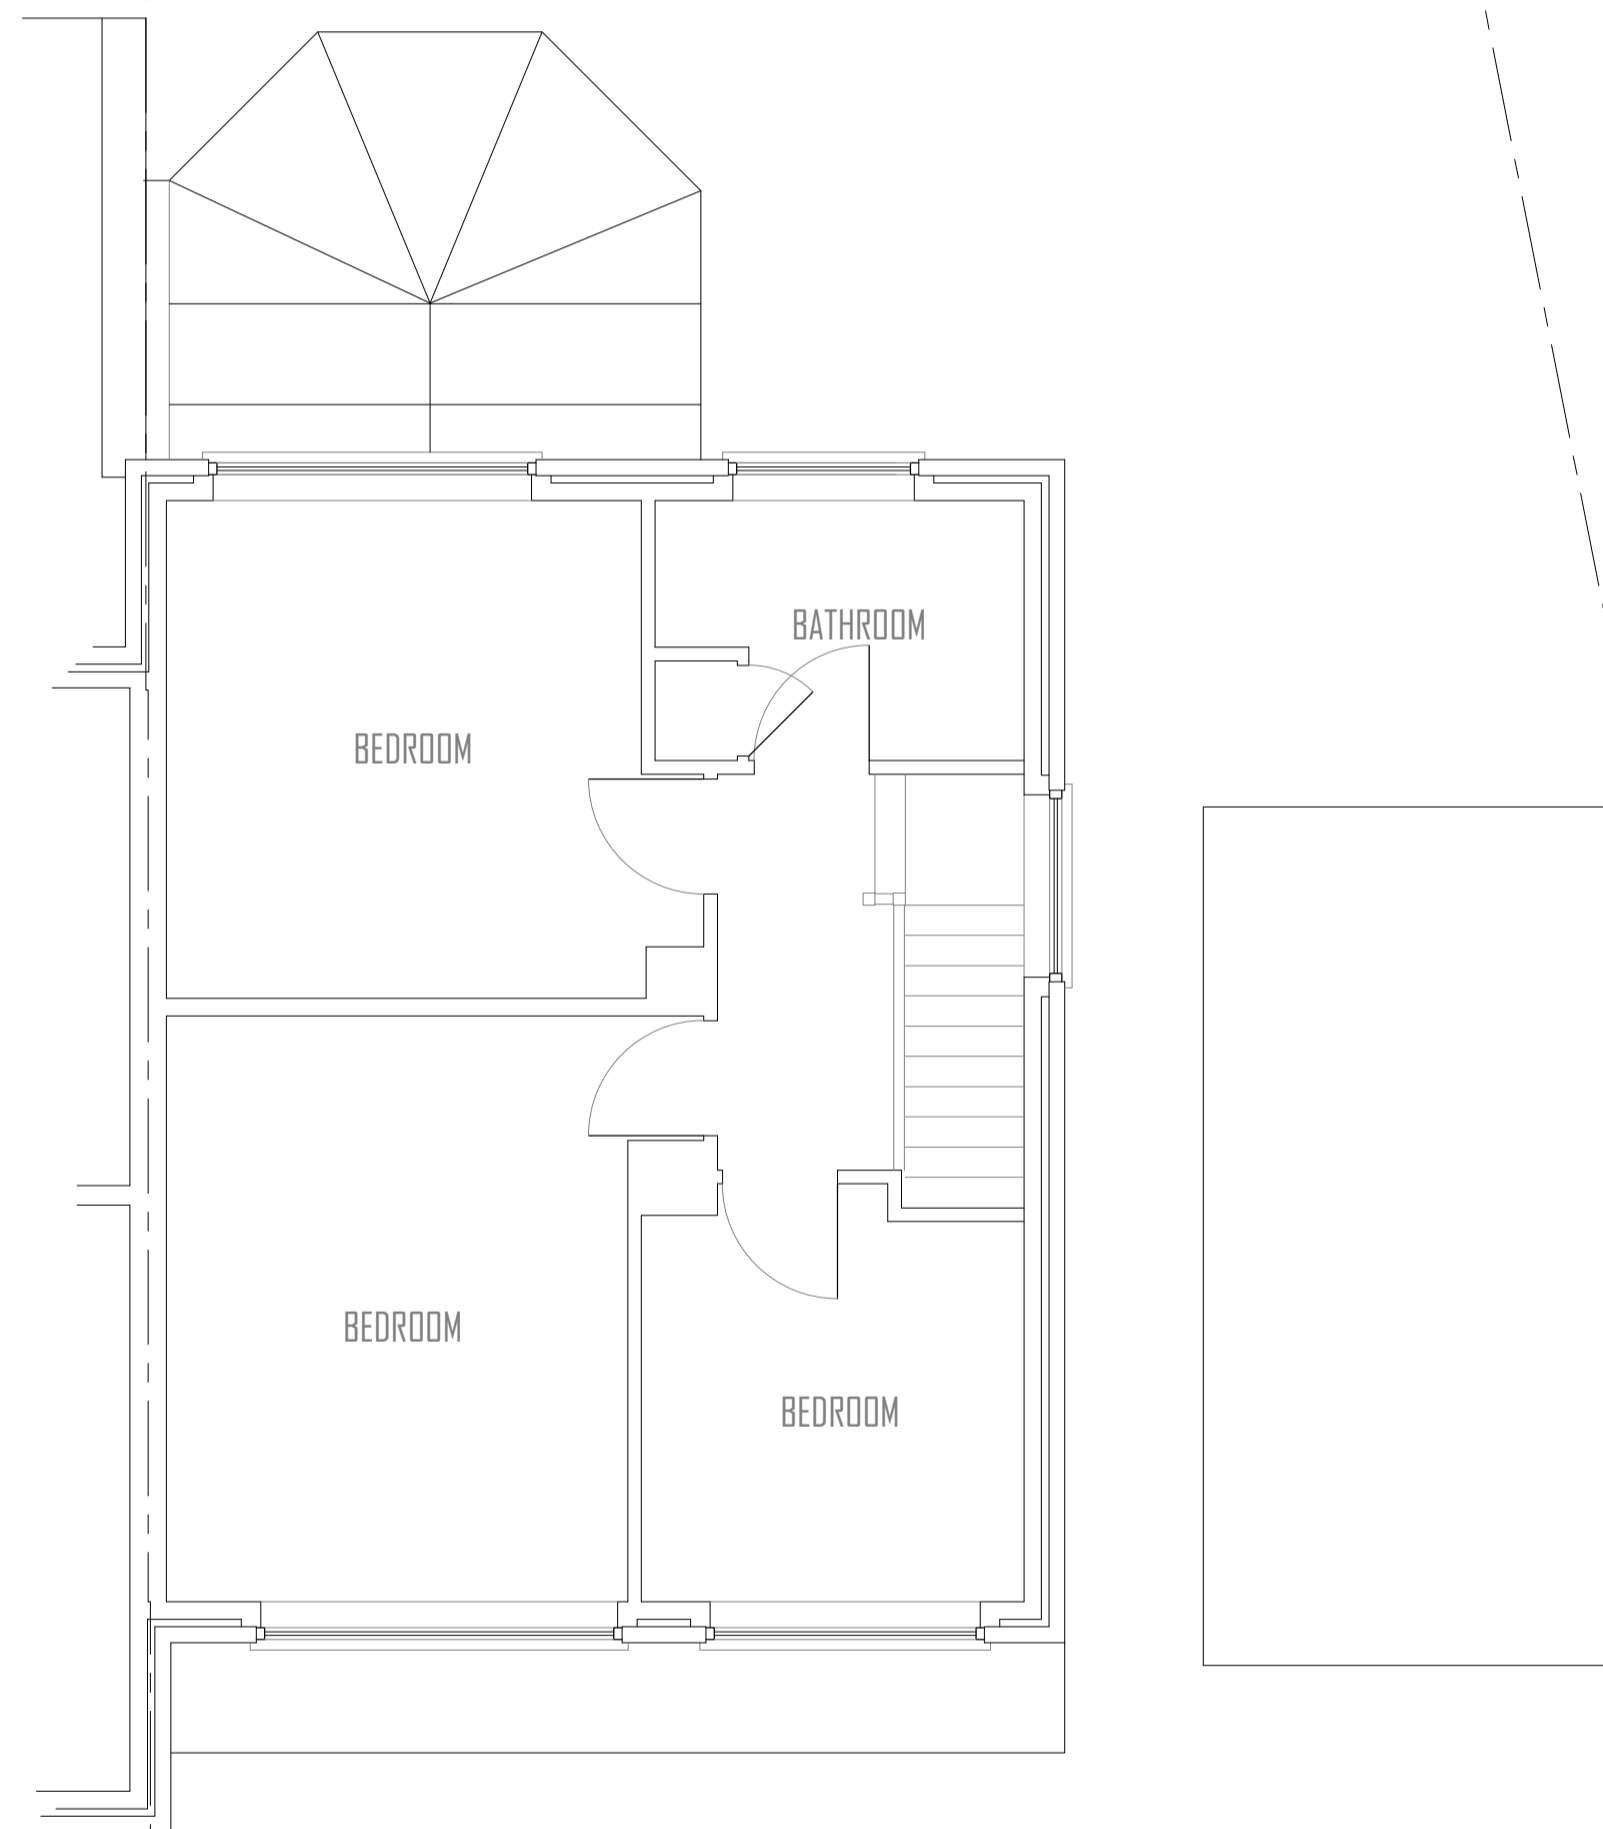

EXISTING FIRST FLOOR PLAN Scale 1:50

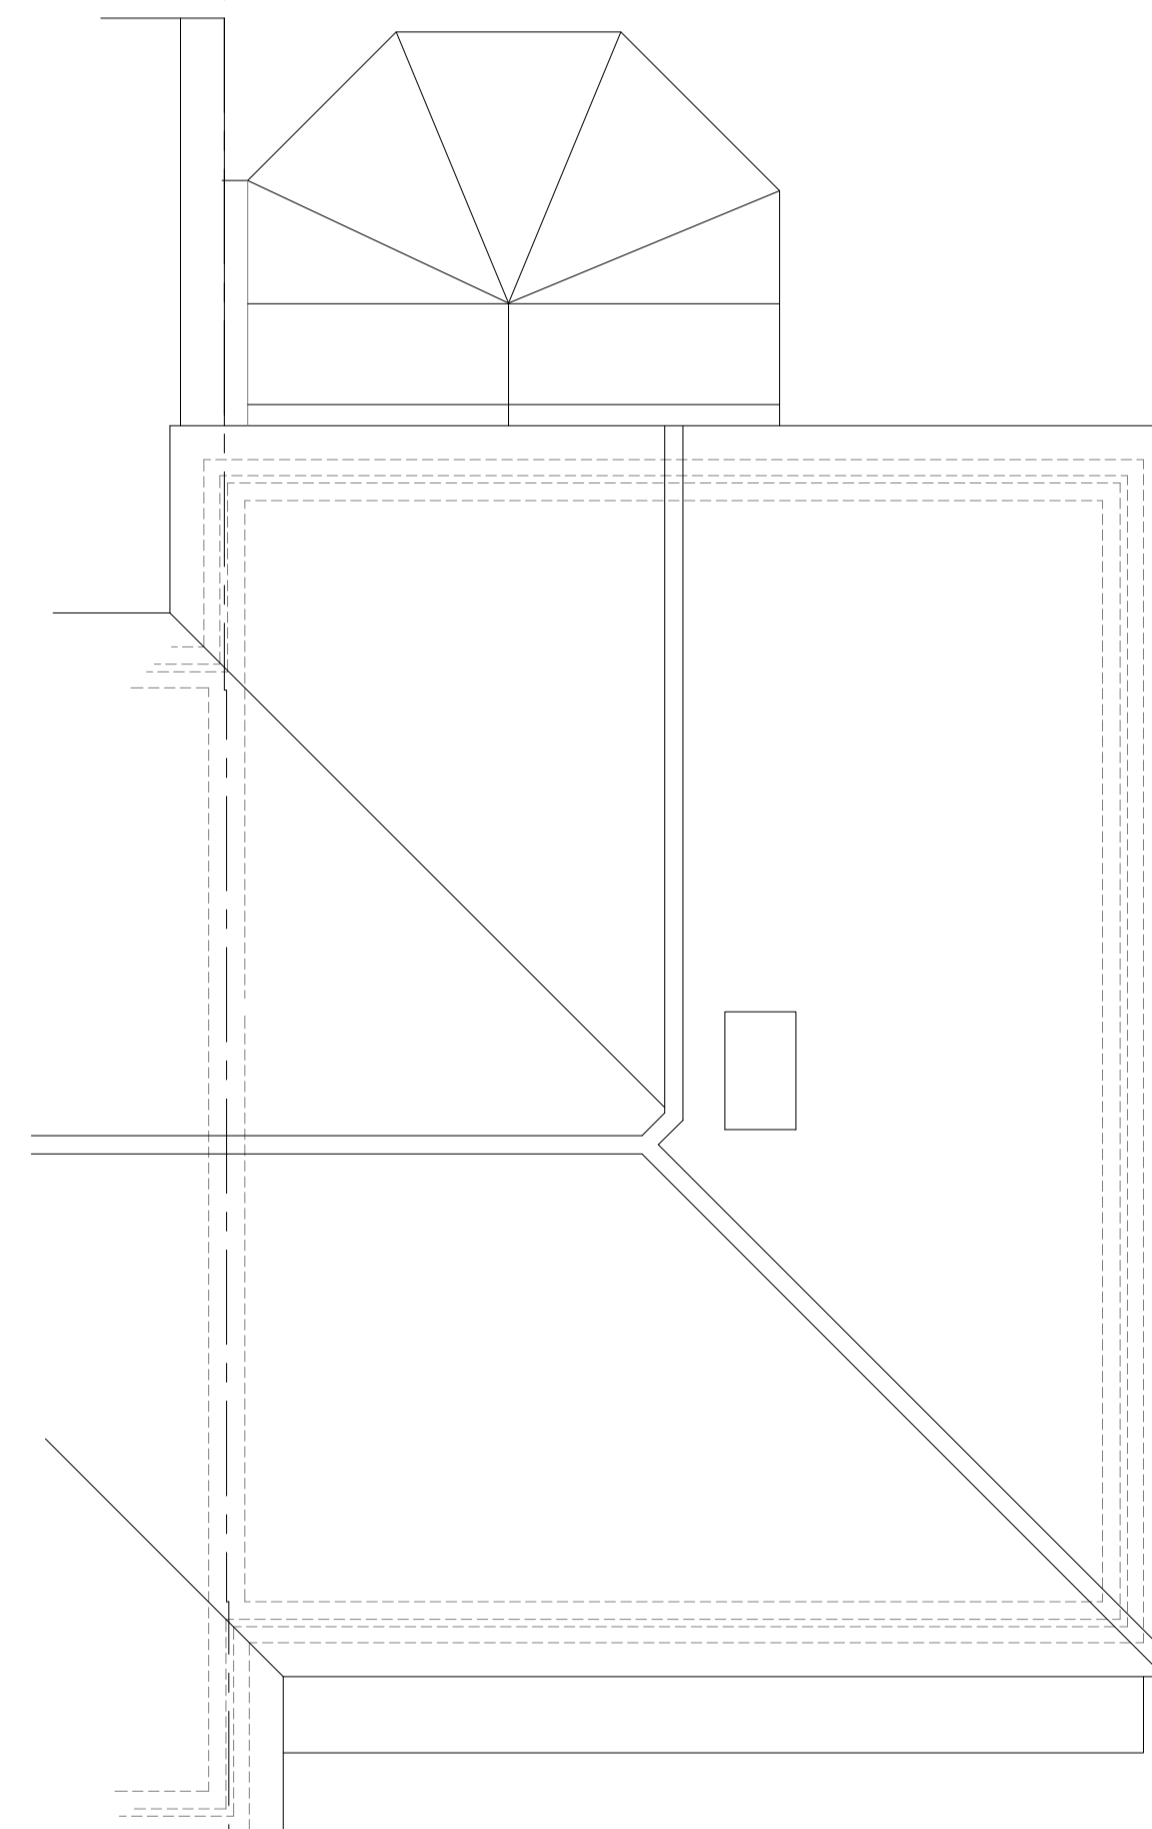 

EXISTING ROOF PLAN Scale 1:50

This drawing is not yet approved and is therefore subject to variation

EXISTING FLOOR & ROOF PLANS

for presentation under the Town Planning Act 1995
Proposed Alterations & Additions

67 Hartswood Road
Warley Brentwood CM14 5AG

This scheme would appear to fall under the Party Wall Act 1996. Notice must be served as required by the Act when all necessary data is to hand. All dimensions must be checked prior to commencement & fabrication. All lines of conduit are assumed and are to be checked prior to commencement. Foundation design is based on assumed soil conditions and subject to assessment upon excavation. This drawing is to be read in conjunction with specialists' drawings. This drawing serves only the purpose for which it is produced



MARK HIPSEY
92 London Road
Southend on Sea
Essex SSI 1PG
Office: 0782 900 101
Mobile: 07850 933 845
E-mail: mark@markhipsey.co.uk
Website: markhipsey.co.uk

3005 11

March 2021
Scales as shown @ A1

Mark Hipsey
Architectural Designs

67 Hartswood Road