


Proposed Ground Source Heat Pump Location Plan

Proposed Stiebel Eltron WPF 13 S ground source heat pump location indicated by red 'x'.
 Dimensions: 598mm x 695mm x 1369mm

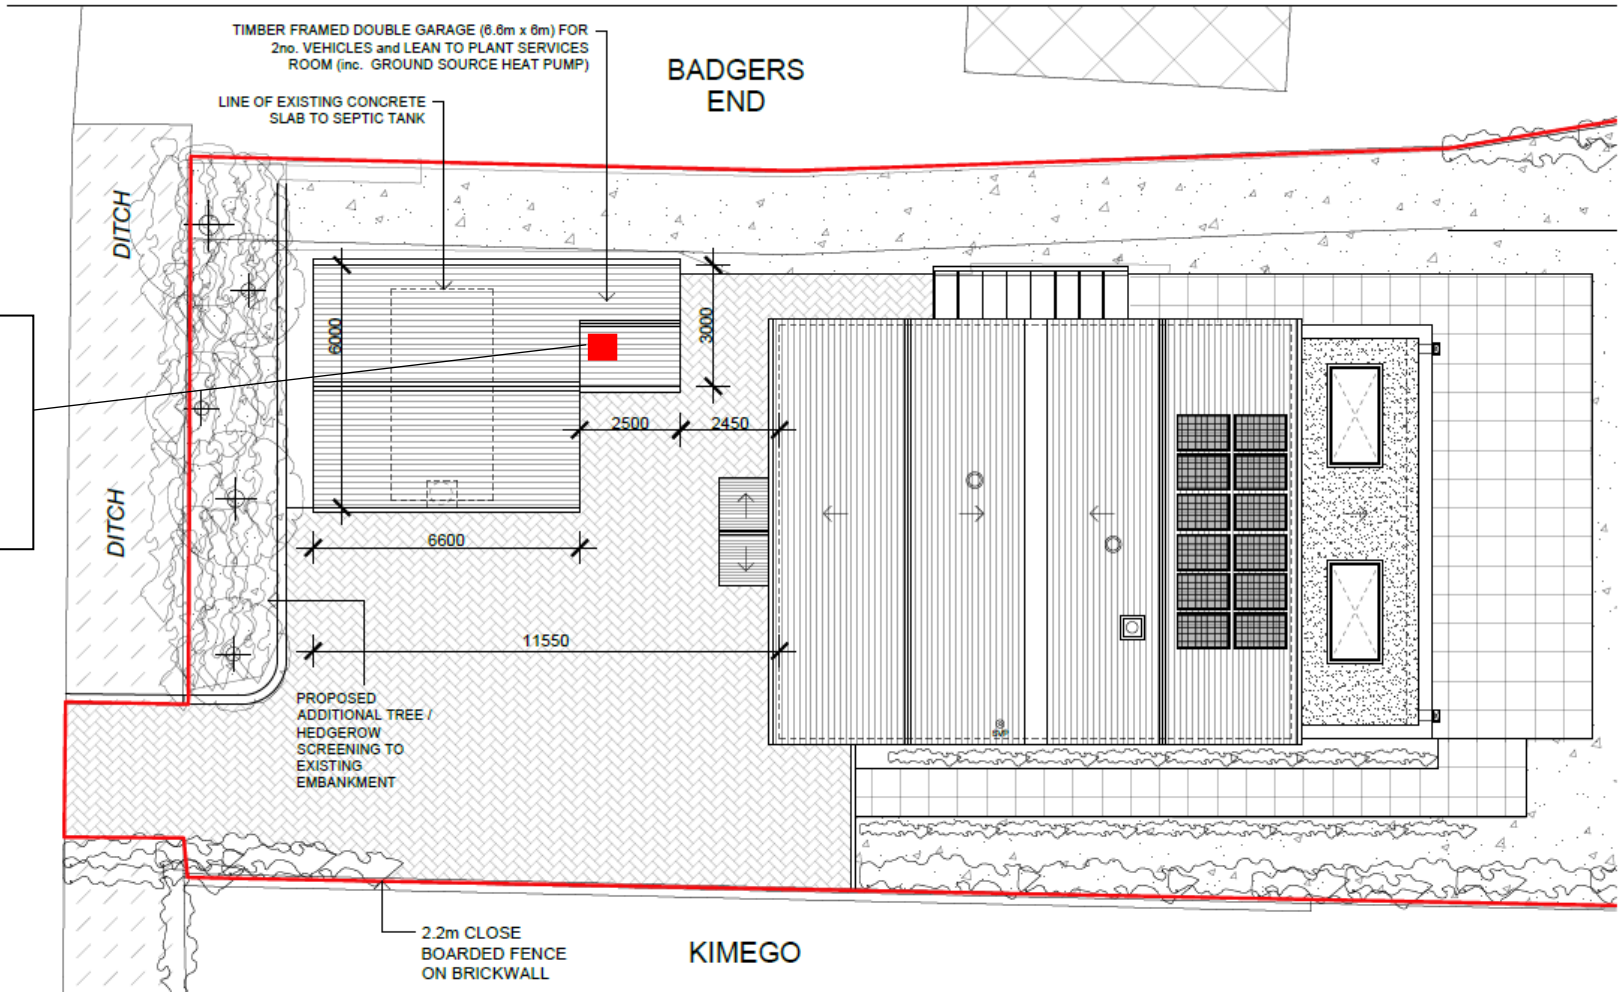

PROPOSED



K V B ARCHITECTS	K V B Architects Ltd Chartered Architects	CLIENT Mr & Mrs Valentine	SCALE 1:100 @ A3 DATE 03.03.21
	9 High Street Tring, Herts HP23 5AH Tel: +44 (0)1442 824691 Email: greg@kvbarchitects.co.uk www.kvbarchitects.co.uk	PROJECT Treasures, Drayton Beauchamp, Buckinghamshire, HP22 6LS	DRAWN OE CHECKED GB
		TITLE Proposed Site Plan	DRAWING NO. 302
			JOB NO. 2019K0194 REVISION -