 



PROPOSED DRAINAGE PLAN

BUTLERS ARMS FARM, GARSTANG ROAD, CHURCH TOWN

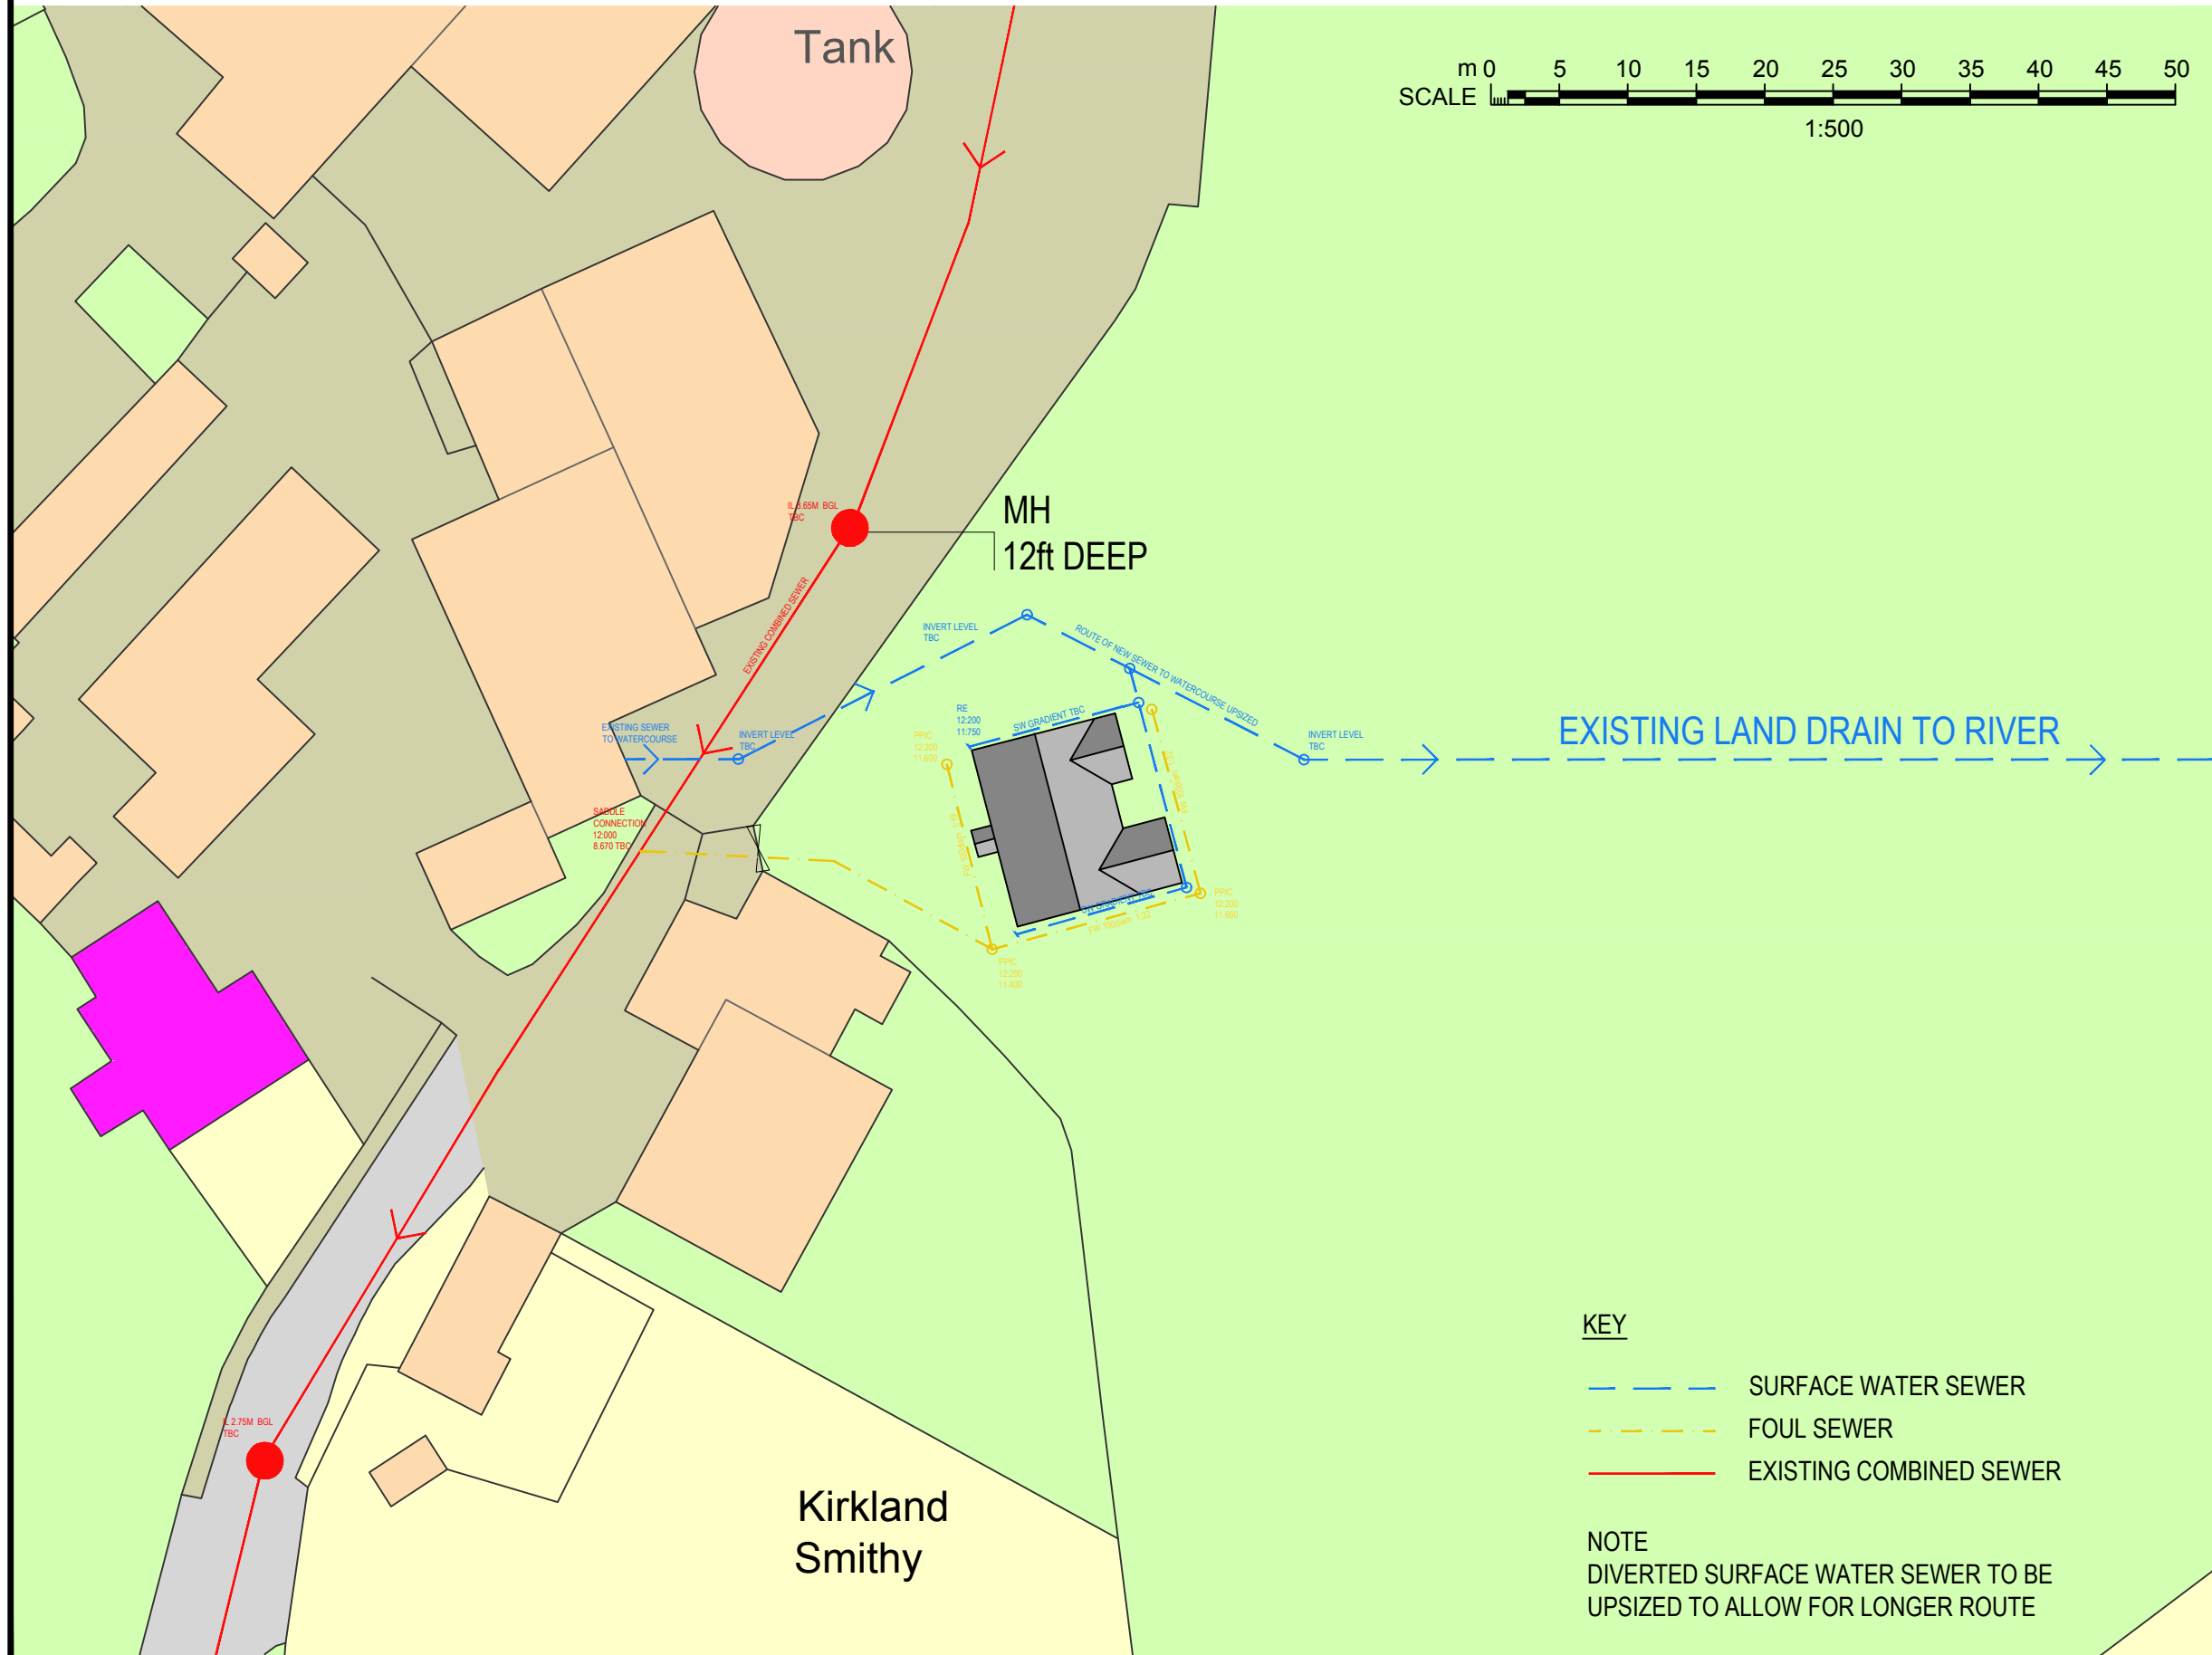

- KEY**
- — — — — SURFACE WATER SEWER
 - - - - - FOUL SEWER
 - EXISTING COMBINED SEWER

NOTE
DIVERTED SURFACE WATER SEWER TO BE UPSIZED TO ALLOW FOR LONGER ROUTE

GA

planning • architecture • design

ASSOCIATES

T: 01995 604514
 E: Info@GrahamAnthonyAssociates.com
 W: www.GrahamAnthonyAssociates.com

CLIENT: MR KIPPAX
 DWG STATUS: PLANNING PURPOSES ONLY

2 CROSTON VILLA
 HIGH STREET
 GARSTANG
 PRESTON
 PR3 1EA

PROPOSED DRAINAGE PLAN:
 BUTLERS ARMS FARM, GARSTANG ROAD, CHURCH TOWN

DRAWING No: GA3191-DP-VC-02 SCALES: 1:500 (A3) DATE: 21

ALL DIMENSIONS TO BE CHECKED ON SITE AND ANY DISCREPANCIES TO BE REPORTED TO GRAHAM ANTHONY ASSOCIATES PRIOR TO PROCEEDING WITH ANY WORKS. DO NOT SCALE OFF DRAWING AND REFER TO WRITTEN DIMENSIONS.
 THIS DRAWING IS SUBJECT TO COPYRIGHT ©