



1. This drawing has been prepared in accordance with the scope of RPS's appointment with its client and is subject to the terms and conditions of that appointment. RPS accepts no liability for any use of this document other than by its client and only for the purposes for which it was prepared and provided.
2. If received electronically it is the recipient's responsibility to print to correct scale. Only written dimensions should be used.
3. This drawing should be read in conjunction with all other relevant drawings and specifications.

10m SCALE 1:500

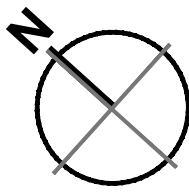

Key

- 1500 @ 1:150 FW Sewer (ID & Gradient)
- Existing Infrastructure FW Sewer
- Existing Infrastructure FW Manhole
- F1 FW Manhole CW Non Return Valve - Please refer to RPS drawing NCL061-RPS-XX-00-DR-C-3101 for details
- F1 FW Manhole
- FW Package Pumping Station
- Foul Rising Main
- SDG Sprinkler Discharge Gully
- G Road Gully
- Drainage Easement

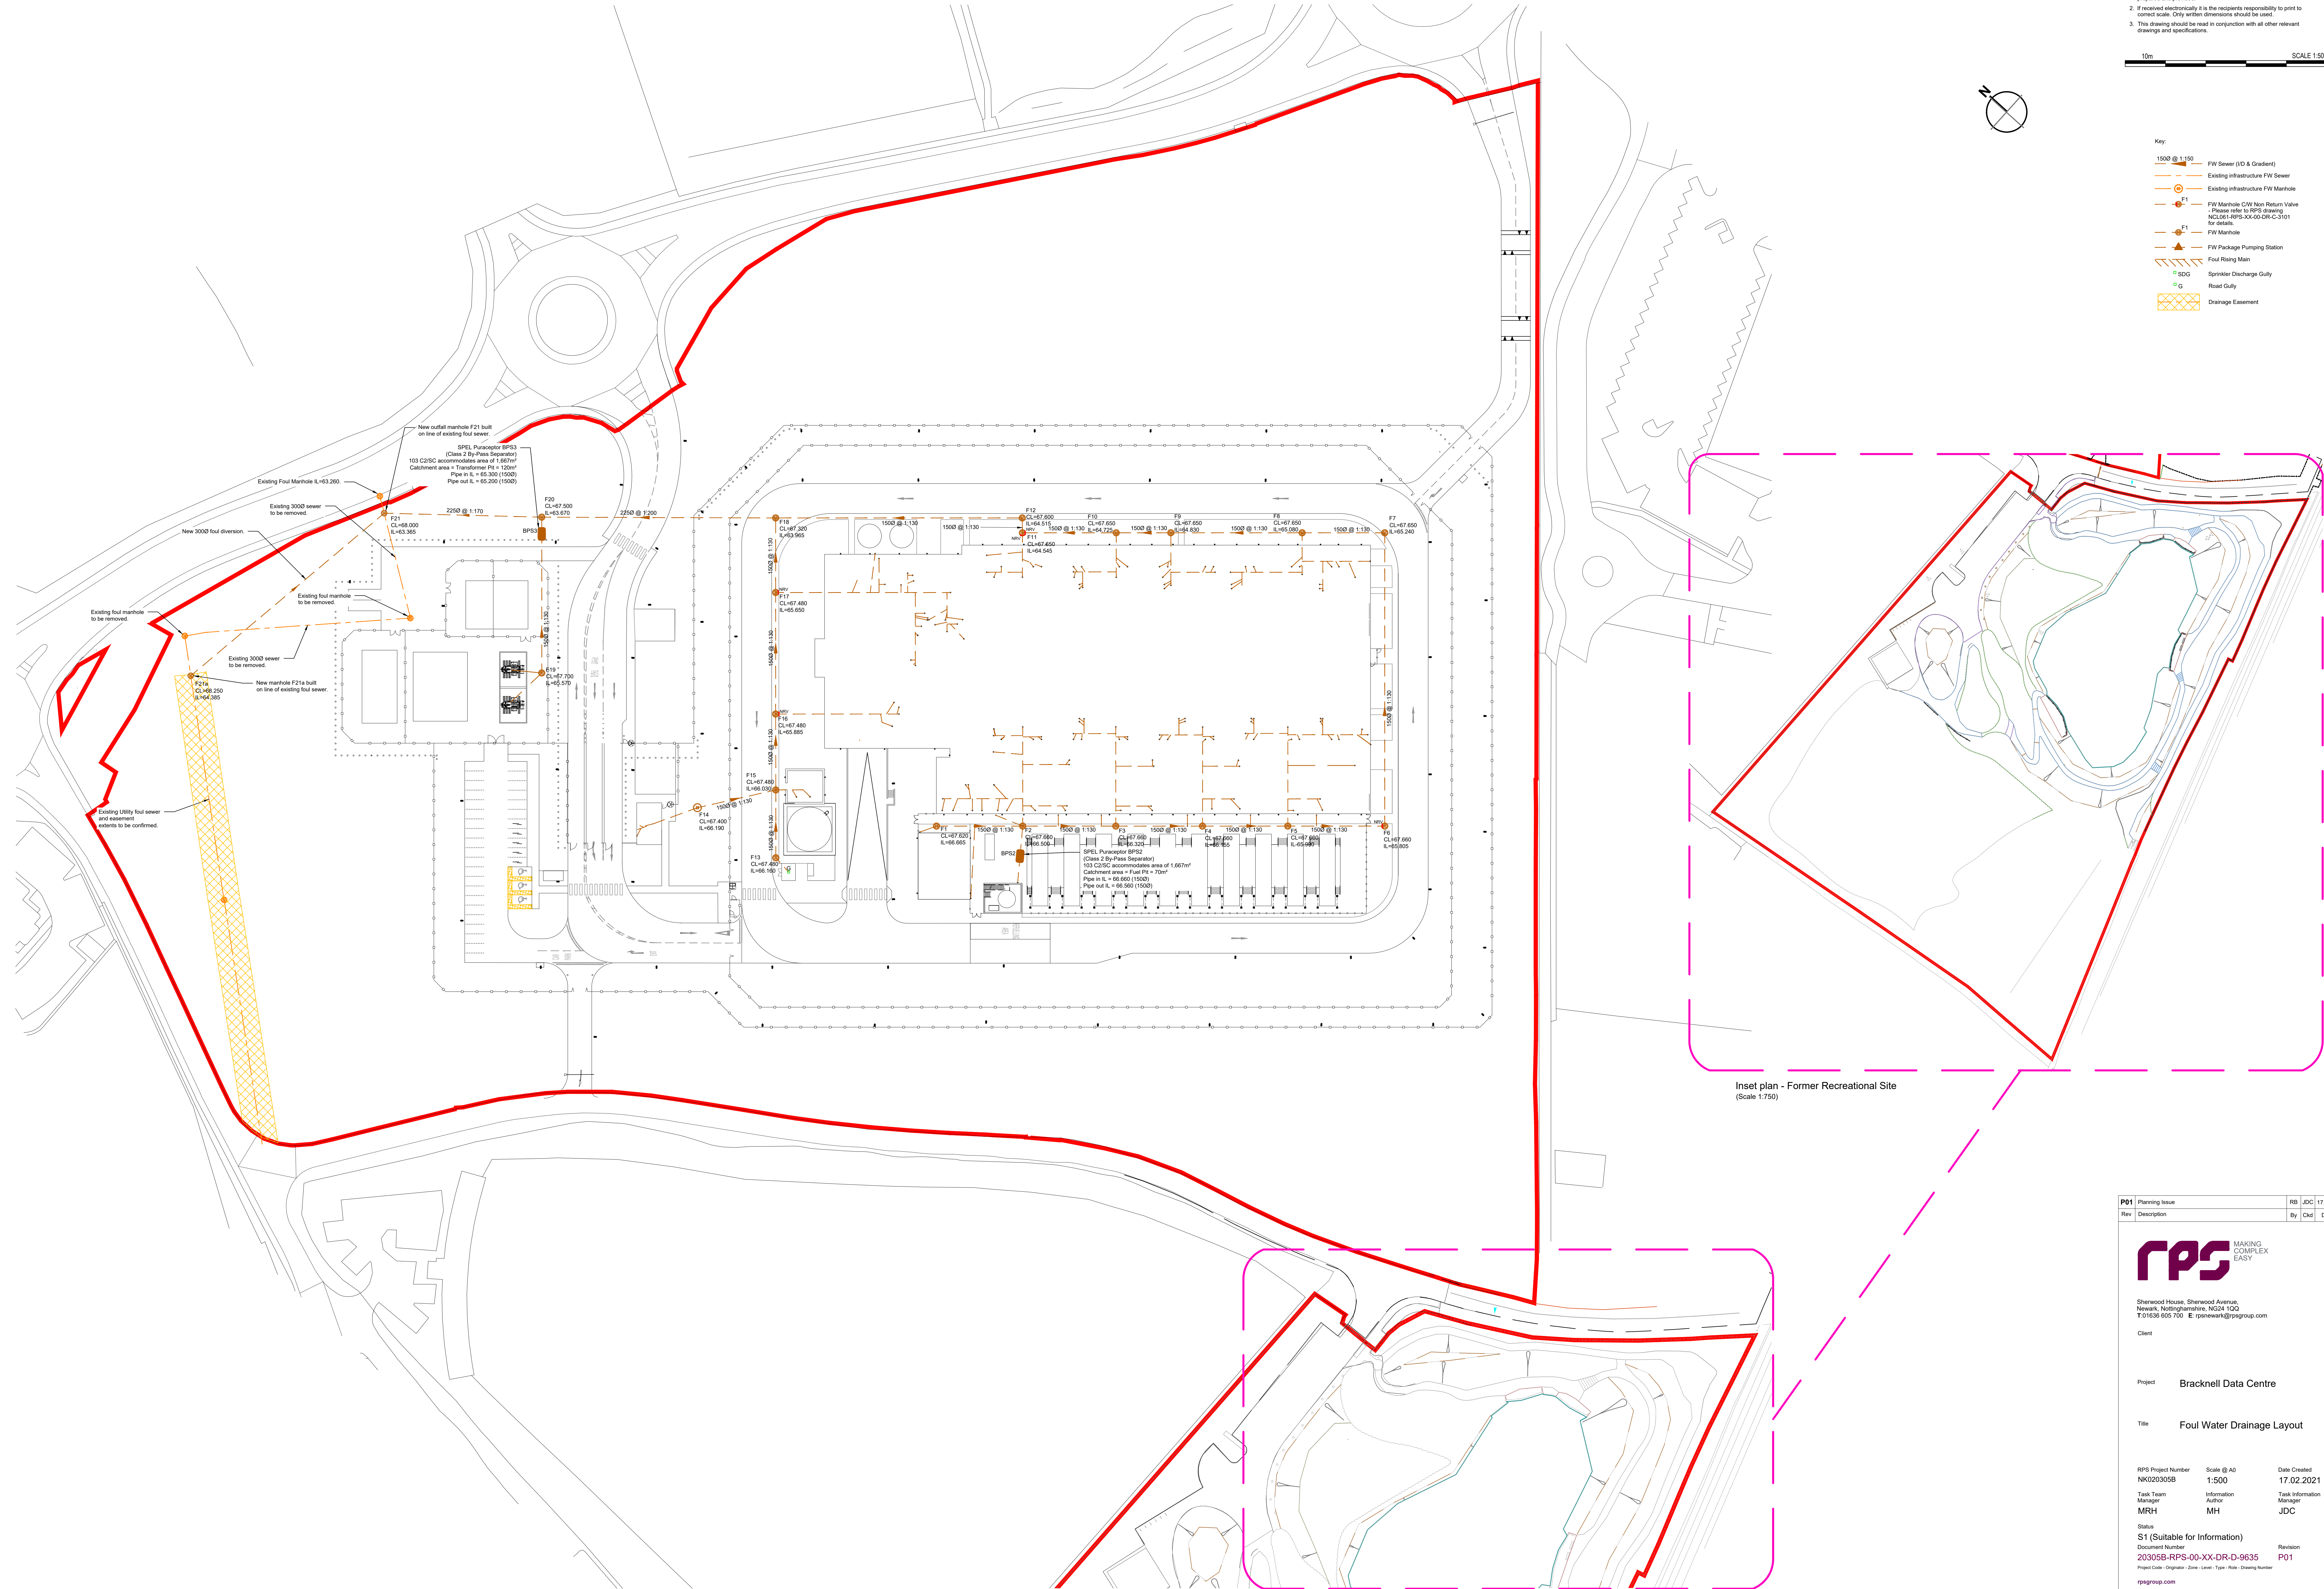

Inset plan - Former Recreational Site  
(Scale 1:750)

P01 Planning Issue		RB	JDC	17.02.21
Rev	Description	By	Chk	Date



Sherwood House, Sherwood Avenue,  
Nottingham, Nottinghamshire, NG2 4TQ  
T: 01652 665 700 E: rpsnewark@rpsgroup.com

Client

Project Bracknell Data Centre

Title Foul Water Drainage Layout

RPS Project Number NK020305B	Scale @ A0 1:500	Date Created 17.02.2021
Task Team Manager MRH	Information Author MH	Task Information Manager JDC
Series S1 (Suitable for Information)	Document Number 20305B-RPS-00-XX-DR-D-9635	Revision P01
Project Code - Originator - Zone - Level - Type - Role - Drawing Number rpsgroup.com		