




01
013
OUTLINE LIGHTING PLAN VISUALISATION
NTS

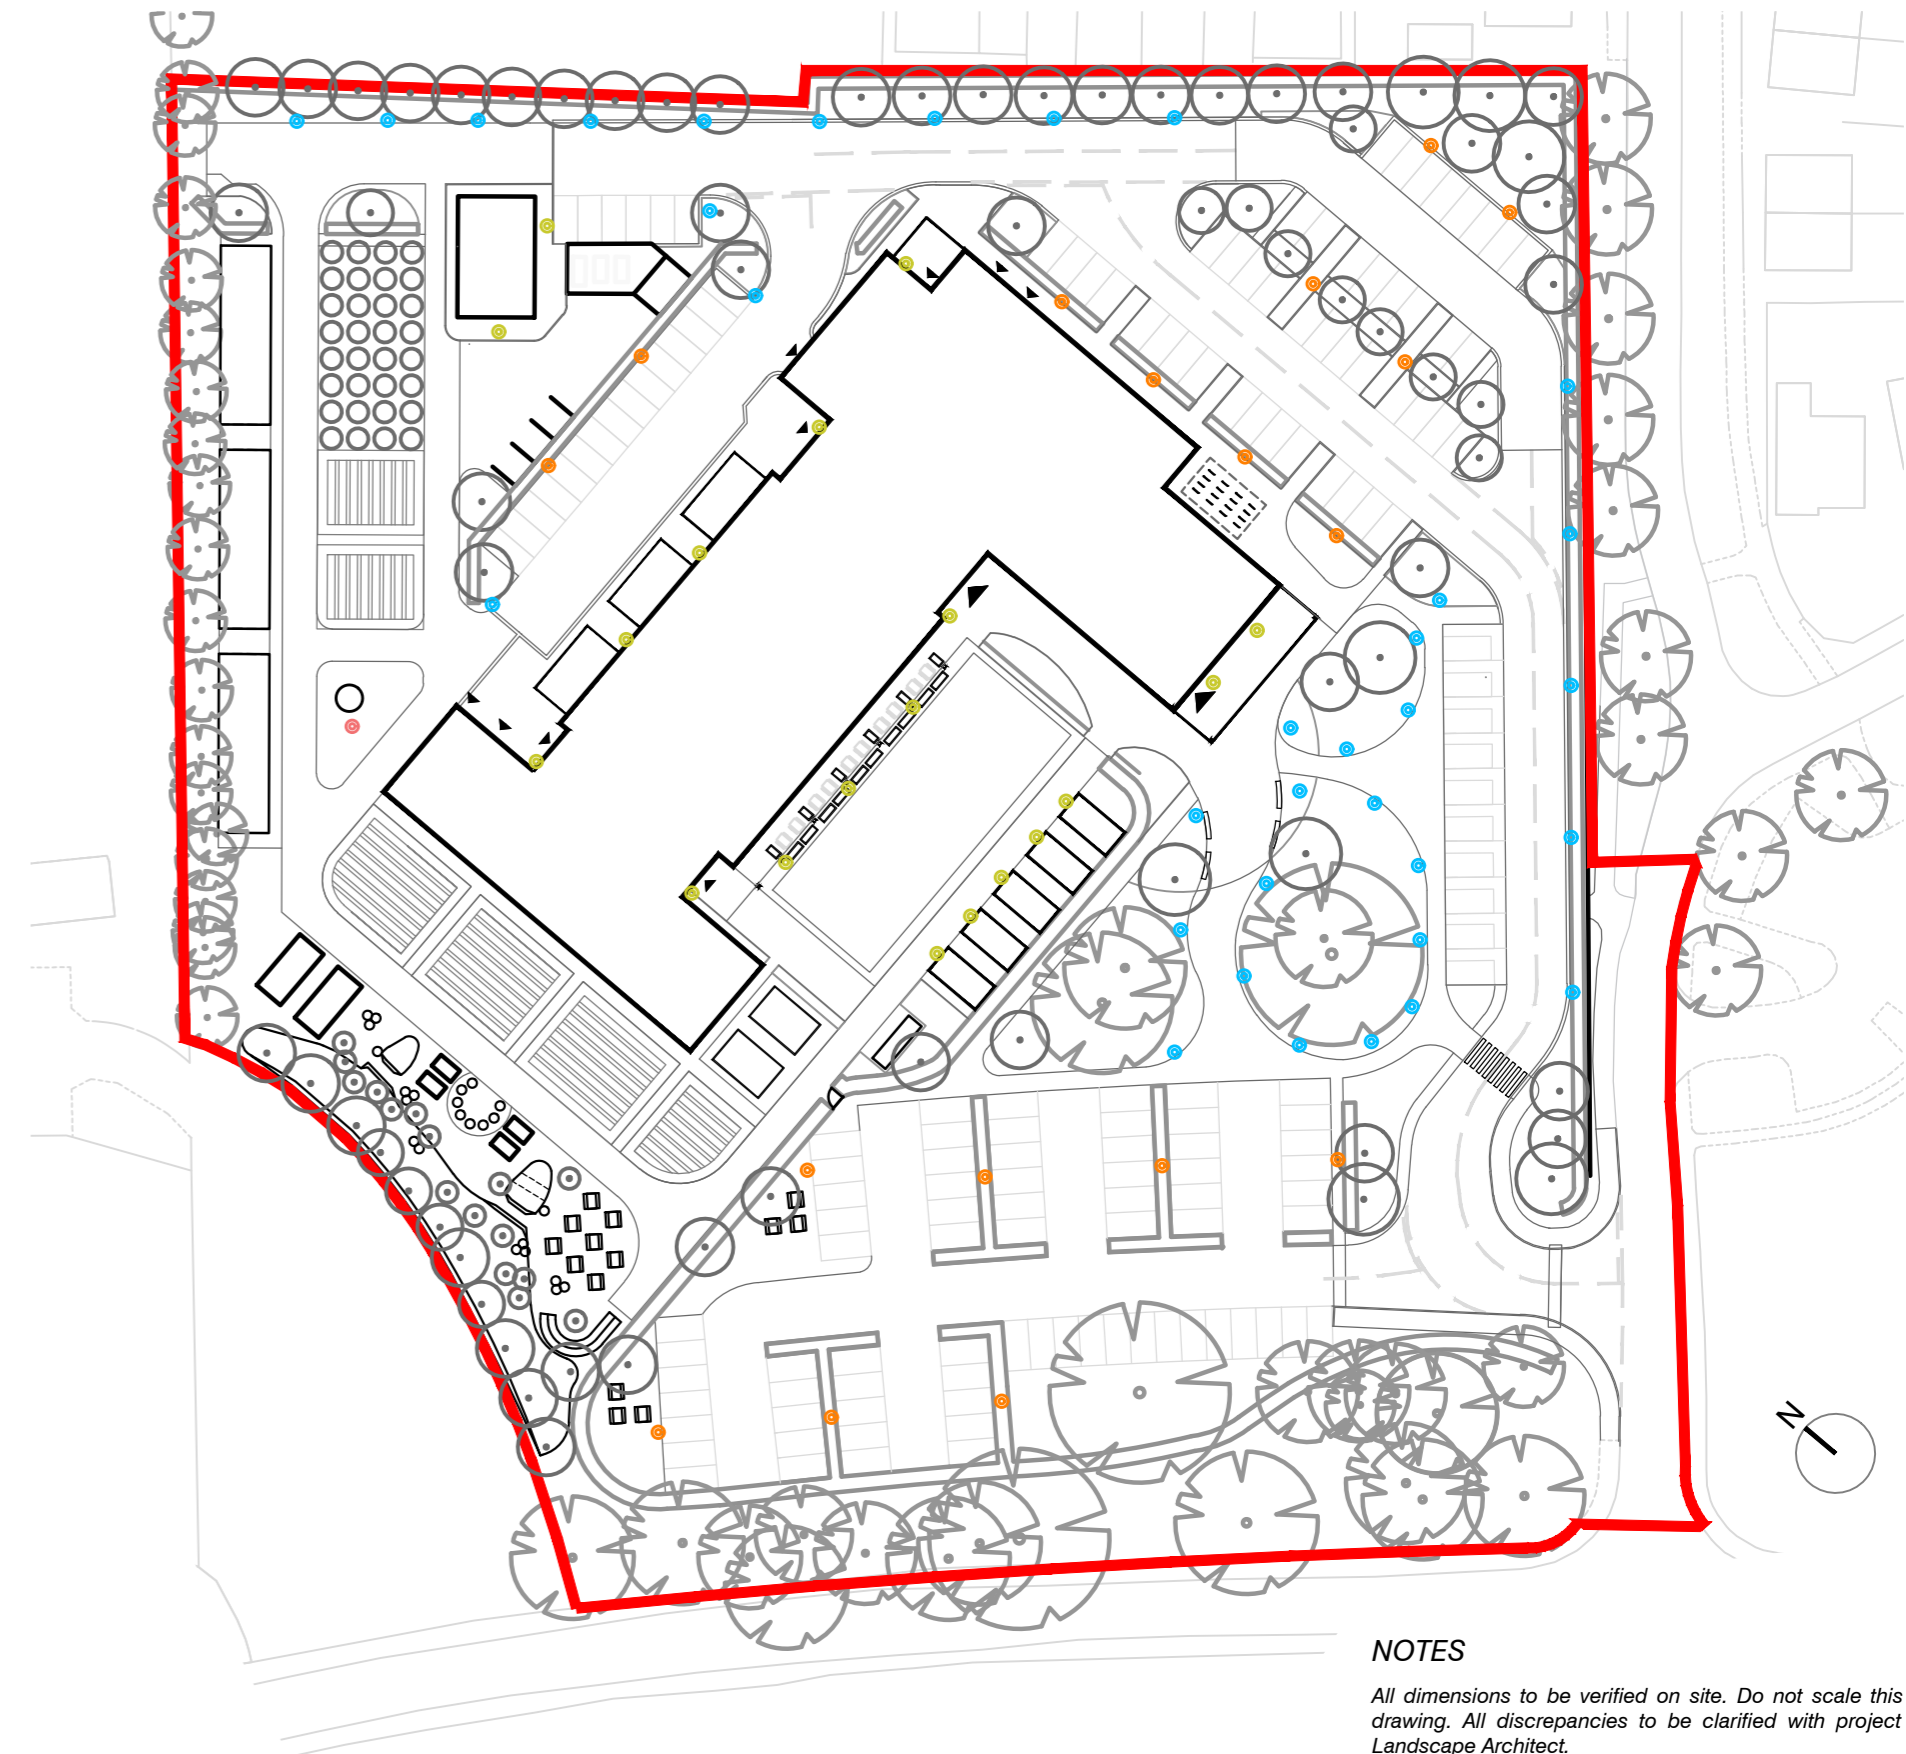

02
013
OUTLINE LIGHTING LAYOUT
NTS

KEY

- Lighting Column
Iguzzini; Street; Pole mounted lighting system or similar
- Lighting Bollard
Iguzzini; Walky & iWay round; lighting bollards or similar
- Feature Uplighter
Iguzzini; Agora; floodlight or similar
- Downlighter (structure mounted)
Iguzzini; Lander; Wall mounted luminaire or similar

NOTES

All dimensions to be verified on site. Do not scale this drawing. All discrepancies to be clarified with project Landscape Architect.

This drawing is the property of Urban Wilderness Ltd and is issued on the condition it is not reproduced, retained or disclosed to any unauthorised person, either wholly or in part without written consent of Urban Wilderness Ltd.

1. DRAWINGS FOR PLANNING PURPOSE ONLY.
2. Drawings based on digital information survey provided by Lewis Brown and OS Mastermap.
3. This drawing represents an outline lighting strategy only and will be subject to further design development by M&E Engineer following planning.

-	First Issue	18 Feb 21
rev	details	date



7 Saw Mill Yard, Water Lane, Holbeck,
Leeds, LS115WH
www.urbanwilderness.co.uk
design@urbanwilderness.co.uk
0113 472 0030
registered in Scotland SC371979

client
Applegarth Farm
project
Applegarth Farm

drawing title
Outline External Lighting Strategy

drawing status		
PLANNING		
drawn by	checked by	date
SDJ	TBR	18 Feb 21
scale	paper size	
NTS	A2	
job/dwg no.	rev.	
291-UW-P-013	-	