




BEST DECOR LONDON
 84 UXBRIDGE ROAD
 LONDON ENGLAND
 W13 8RA
 07563 28824
 bestdecorlondon@gmail.com

Address:
 49 Midland Road, NN8 1HF



Proposed installation of extraction flue system for the restaurant .

Dwg.no: 01
 scale 1:100

DATE March 2021

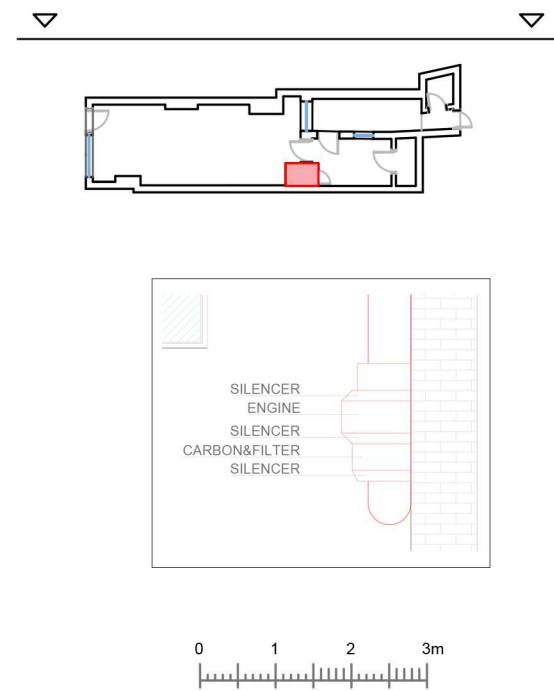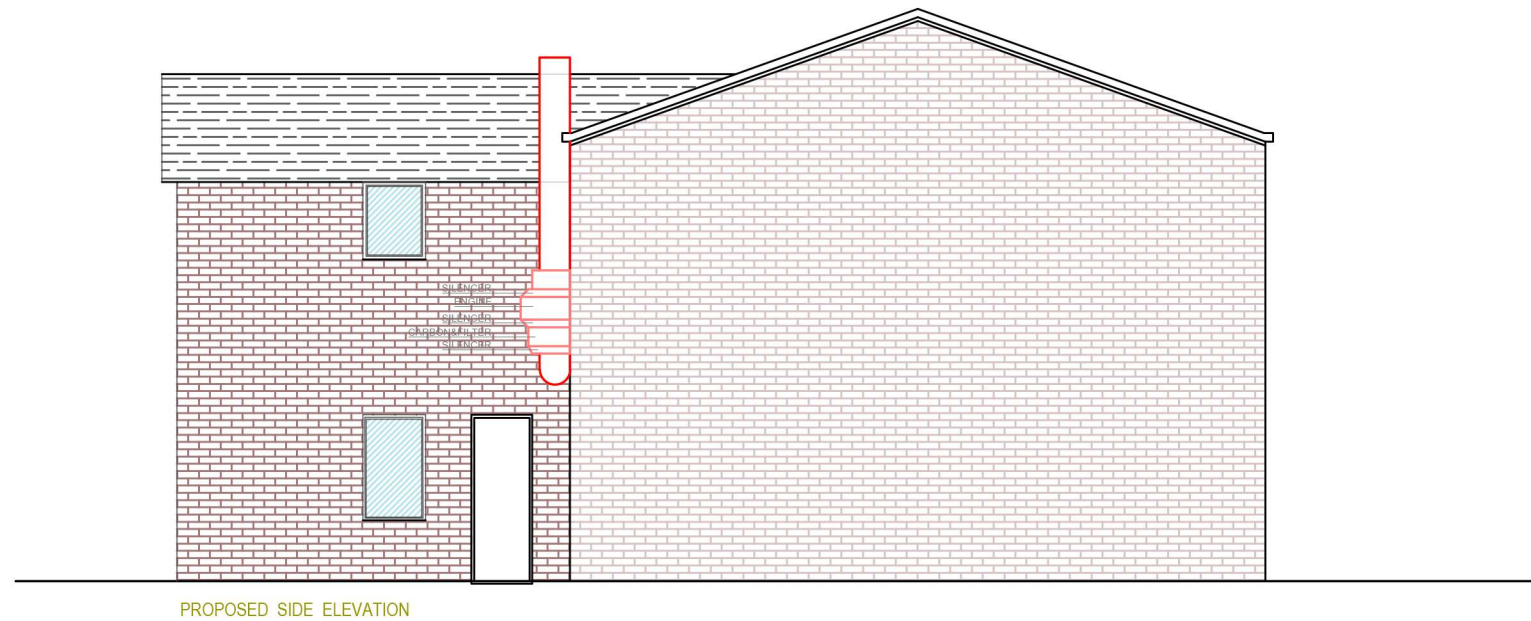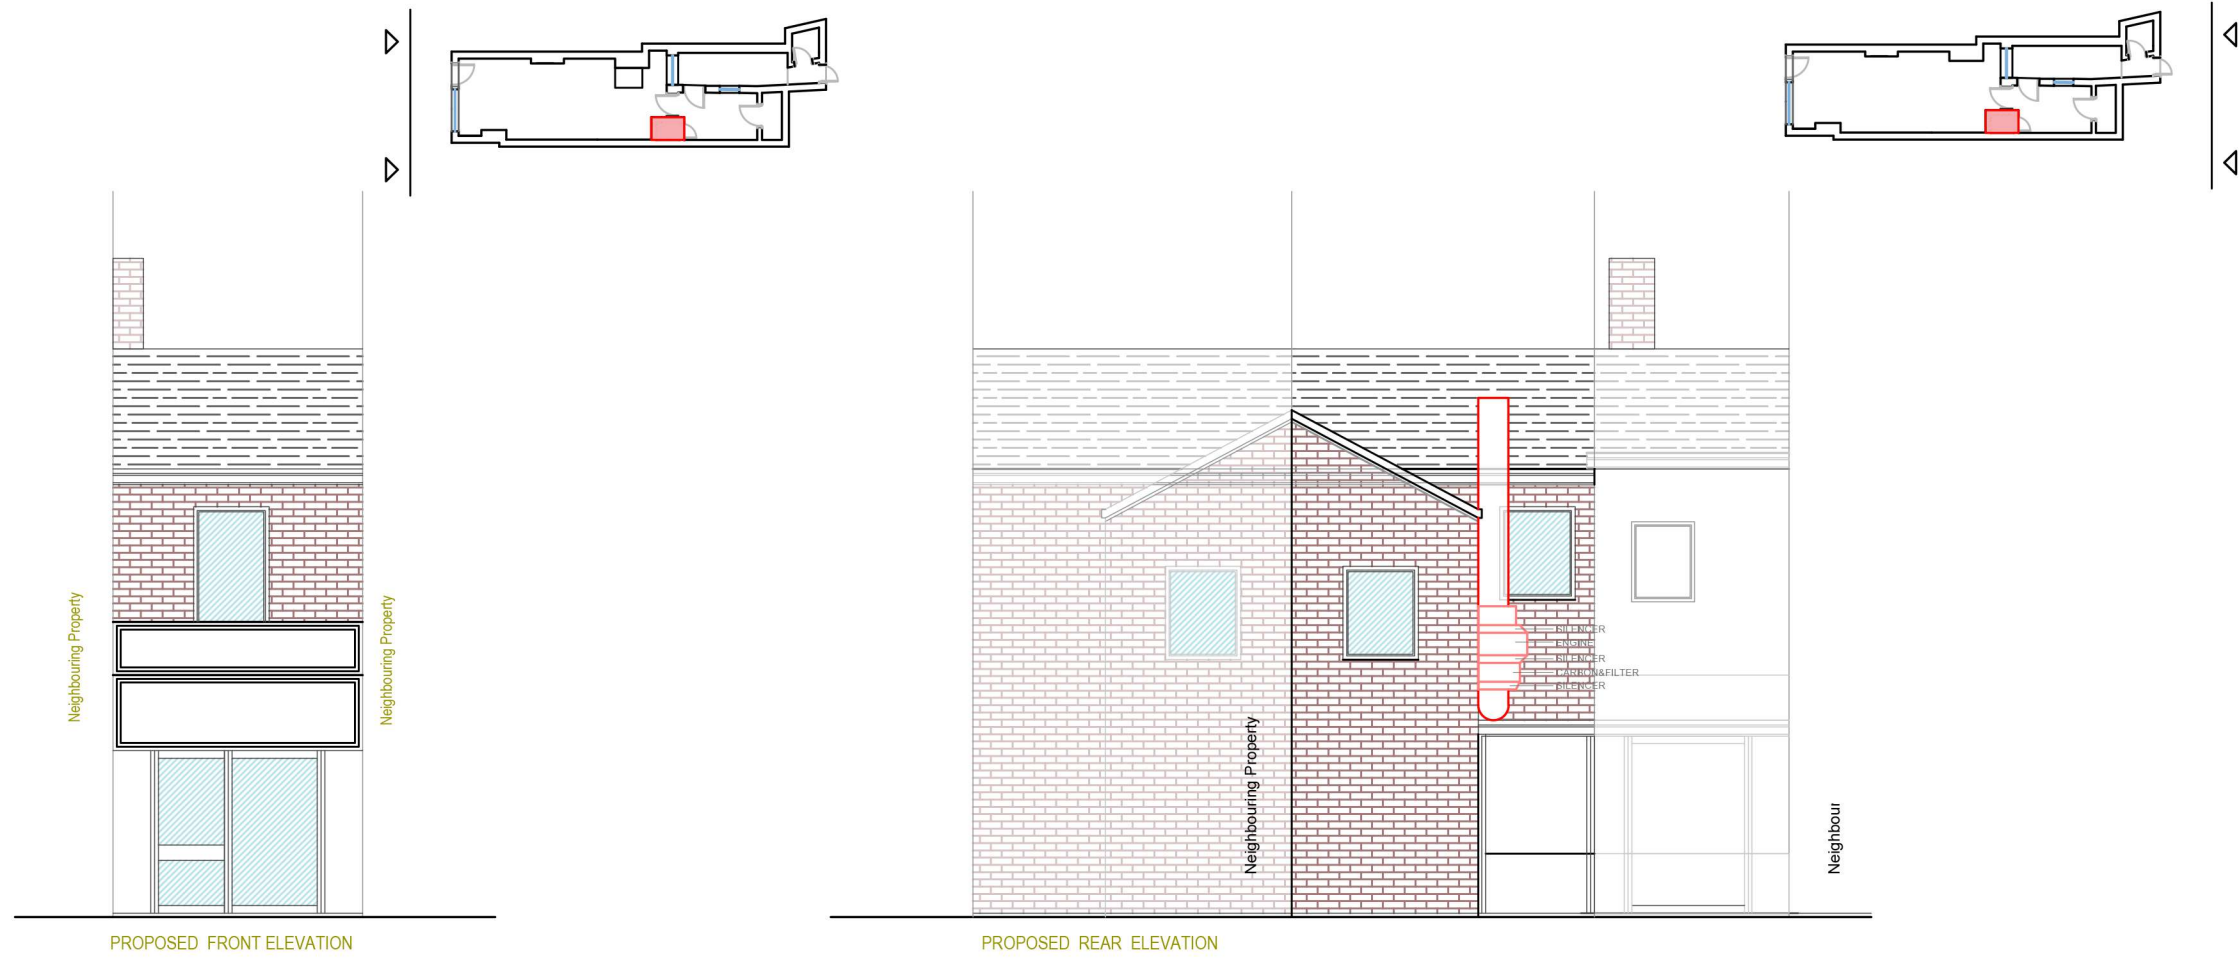

BEST DECOR LONDON
84 UXBRIDGE ROAD
LONDON ENGLAND
W13 8RA
07563 288824
bestdecorlondon@gmail.com

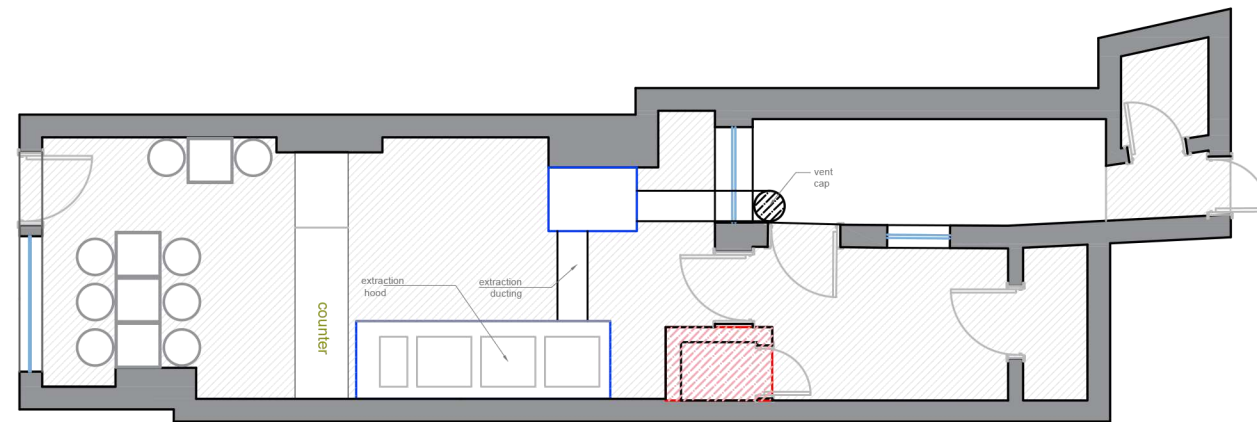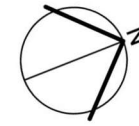

PROPOSED GROUND FLOOR VENTILATION PLAN



Address:
49 Midland Road, NN8 1HF

Proposed installation of extraction flue
system for the restaurant .

Dwg.no: 02

DATE March 2021