


- This drawing is the copyright of HNW Architects Ltd Registered No. 3589904
 - All dimensions must be verified on site prior to construction.
 - Do not scale this drawing except for Planning Application purposes.
 - Ordnance Survey Licence No. 10000200
 - Only PDF issues of this drawing are controlled. All other formats of this drawing (e.g. .dwg Autocad or .rvt Revit files) are un-controlled and are used at your own risk.
 - This drawing must not be copied, transmitted or passed to a third party, without written consent.


| Rev | Amendments | by | chkd | Date |
|-----|----------------|----|------|----------|
| P1 | Planning issue | BR | AC | 22/05/20 |

--- SITE BOUNDARY

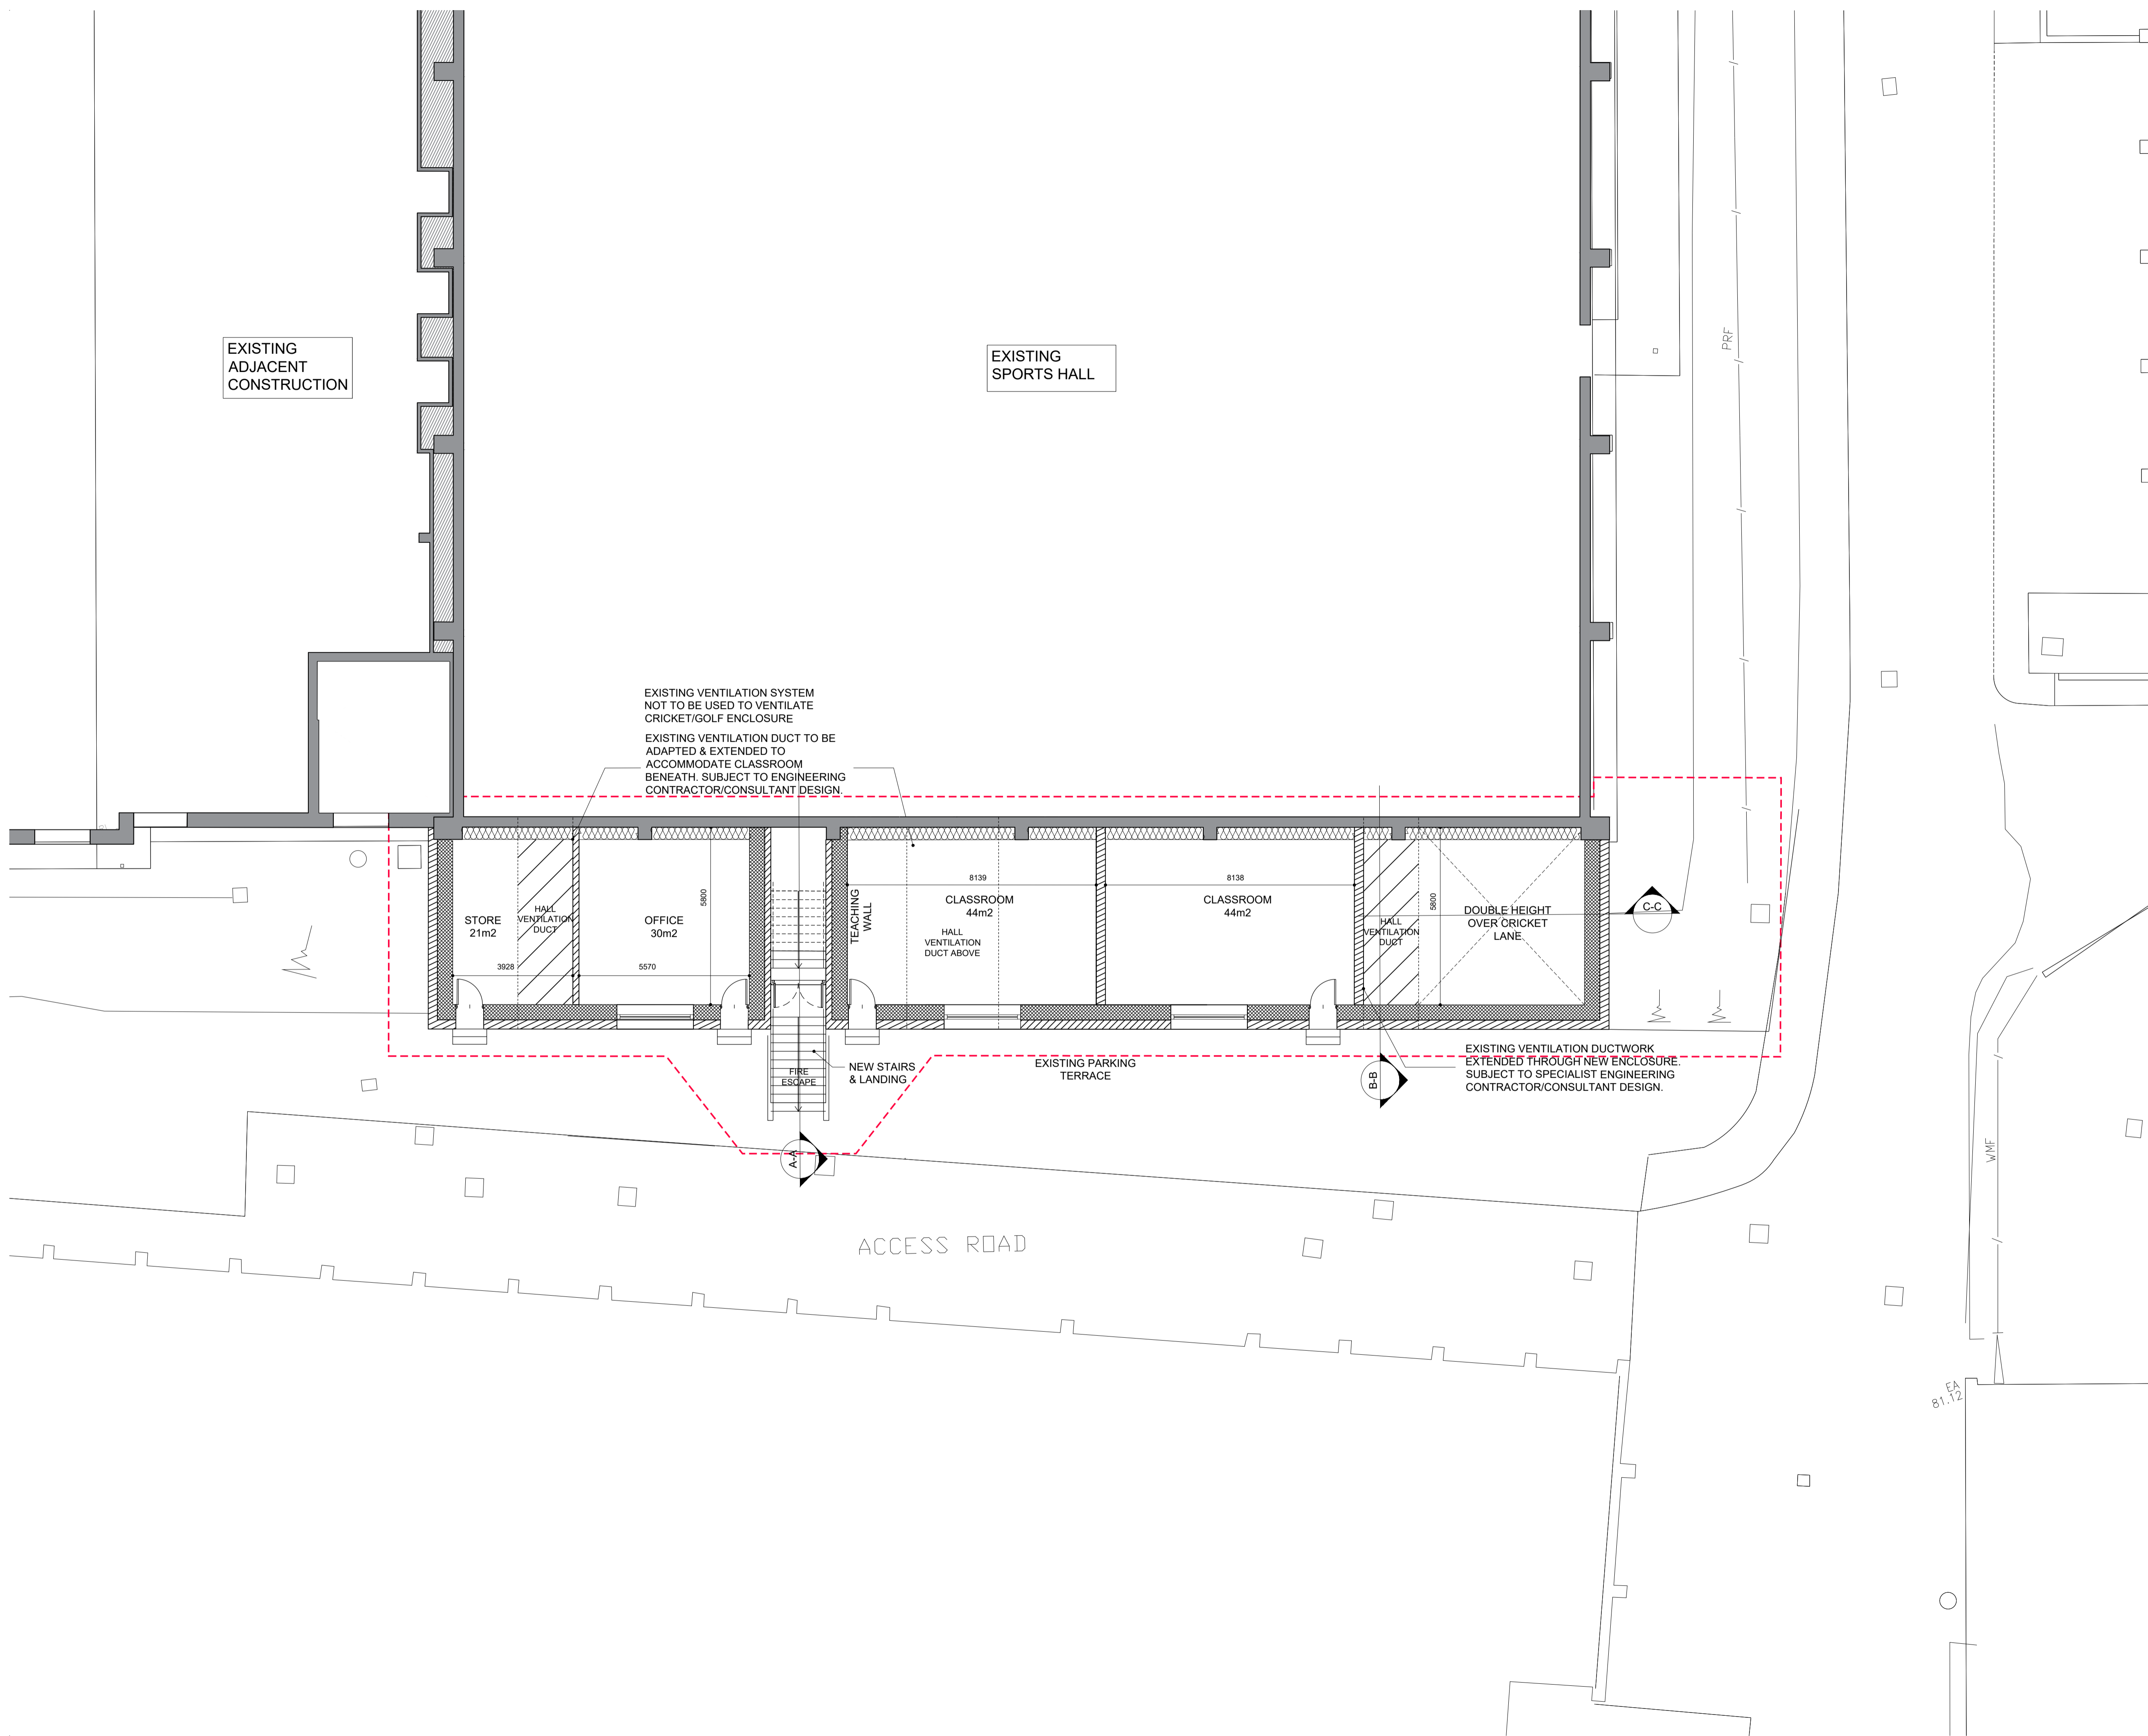

NOTES:

- All ventilation is to be via alternative Vent system and not from existing sports hall system. Ventilation is subject to design by specialist engineering contractor/consultant.
- Heating is subject to design by specialist engineering contractor/consultant. Where condensers are required, they are to be located on new concrete pad behind Johnson Centre.
- Acoustic insulation is required to existing sports hall used for exams.
- Fire escape provisions to meet Building Regulation requirements.

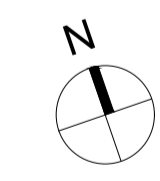

Scale 1:100

Project
SEAFORD COLLEGE
PETWORTH, WEST SUSSEX

Drawn By SA Checked By AC HNW Project No. 19037 Date Created JAN 2020

Scale
A1- 1:100

Drawing Title
PROPOSED FIRST FLOOR PLAN

Drawing Status PRELIMINARY Revision P1

Drawing Number
19037-HNW-XX-00-DR-A-2201

81 North Street, Chichester, West Sussex, PO19 1JH

