


NOTE: Contractor to carry out percolation test.
See engineer's drainage information

Adjacent properties and boundaries are shown for illustrative purposes only and have not been surveyed unless otherwise stated.
Do not scale from this drawing except for planning consent purposes.

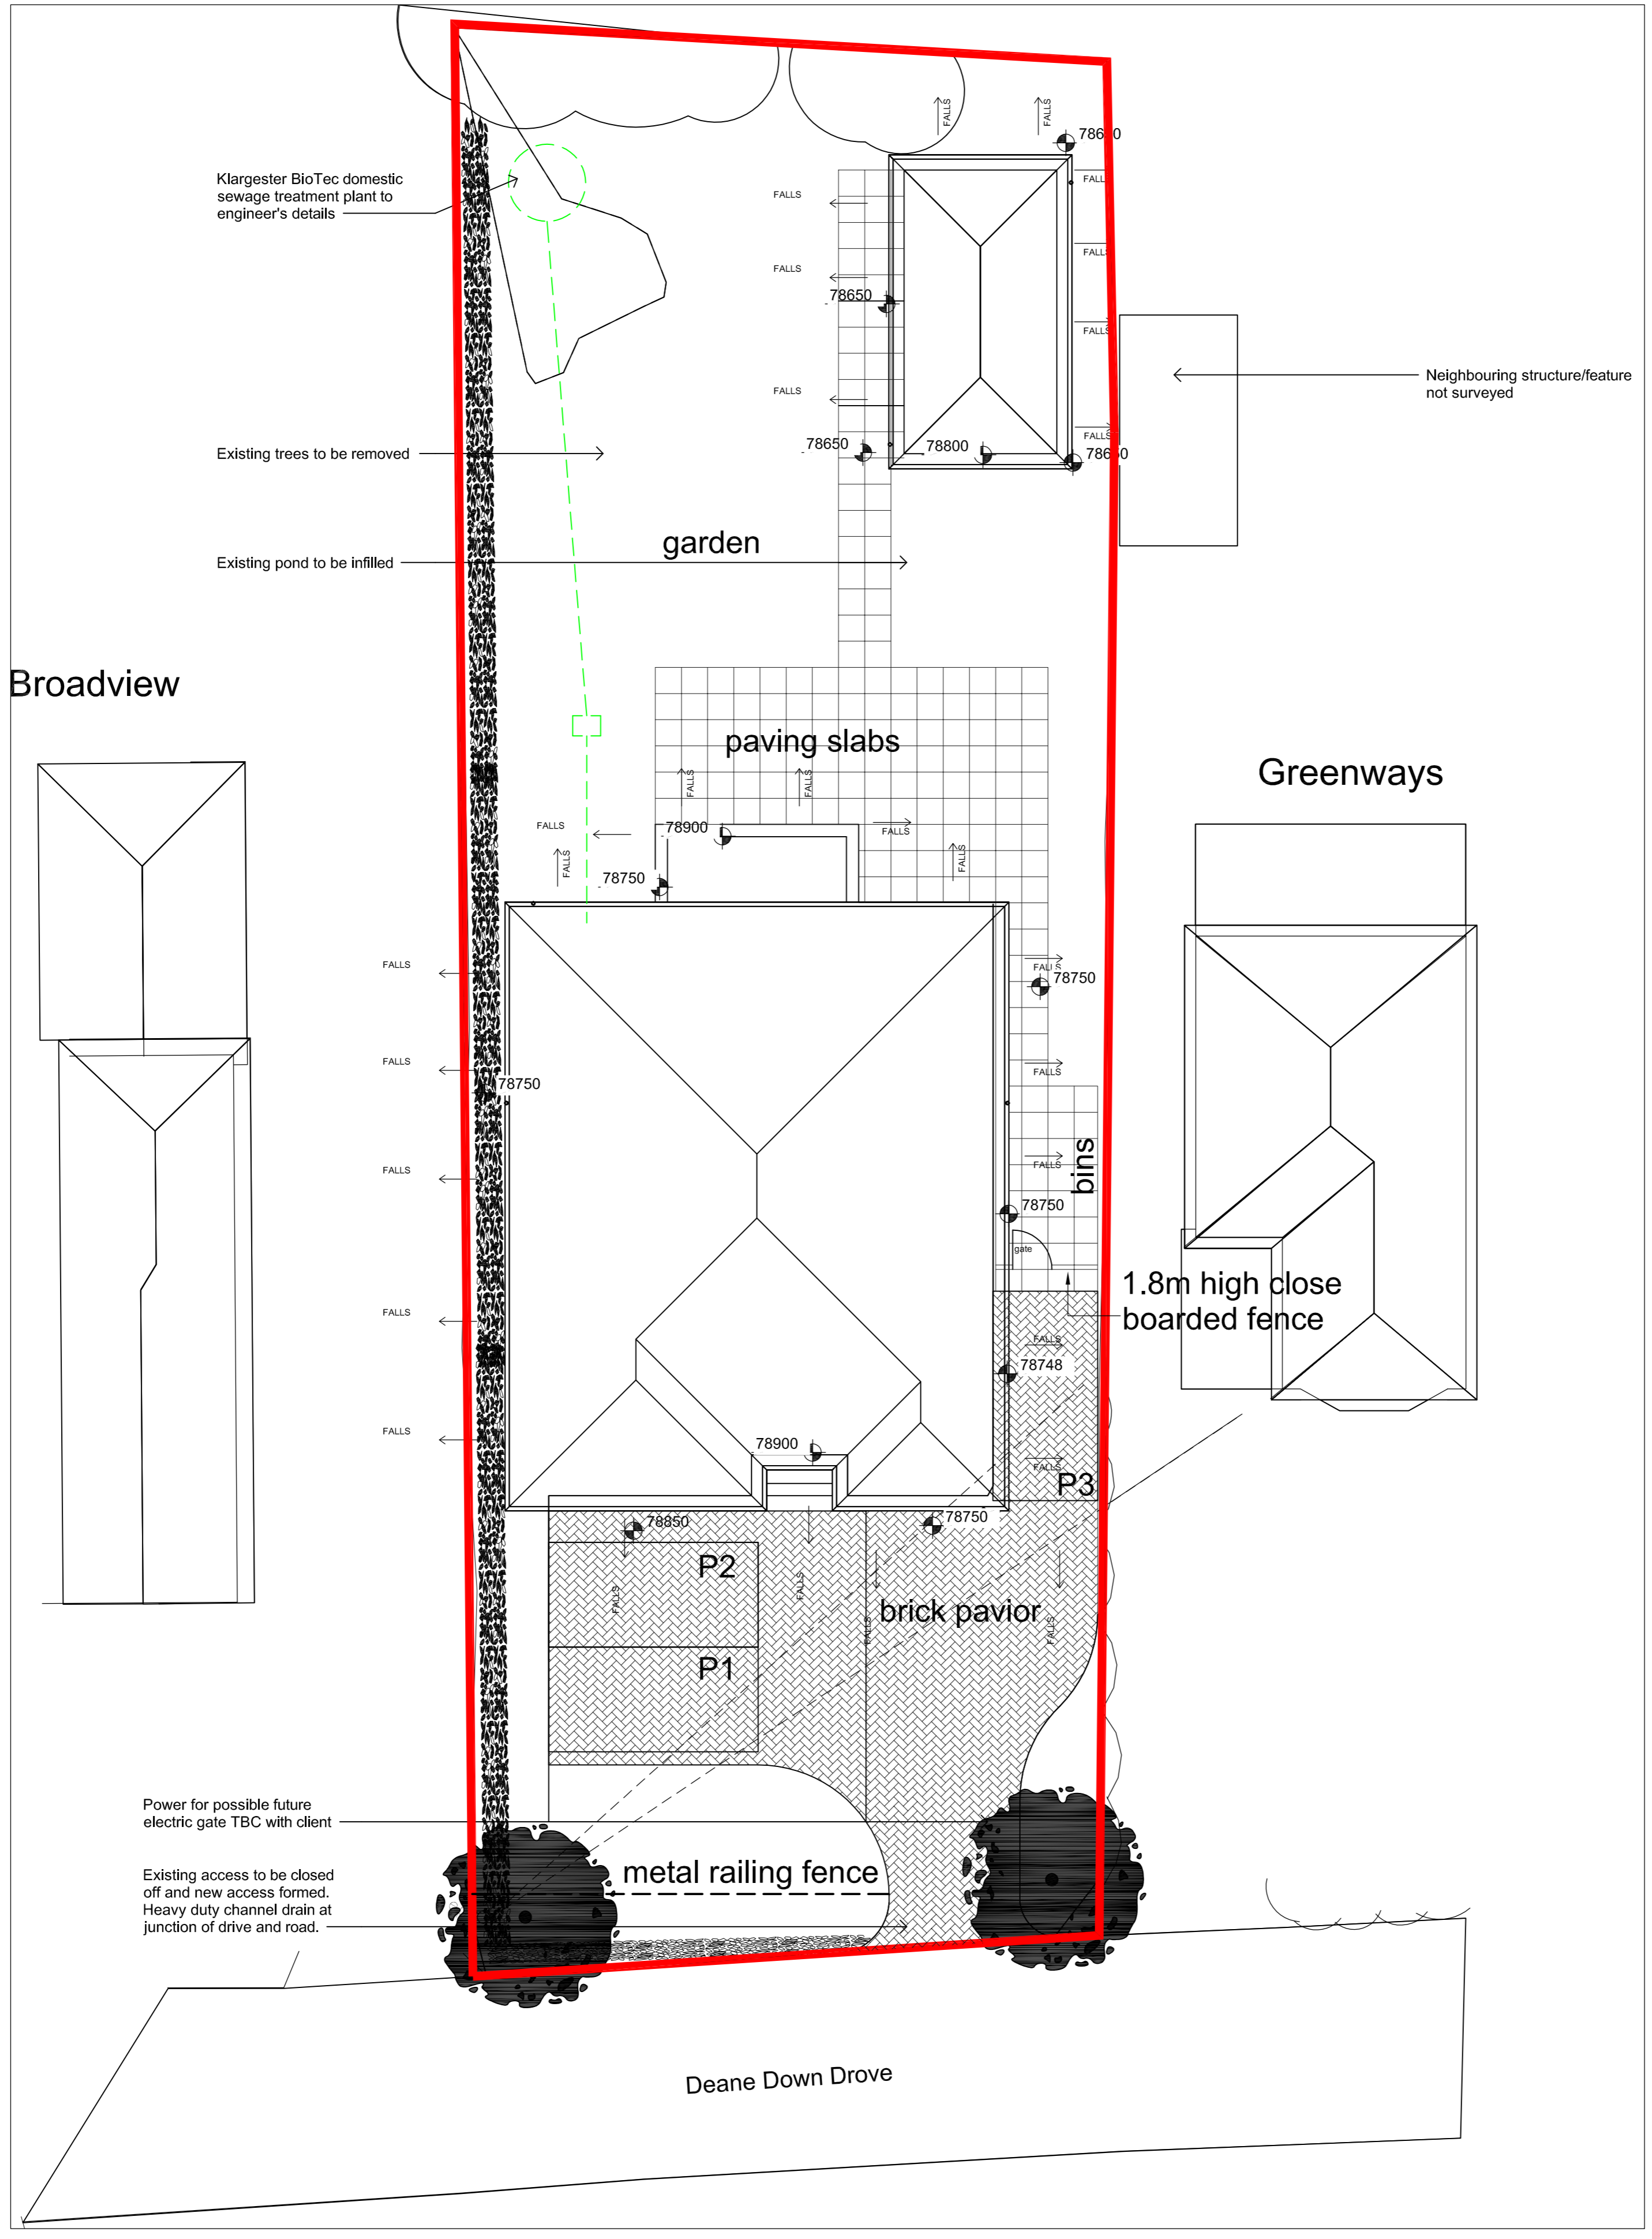

Broadview


Greenways

Power for possible future electric gate TBC with client

Existing access to be closed off and new access formed. Heavy duty channel drain at junction of drive and road.

Neighbouring structure/feature not surveyed

Revision	No.	Description	Drawn	Checked
B	4.10.20	Layout revised	mw	
A	09/09/2019	Tender Issue	AB	MW

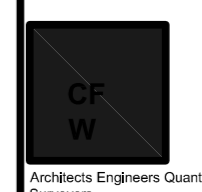

Chaplin Farrant Wilshire Limited
Bank Chambers, 69 High Street, Winchester, SO23 9DA
Tel: 01962 862234
Fax: 01962 840506
studio@cfw-architects.com
www.cfw-architects.com

Also at:
Norwich
London

This drawings is copyright of the Architects and shall not be reproduced without their permission and shall not be used for any purpose than indicated on the status indicated

Check all dimensions and report any errors or omissions

Do not scale from this drawing

TENDER

Mr & Mrs Ivins

Valetta, Deane Down Drive, Littleton

Proposed Site Plan

J19128w

AP005 B

07/03/19 1:100 @ A1

AB MW

Scale 1 : 100

