

NOTES:

PARTY WALL etc. ACT 1996
The client is responsible as the building owner to undertake the necessary steps to comply with the ACT where applicable

CDM
The client is responsible as the building owner to fully comply with CDM regulations 2015 (Construction, Design & Management)

BUILDING CONTRACTOR NOTES

The details/ illustrations on these drawings are illustrative only. The successful building contractor will need to verify on site prior to any works commencing on site

The electrical layout is to be agreed with the house owner prior to any works commencing on site


The plumbing/ central heating layout is to be agreed with the house owner prior to any works commencing on site

All goods, materials, services and labour provided are to meet current building regulations and are to be adequate for the purpose intended



COPYRIGHT

The details/ illustrations on these drawing are copyright and must NOT be reproduced without the permission of the Design AI Limited


REV	NOTES	DATE

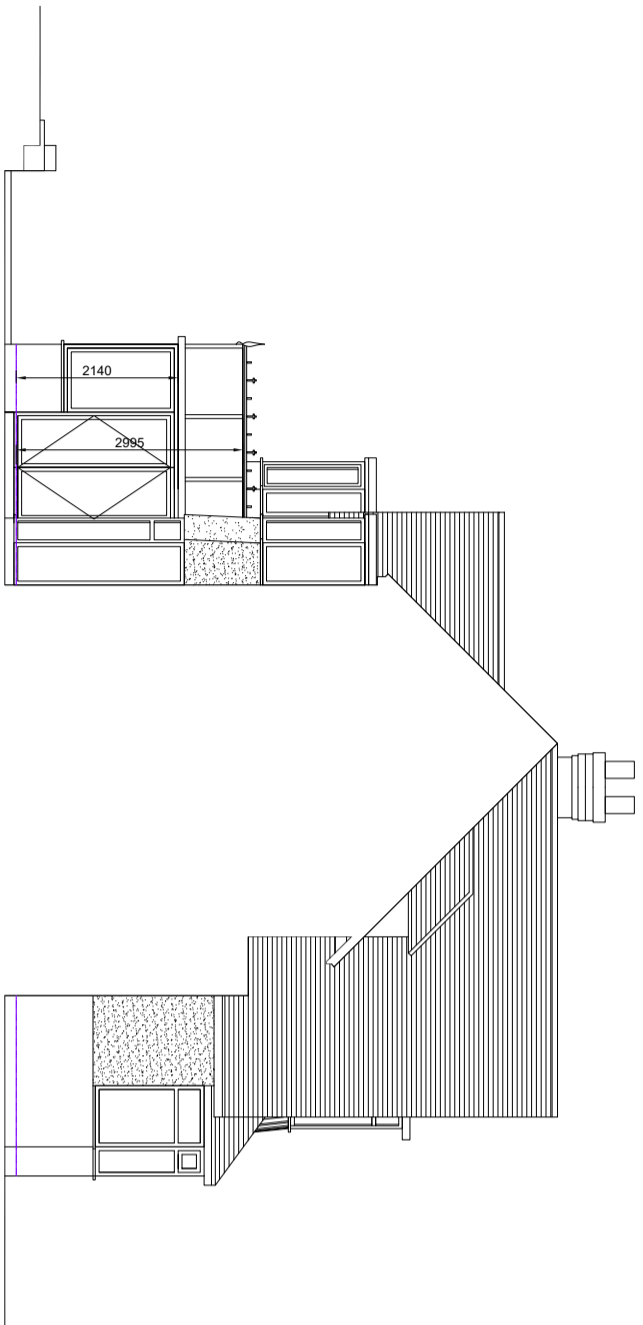

01 EXISTING SIDE ELEVATION
SCALE 1:100

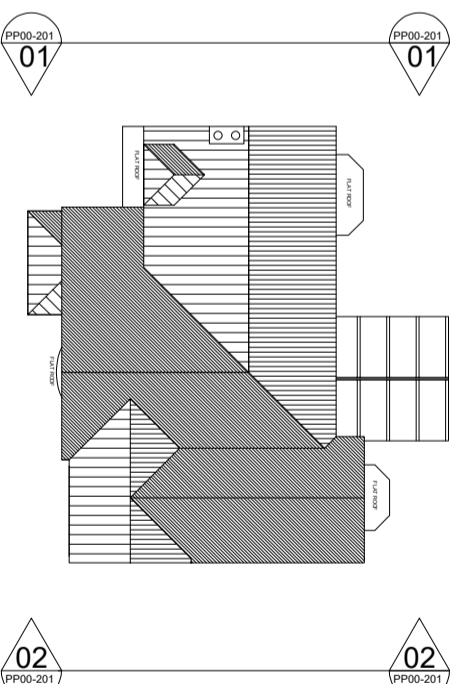 


03 KEY PLAN
SCALE 1:200

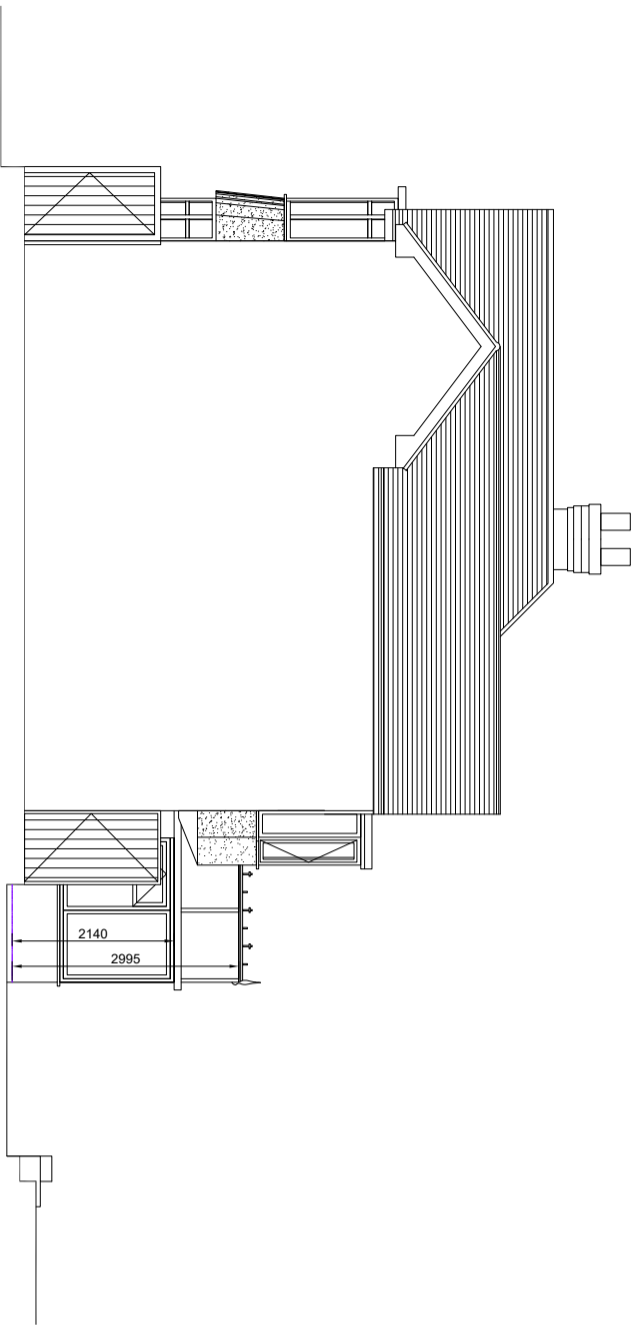

02 EXISTING SIDE ELEVATION
SCALE 1:100



EXISTING SIDE ELEVATIONS

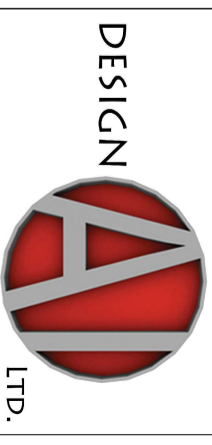

Mr and Mrs Shelton
178 Streetsbrook Road, Solihull, B90 3PH

Date	Revision
February 2021	00
Scale	Drawing number
As Shown@A3	PP00-201