


All dimensions to be checked on site.
 Figured dimensions to be read in preference to scaled.
 BCA accepts no responsibility for any unauthorised amendments to the drawing and does not permit unauthorised copying of the drawing.
 This drawing is copyright and remains the property of BCA unless otherwise agreed.

Revisions			
Date	Rev	Description	Init
01.03.21	P1	Issued to client for comment/approval	JKC
17.03.21	P2	Planning issue	JKC

Notes

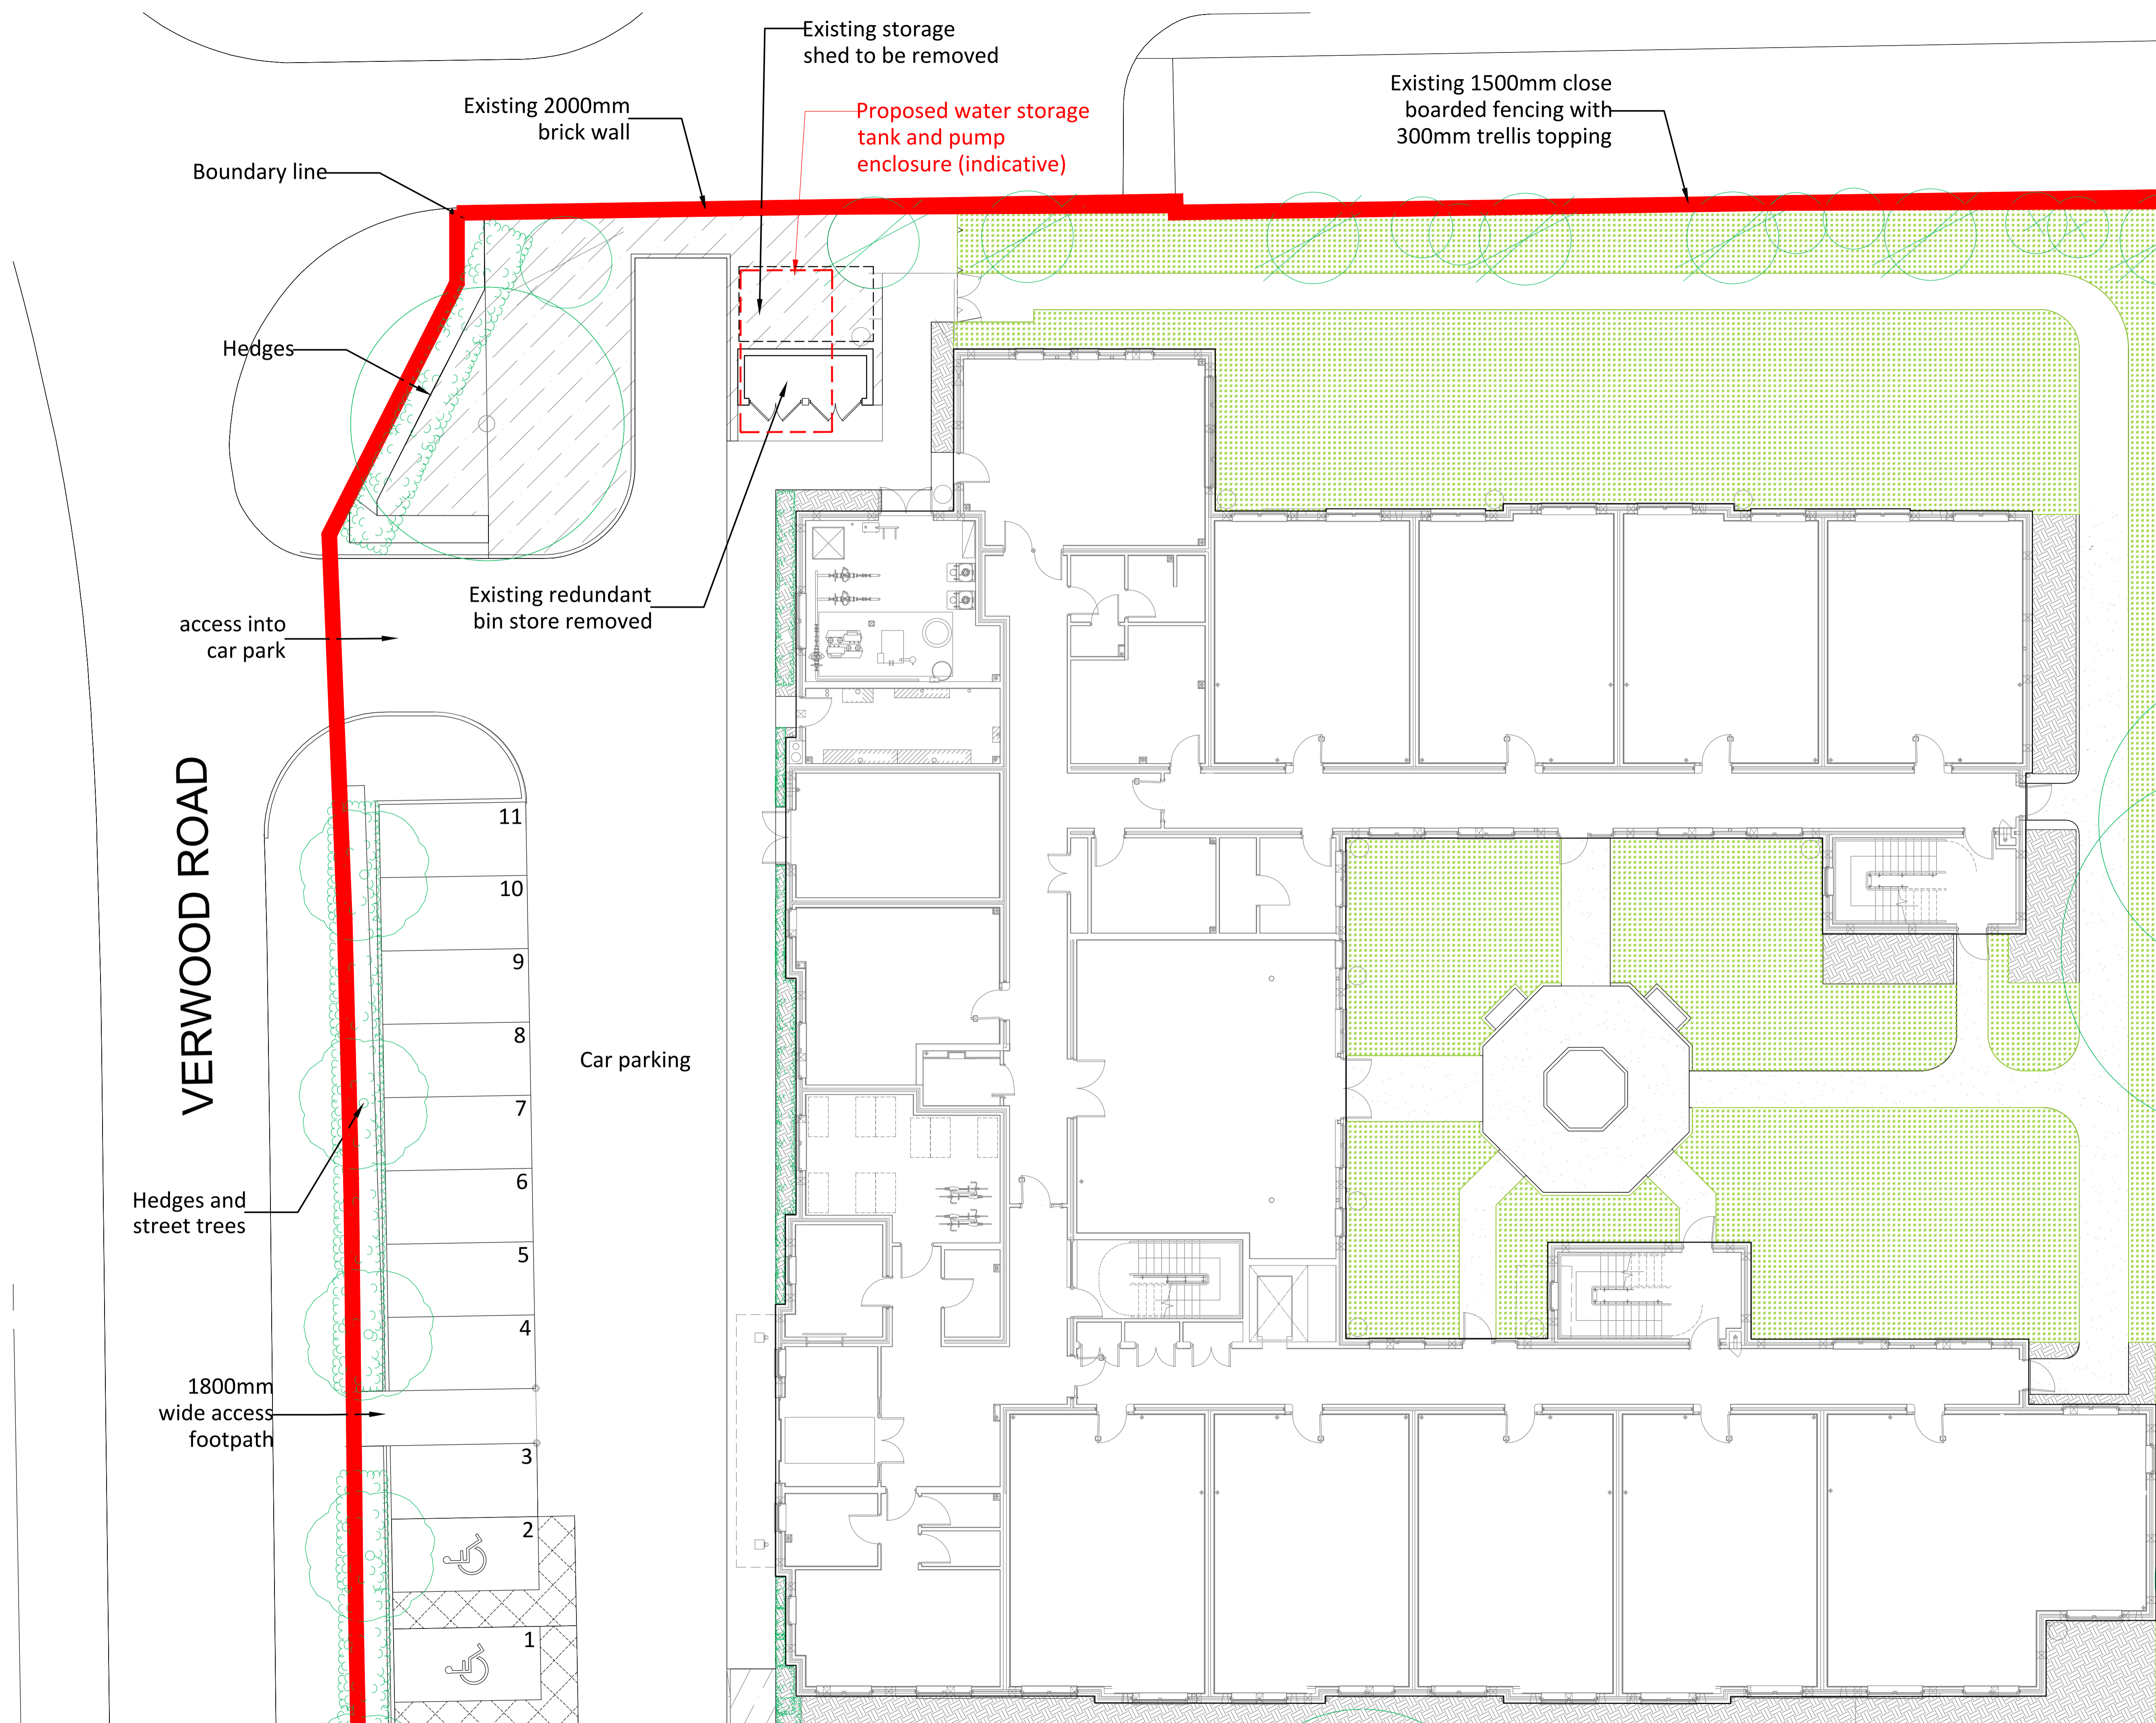

Drawing Status
PLANNING

BROCK CARMICHAEL
 T +44 (0)151 242 6222 F +44 (0)151 236 4467
 E office@brockcarmichael.co.uk www.brockcarmichael.co.uk
 19 Old Hall Street, Liverpool, L3 9JQ

Client Pettit Singleton Associates		Job Title The Elms - Sprinkler Installation	
Drawing Title Site Plan		Drawing Reference 20006d - BCA - XX - XX - DR - A - 02001	
Scale @ A1 1:200	Drawn JKC	Checked SR	Date Feb '21
Status S4	Revision P2	BCA Project Ref 20.0066	