


 
 








ELECTRICAL KEY


-  EXTERNAL WALL LIGHT
-  PENDANT LIGHT FITTING
-  DOUBLE SOCKET OUTLET HIGH LEVEL
-  DOUBLE SOCKET OUTLET LOW LEVEL
-  SINGLE SOCKET OUTLET LOW LEVEL
-  HARD WIRED INTERCONNECTED SMOKE DETECTOR WITH BATTERY BACK UP, 300mm FROM WALLS AND LIGHT FITTINGS
-  COOKER CONTROL UNIT AND LOW LEVEL SPUR
-  PULL CHORD
-  LIGHT SWITCH



Building (Scotland) Act 2003
 note should be made that the relevant person / owner shall be responsible for signing and issuing the completion certificate application to the verifier.
 The relevant person shall also be responsible for the building standards CNP (Construction Notification Plan)

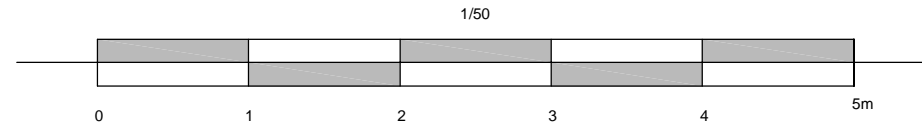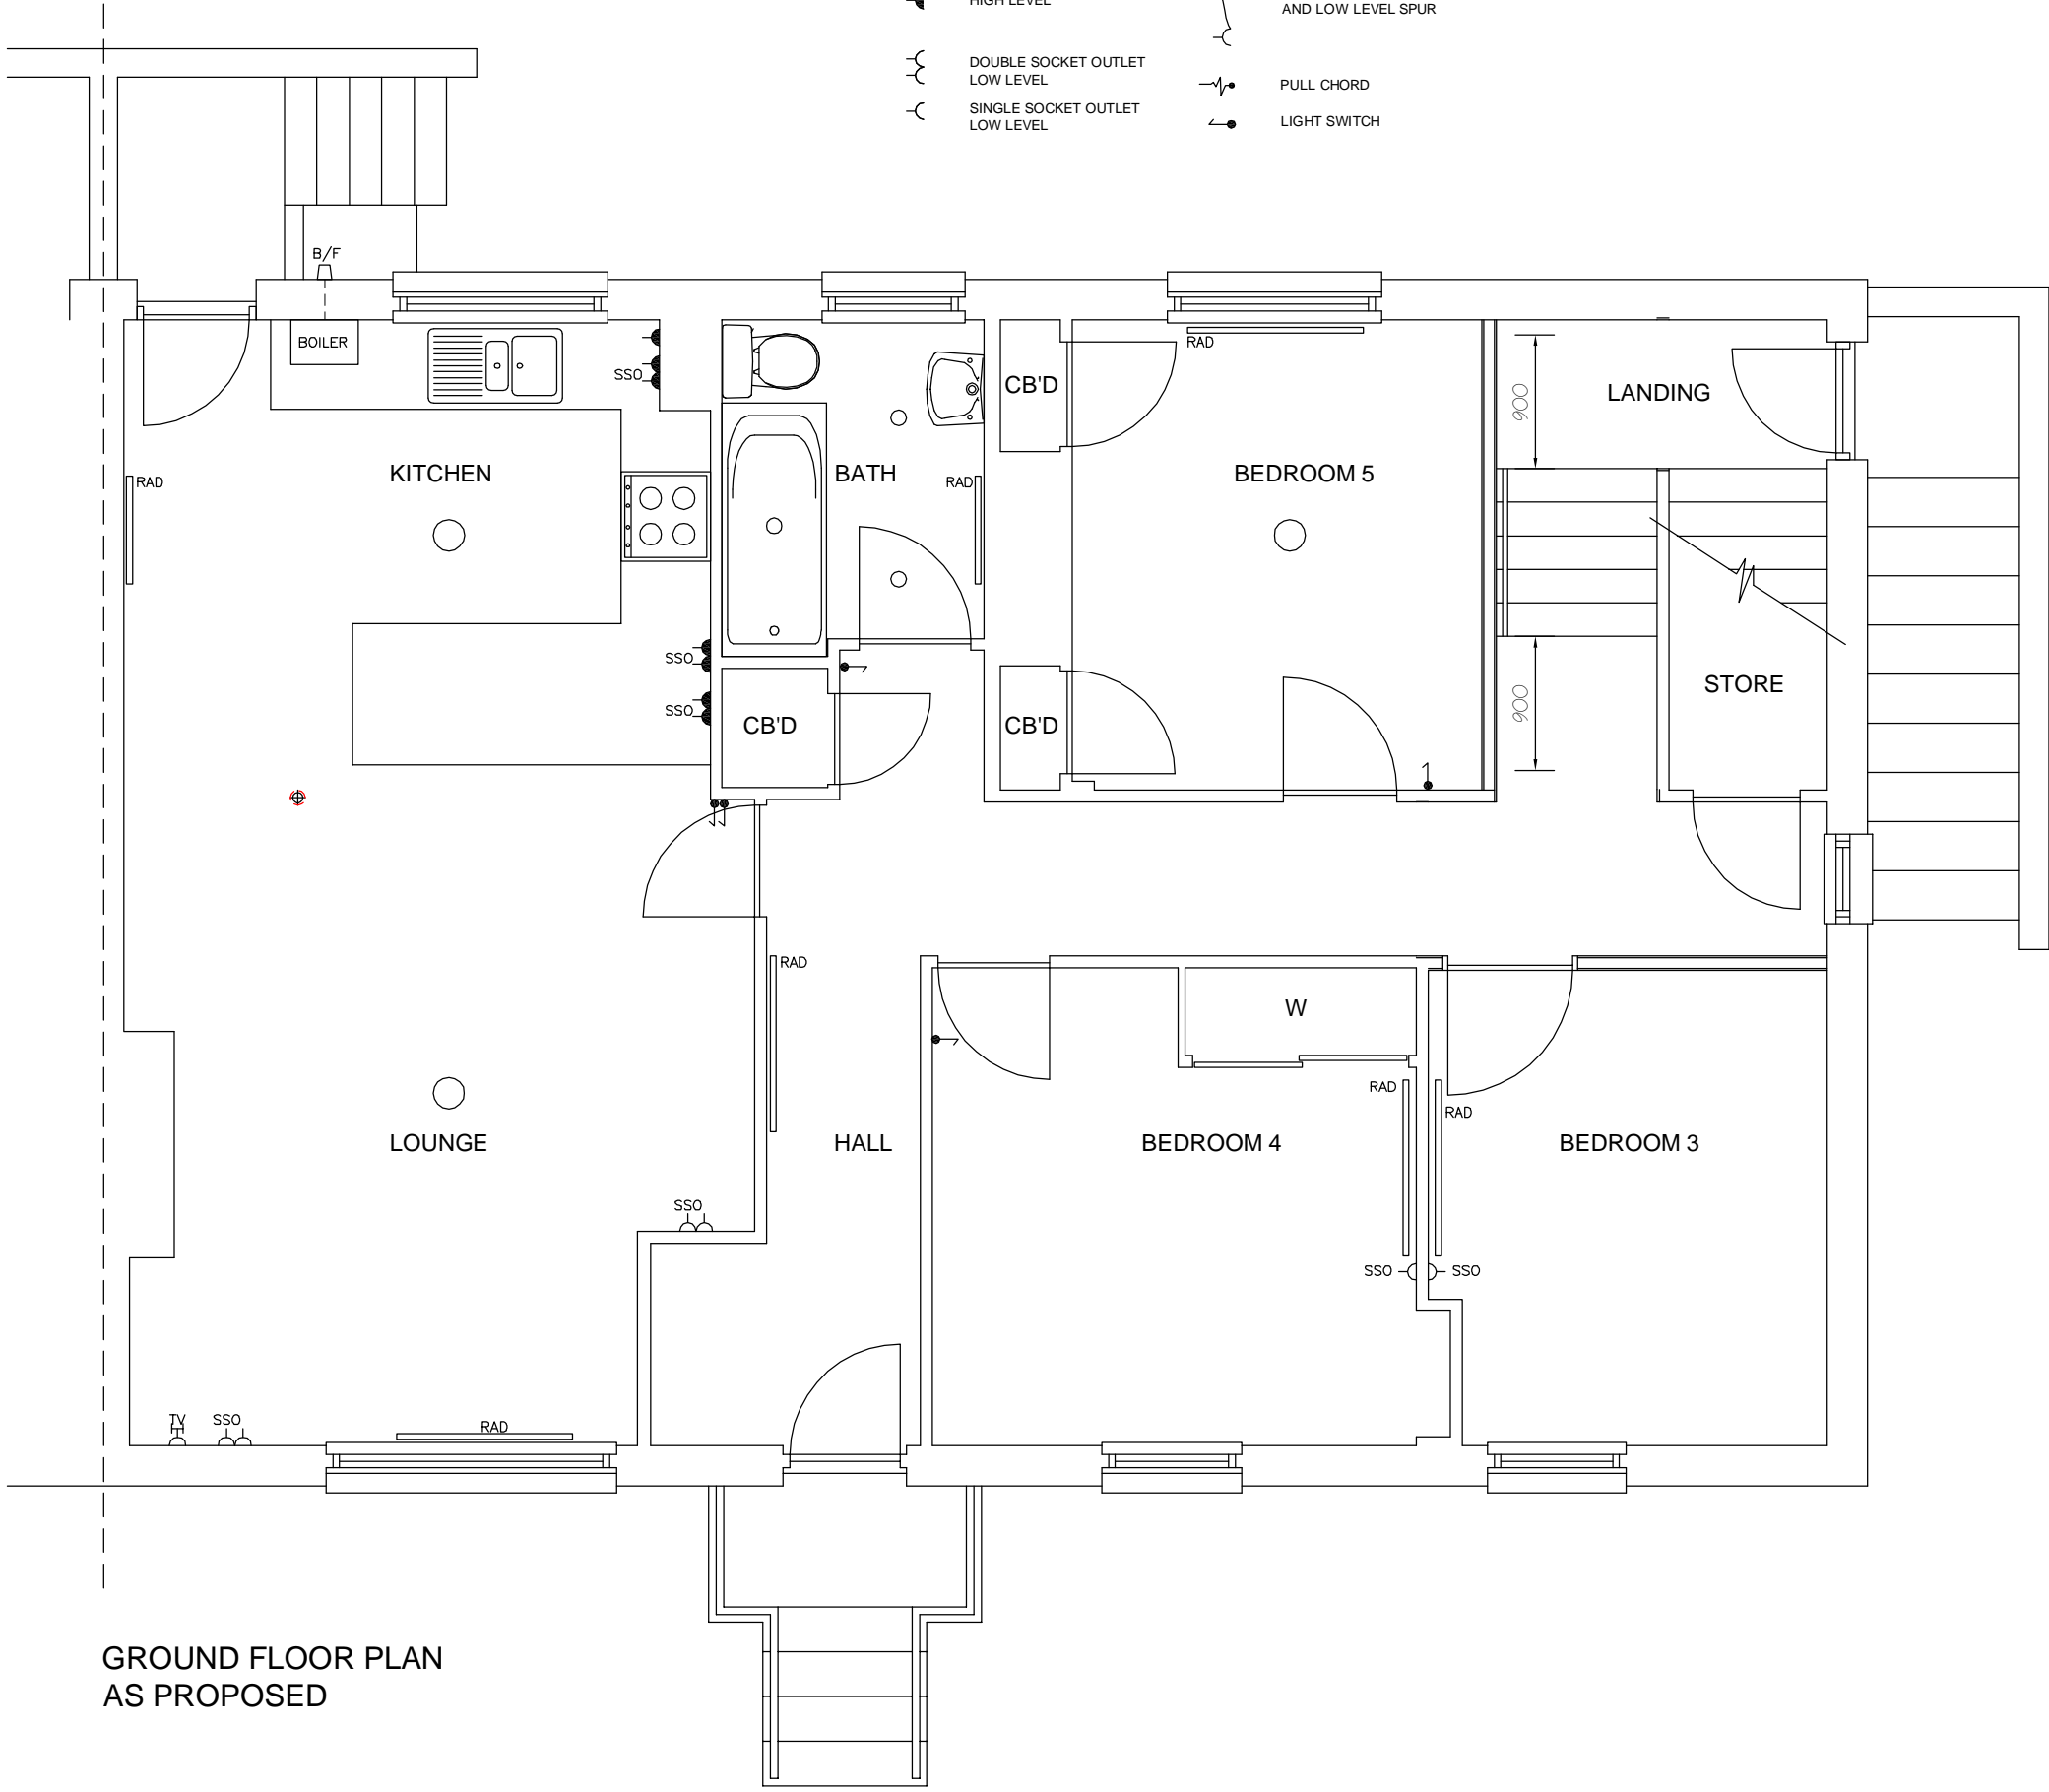

GROUND FLOOR PLAN AS PROPOSED

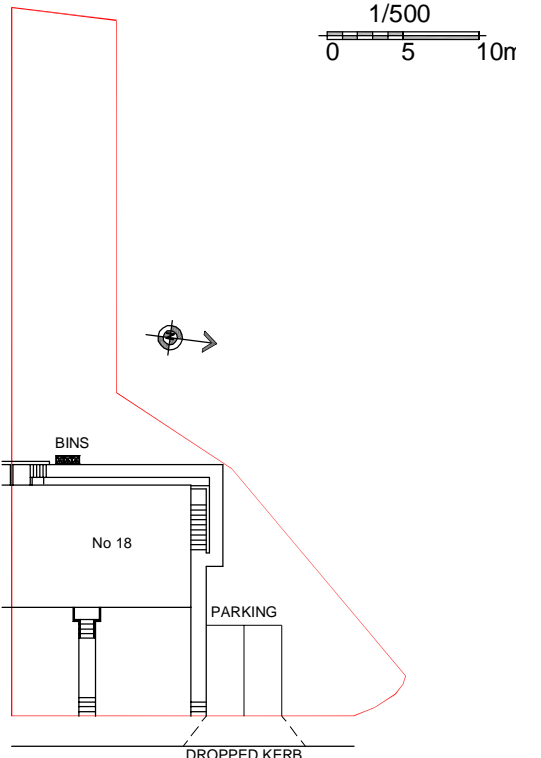

BLOCK PLAN AS PROPOSED

CONTRACTOR TO VERIFY ALL DIMENSIONS ON SITE BEFORE COMMENCING WORK ORDERING MATERIALS.
 ALL ELECTRICAL INSTALLATIONS TO BE TO THE LATEST I.E.T. REGULATIONS
 ELECTRICAL LAYOUT AND INSTALLATIONS TO BE IN ACCORDANCE WITH B.S. 7671: 2018
 ALL GLAZING TO COMPLY WITH BS 6262 : Part 4 : 2018
 ALL DRAINAGE TO COMPLY WITH CURRENT REGULATIONS
 BSEN 752-3 : 1997 (Am2)
 BSEN 752 - 4 : 2008
 BSEN 1610 :1998
 BSEN 12056 - 3 : 2000

A R Peebles

drawforme@hotmail.com

Mrs Chen Li
 18 Fir Park
 Tillicultry

Scale 1:50	Date Apr, 21
Drwg No	ArP - 778 - 03

Architectural Drawing Services
 32 Moss Road, Tillicultry, FK13 6NS
 Tel : 07780556576

As duly appointed agent these drawings were prepared for the purpose of obtaining planning and building warrant approval, and duties as the duly appointed agent are described in the original letter of appointment