


Radiator Details									
Room	Ref.	Height (mm)	length (mm)	Type	Output (W)	Corrected (W)	F & R temp. (°C)	Flow rate (l/s)	
Second floor									
Bed 11	R35	600	1200	K2	1961	1588	70/55	0.025	0.026
Bed 12	R36	600	1200	K2	1961	1588	70/55	0.025	0.026
Bed 13	R37	600	1000	K2	1634	1323	70/55	0.021	0.022
Bed 15	R38	600	1000	K2	1634	1323	70/55	0.021	0.022
Bed 14	R39	600	1600	K2	2614	2117	70/55	0.034	0.035
Bathroom	R40	800/600	760	LST - P+	751	608	70/55	0.010	0.010
Stair well	R41	600	400	K1	364	316.7	70/55	0.005	0.005

ALL RADIATORS SHALL HAVE TRV'S LSV'S AND AIR VENTS.
 ALL RADIATORS ARE SIZED BASED ON STELRAD PLANNAR RADIATORS

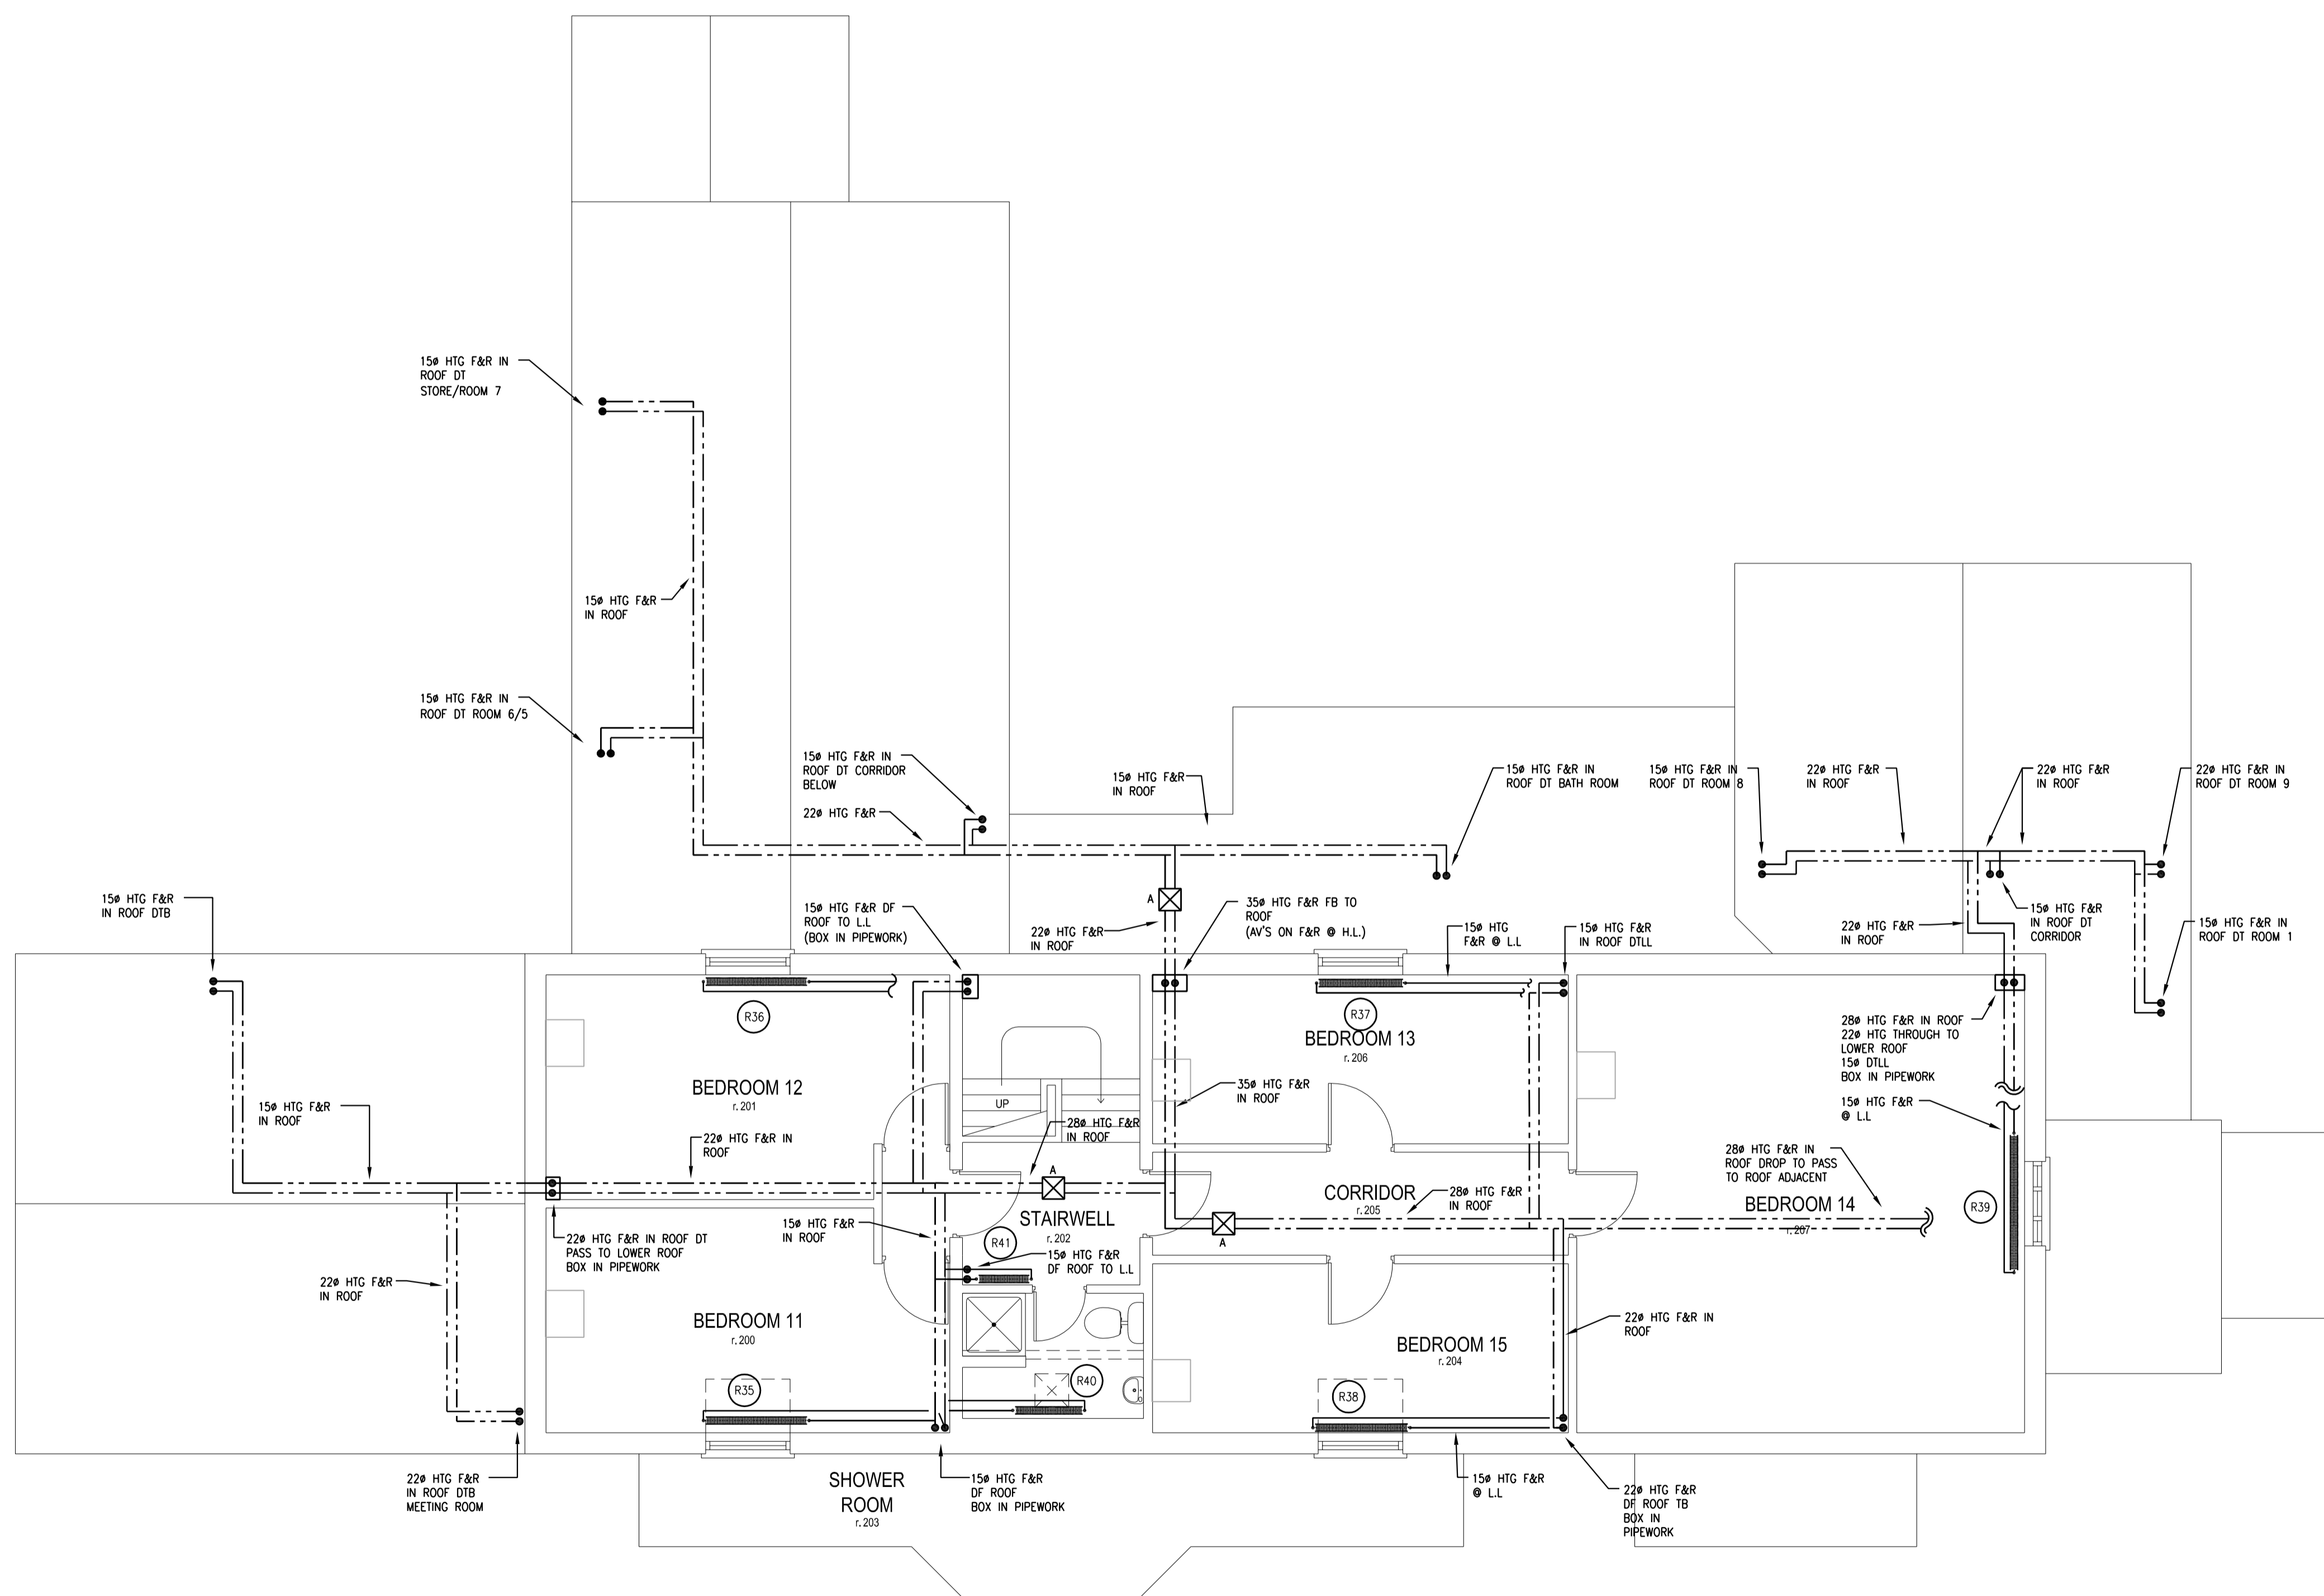

SECOND FLOOR @ 1:50

No.	Revision/Issue	Date

SJ Treloar and Associates

Unit 7
 North Leigh Business Park
 North Leigh
 Oxfordshire
 OX29 6SW

Tel: 01993 883510
 Fax: 01993 883439
 www.sjtreloarandassociates.co.uk
 enquiry@sjtreloarandassociates.co.uk

Project
**BOX TREE COTTAGE
 110 ALLERTON ROAD
 MAJOR REPAIRS**

Client
LANGLEY HOUSING TRUST

Drawing No.	Revision
10543/102	
SECOND FLOOR HEATING LAYOUT	
Date 26/05/11	Checked SD
Scale 1:50	Drawn by AE