


New connection
 Connection – 8" SI LP
 Lay – 32mm PE LP
 Public – 2m
 Private – 0m
 Terminate – Cellar Entry

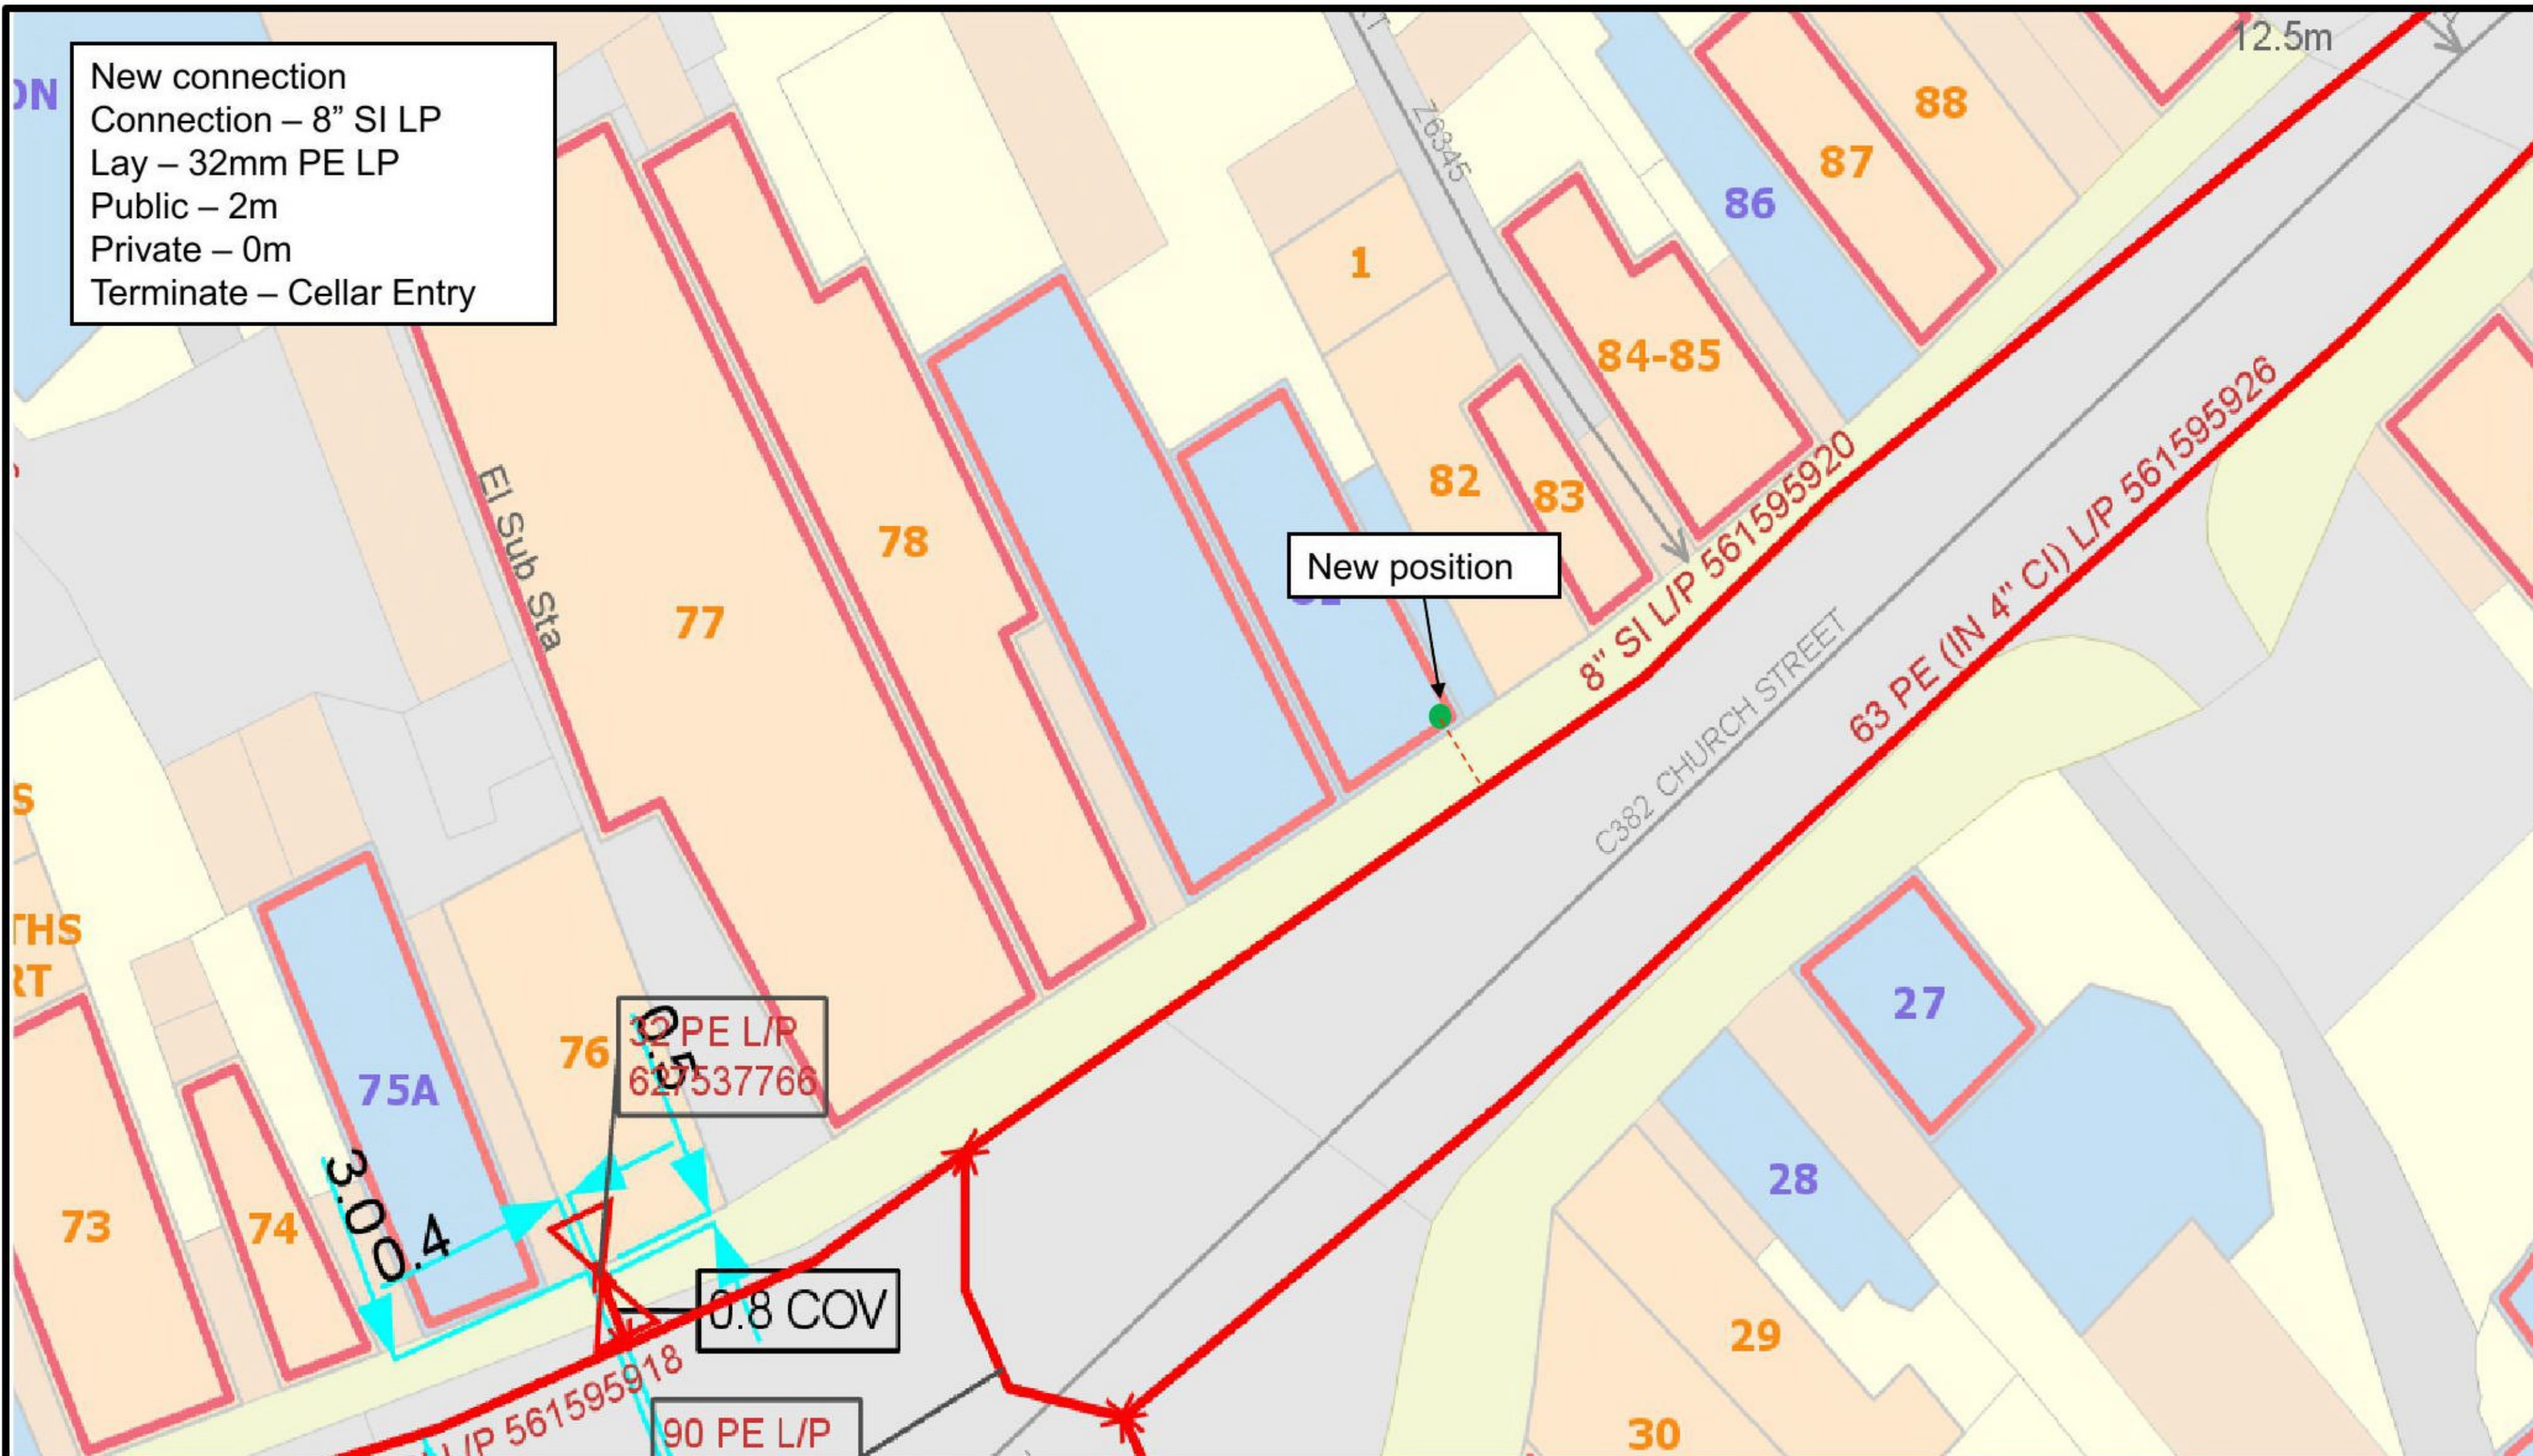

Reproduced by permission of Ordnance Survey on behalf of HMSO.
 © Crown Copyright and database right 2018. All rights reserved.
 Ordnance Survey Licence number 0100044308.

The plan shows those pipes owned by Wales & West Utilities or the relevant Gas Distribution Network in their roles as Licenced Gas Transporters (GT). Gas Pipes owned by other GTs, or otherwise privately owned, may be present in this area. Information with regard to such pipes should be obtained from the relevant owners. The information shown on this plan is given without warranty, the accuracy thereof cannot be guaranteed. Service pipes, valves, syphons, stub connections, etc. are not shown but their presence should be anticipated. No liability of any kind whatsoever is accepted by Wales & West Utilities, the relevant Gas Distribution Network, or their agents, servants or contractors for any error or omission. Safe digging practices, in accordance with HS(G)47, must be used to verify and establish the actual position of mains, pipes, services and other apparatus on site and before any mechanical plant is used. It is your responsibility to ensure that this information is provided to all persons (either direct labour or contractors) working for you or near gas apparatus. The information included on this plan should not be referred to beyond a period of 28 days from the date of issue.

- Low Pressure (LP) 21mbar – 75mbar
- - - Medium Pressure (MP) 350mbar – 2bar
- - - Intermediate Pressure (IP) 2bar – 7bar
- - - High Pressure (HP) >7bar
- Line/Fire Valve
- Governor Station
- Change of Diameter
- End Cap

Document Version: CONN_LF_WW_233

46153508 – 81 Church Street, Tewkesbury, GL50 5RX

Date: 09.02.2021

Number: 02920 278567

Drawing Number: One of One

Grid Reference: E 389156
 N 232579

Dial
 before
 you dig

We need
 10 days'
 notice

Smell gas?
 Call the Gas Emergency Service on
 0800 111 999.

Dial
 Call 029 2027 8912
 before you start work.

Investigate
 Before you dig, make sure
 you know what's below.

Go ahead
 Done your research?
 Now you can dig safely.