
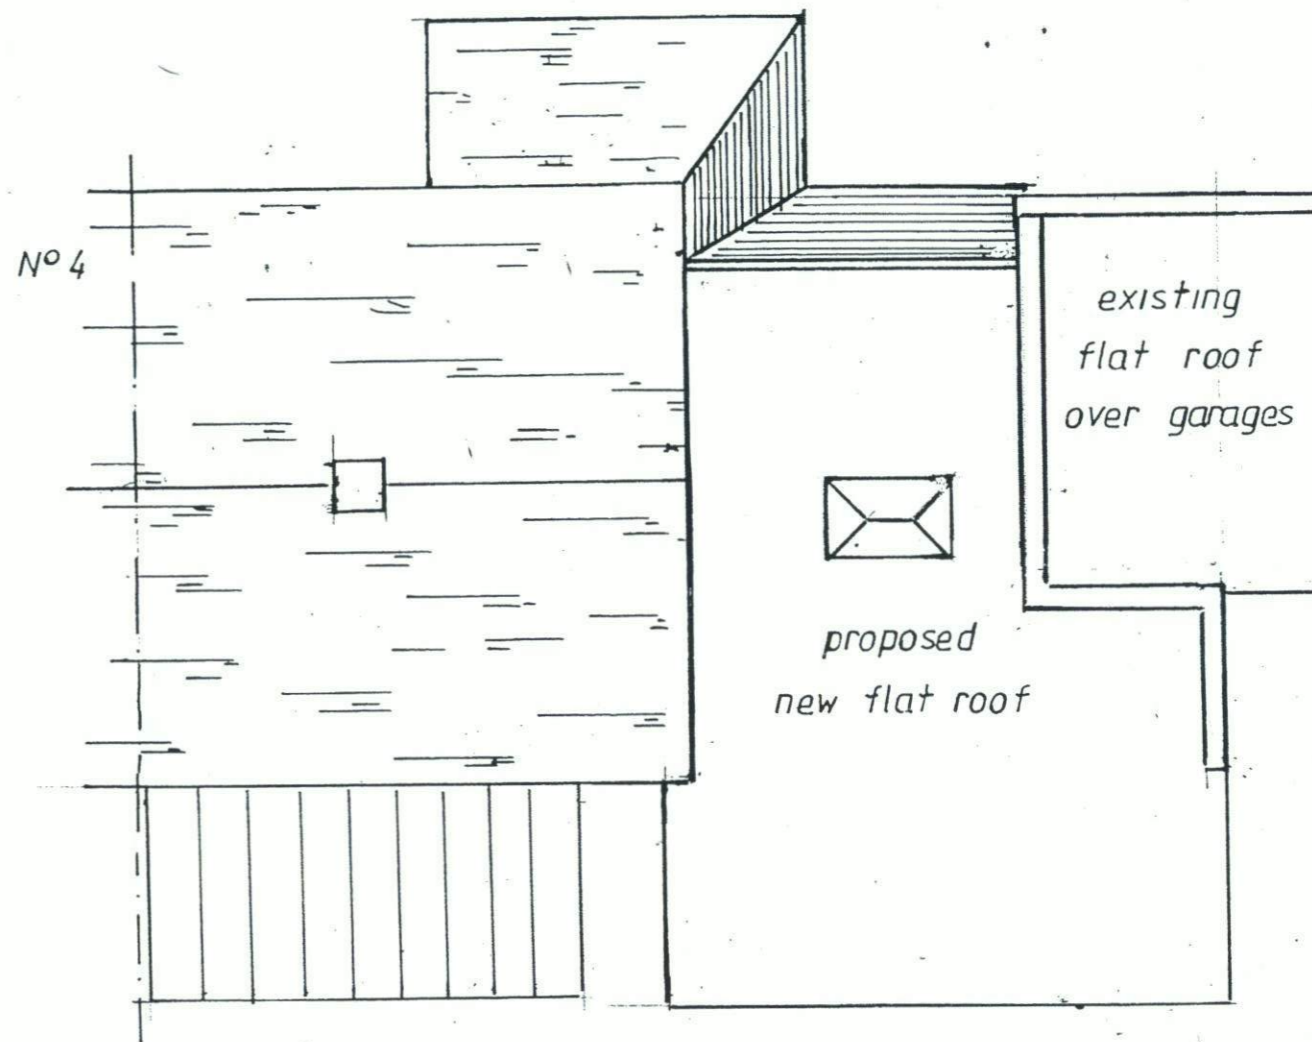


GROUND FLOOR

ROOF PLAN

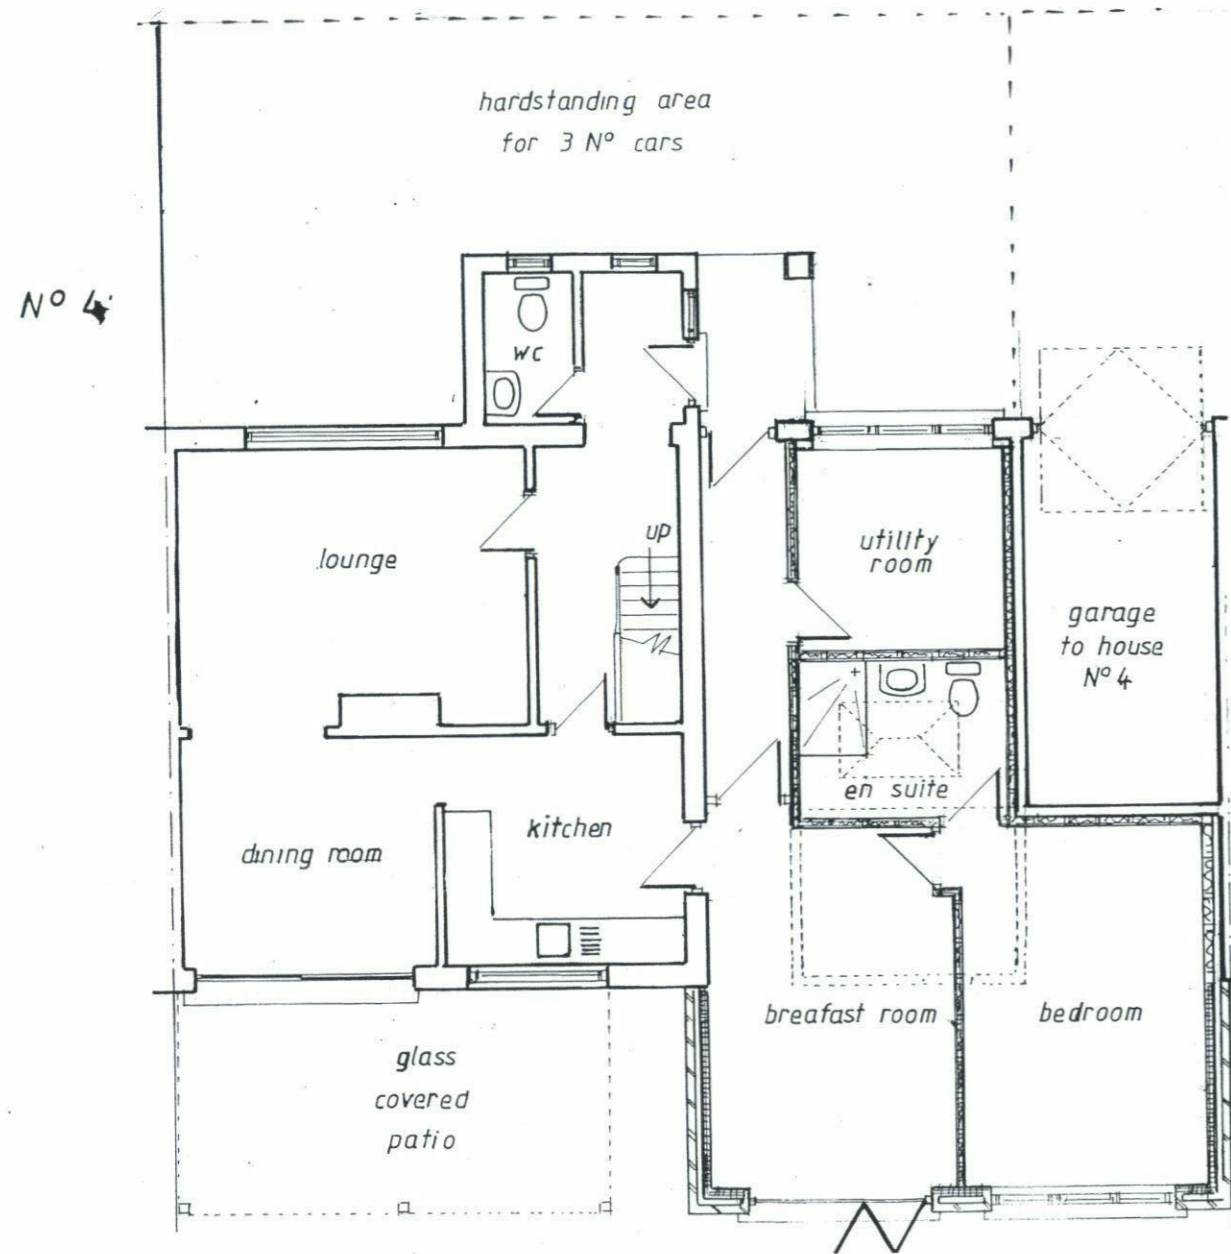

0 1 2 3 4 5 6 7 8m

SCALE BAR 1:100

VIADUCT SURVEYING SERVICES
40 MANOR COURT ROAD
HANWELL
LONDON W7 3EL
TELEPHONE: 0208 579 3098 MOBILE: 07850 280262

Revisions:

Job Title:
3, WILLBERFORCE WAY, BRACKNELL, RG12 9PN

Drawing Title:
PLANS " AS PROPOSED "

Scale: 1:100
Date: MARCH 2021
Drawn: DRS.

BKL 21036/3