



Proposed Ground Floor Plan  
(scale 1:100)

- Electrical Legend**  
Refer to separate specification for fixing heights
- ceiling-mounted heat detector
  - ceiling-mounted smoke detector/alarm
  - ceiling-mounted CO detector/alarm
  - ceiling-mounted light fitting
  - recessed ceiling downlight
  - wall-mounted light fitting
  - ceiling-mounted extract fan
  - through-wall extract fan
  - board for consumer unit & electric meter
  - appliance control unit
  - bell push
  - door chime
  - low-level double socket
  - high-level double socket
  - low-level single socket
  - high-level single socket
  - low-level telecom socket
  - high-level telecom socket
  - low-level flex outlet
  - high-level flex outlet
  - low-level TV aerial socket
  - high-level TV aerial socket
  - single-gang switch
  - double-gang switch
  - three-gang switch
  - wall-mounted thermostat
  - wall-mounted alarm control unit

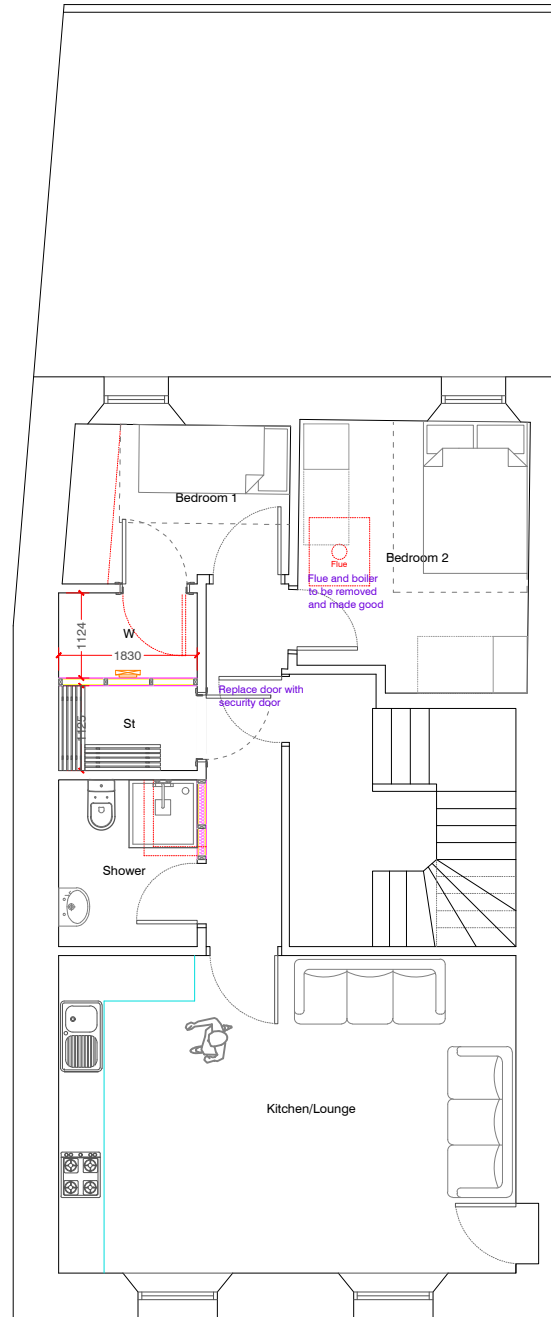

Proposed First Floor Plan  
(scale 1:100)

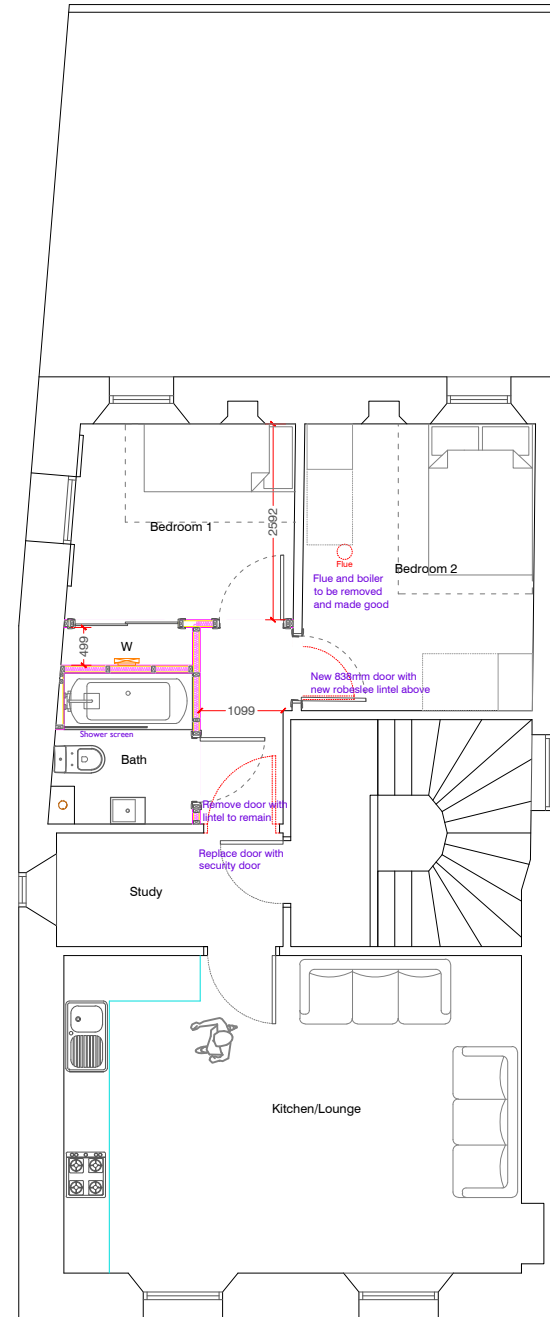

Proposed Second Floor Plan  
(scale 1:100)

Copyright in this design is reserved to Mclelland Architectural Design. These drawings are for solely Planning or Warrant purposes only. All dimensions should be checked by Contractor before commencing work.

**PROJECT / CLIENT:**  
Mr Michael Morris  
63 High Street  
Leven  
KY8 4NF

**DRAWING:**  
Proposed Floor Plans

Drawn by: js	Checked by: mm	Date: 07/01/2021	Scales: 1:100
-----------------	-------------------	---------------------	------------------

Site Code: 99	Job Code: 00	Drawing No.: 002	Revision: -
------------------	-----------------	---------------------	----------------



Mclelland Architectural Design  
&  
Build Ltd

3 Haig Place  
Windygates  
KY8 5EE

OFFICE: 01333 302585  
MOB: 07920 770177