

THIS DRAWING IS FOR INFORMATION ONLY DO NOT SCALE

CDM REGULATIONS			
NAME	DATE	DATE	DATE
ISSUED	REVISED	REVISED	REVISED


DRAWING SUITABILITY CODES:

- S0- WORK IN PROGRESS
- S1- SUITABLE FOR COORDINATION
- S2- SUITABLE FOR INFORMATION
- S3- SUITABLE FOR REVIEW & COMMENT
- S4- SUITABLE FOR STAGE APPROVAL
- S5- SUITABLE FOR PERMITS AUTHORIZATION
- S6- SUITABLE FOR AM AUTHORIZATION
- S7- SUITABLE FOR COSTING
- S8- SUITABLE FOR TENDER
- S9- SUITABLE FOR CONTRACTOR DESIGN
- S10- SUITABLE FOR MANUFACTURE / PROCUREMENT

- NOTES:**
- THIS DRAWING IS TO BE READ IN CONJUNCTION WITH THE M&E SPECIFICATION AND ALL LATEST ARCHITECTS AND ENGINEERS DRAWINGS
 - THIS DRAWING IS INDICATIVE ONLY AND SUBJECT TO DETAILED DESIGN.

LEGEND:

	TELECOMS
	LV MAINS
	WATER MAIN
	GAS MAIN (40mm)
	HV DUCT
	FIRE MAIN
	CAT 5 WATER
	LPHW HEATING
	CABLE DUCT
	SITE BOUNDARY
	FIRE HYDRANT
	DRAWFIT
	EXISTING HYDRANT

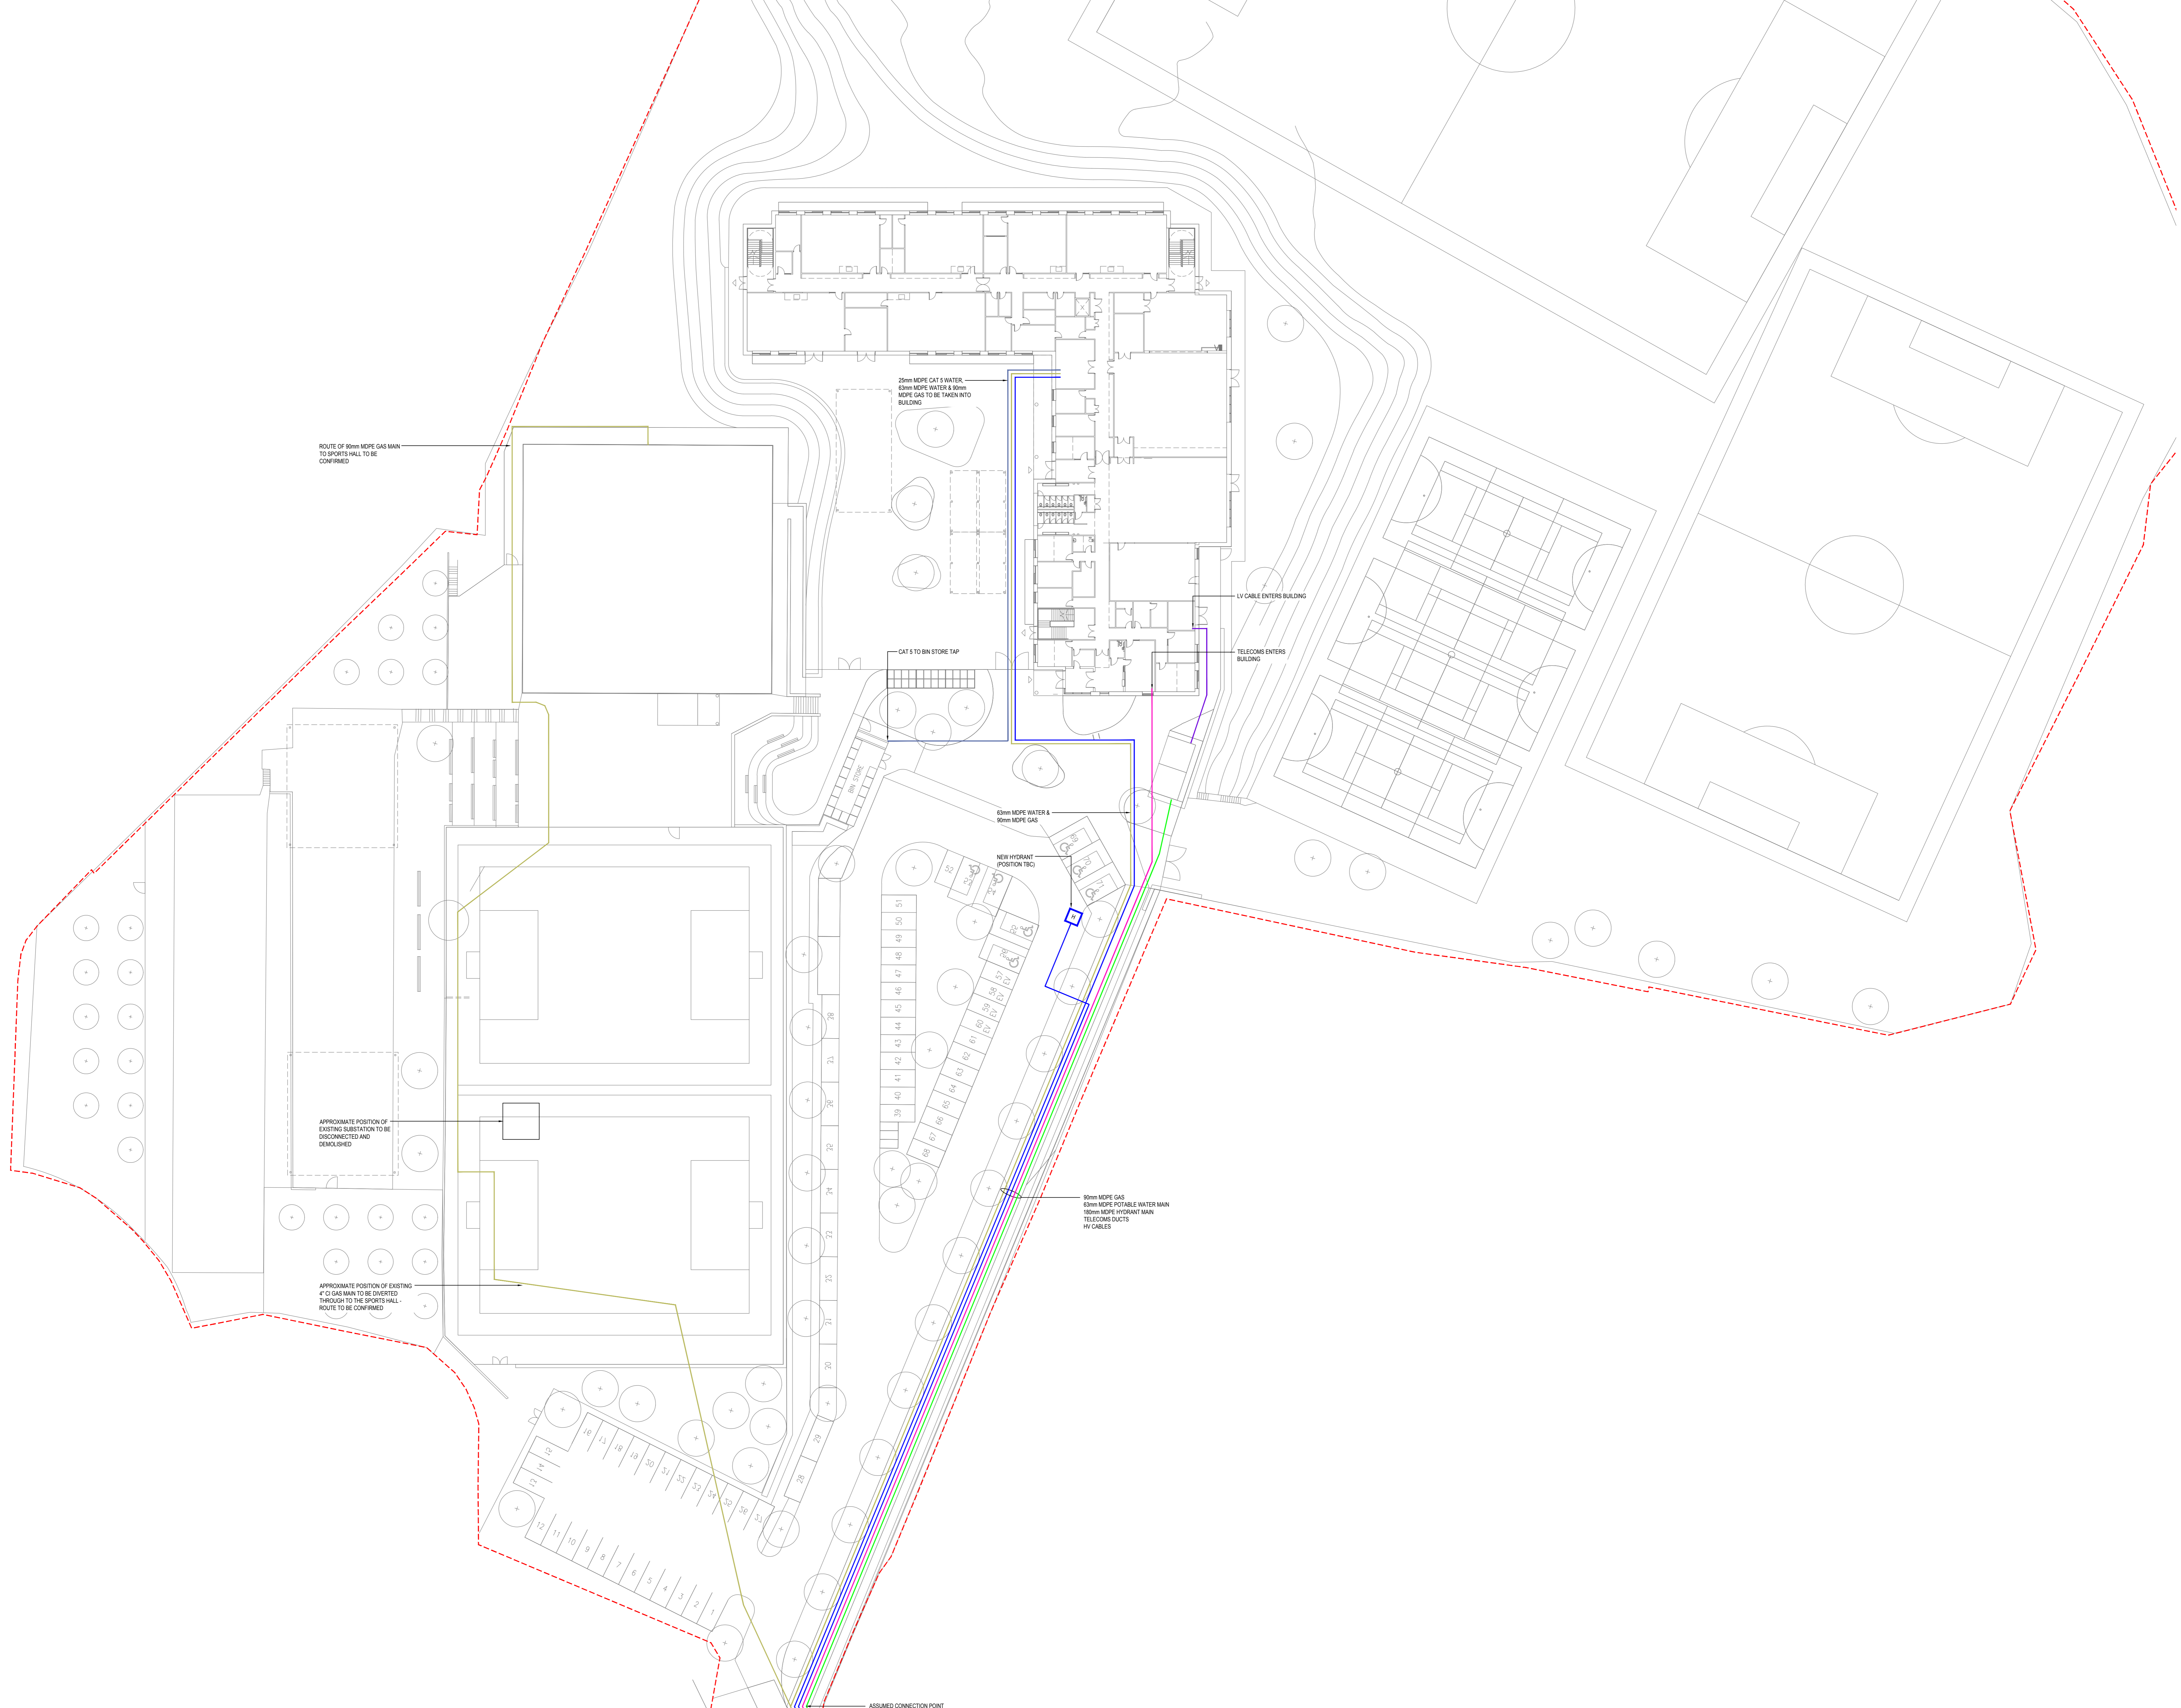

CP1	28.04.21	SITE PLAN UPDATED	KAS	SH
CP2	18.05.21	ISSUED FOR CONTRACTORS PROPOSALS	KAS	SH
REV	DATE	DESCRIPTION	BY	CHK

CONTRACTORS PROPOSALS

Commercial Services Design Ltd
 Unit 2
 Woodside Court
 Claxton Wood Road
 L516 0BP
 Tel: 0112 3221199
 Web: www.csdesign.co.uk




CLIENT: WATES CONSTRUCTION
PROJECT: WHITWORTH COMMUNITY HIGH SCHOOL LANCASHIRE
TITLE: MECHANICAL & ELECTRICAL SERVICES PROPOSED EXTERNAL SERVICES LAYOUT

REF: 1201-CSD-EX-XX-DR-ME-10001
5.4.5 (vii), 5.4.6 (ii), 5.4.6 (iii)

STATUS	S3 - SUITABLE FOR REVIEW & COMMENT
DATE	DATE
ISSUED	ISSUED
APPROVED	APPROVED

1201-CSD-EX-XX-DR-ME-10001 CP2
 Project Originator: Wates Construction Type: Discipline Classification Number

ARCHITECTURE IS BASED ON SHEPHERD ROSSON DRAWING No. W04S-08A-XX-00-DR-A-20100
 GENERAL ARRANGEMENT: GROUND FLOOR PLAN REV POB
 REVISION: 16.03.2021

ARCHITECTURE IS BASED ON ARRS LANDSCAPE DRAWING No. W04-A-08A-XX-02-1-001
 LANDSCAPE ILLUSTRATIVE MASTERPLAN REV POS
 REVISION: 27.04.2021