


PROPOSED GROUND FLOOR PLAN 1:50

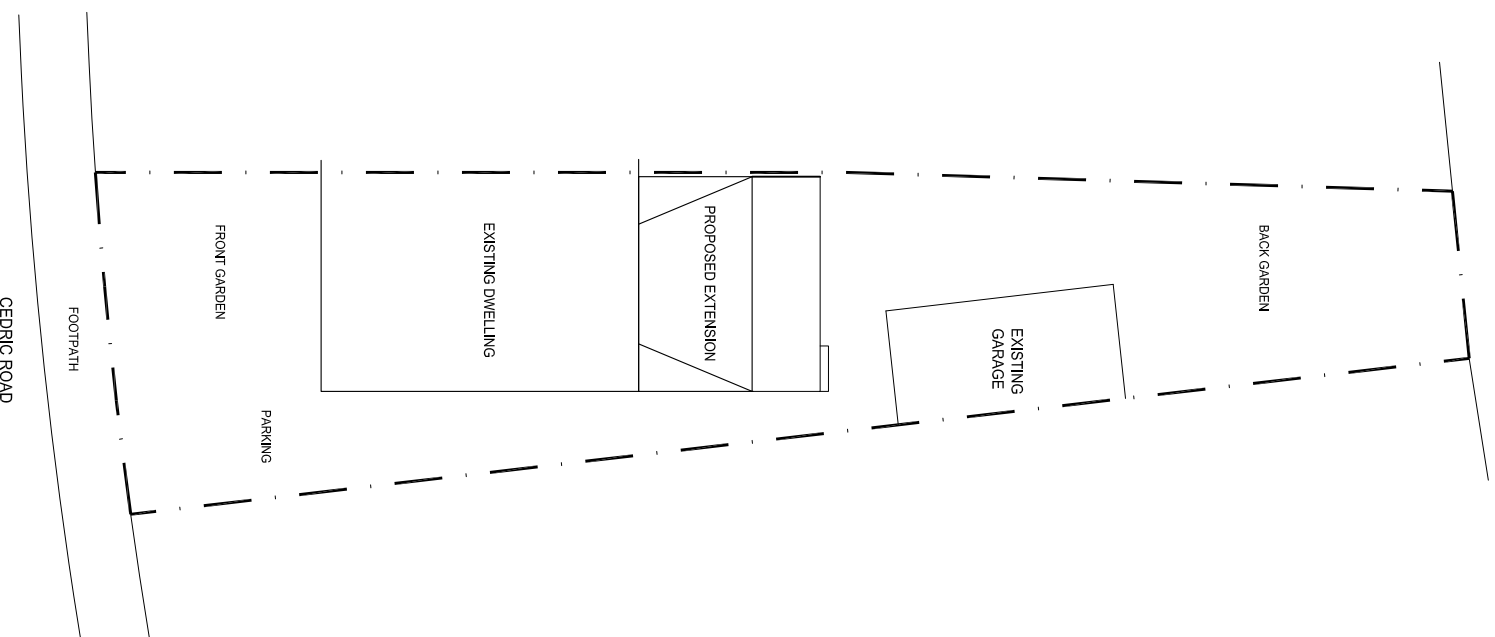

BLOCK PLAN 1:200

ELECTRICAL LEGEND	
	PENDANT CEILING MOUNTED LIGHT FITTING
	RECESSED SPOTLIGHT
	LIGHT SWITCH
	TWO WAY LIGHT SWITCH
	CEILING MOUNTED SMOKE DETECTOR
	CEILING MOUNTED HEAT DETECTOR
	DOUBLE SWITCHED SOCKET OUTLET
	SINGLE SWITCHED SOCKET OUTLET
	SPUR OUTLET
	CEILING MOUNTED EXTRACT FAN
	EXTERNAL WALL MOUNTED EXTRACT FAN
	30 AMP COOKER CONTROL FEED
	COOKER HOOD POWER

Client
MR & MRS CHISHOLM

Job Title
42 CEDRIC ROAD
KNIGHTSWOOD
GLASGOW
G13 2ED

Job Title
DOMESTIC EXTENSION

Drawing
**PROPOSED PLAN
BLOCK PLAN**

Scale
1:50 / 1:200

Date
MARCH 2021

DRG No.
MJB/PWE/006/2021 2

PES