


**129 & 131 HIGH STREET
ROOF PLAN**

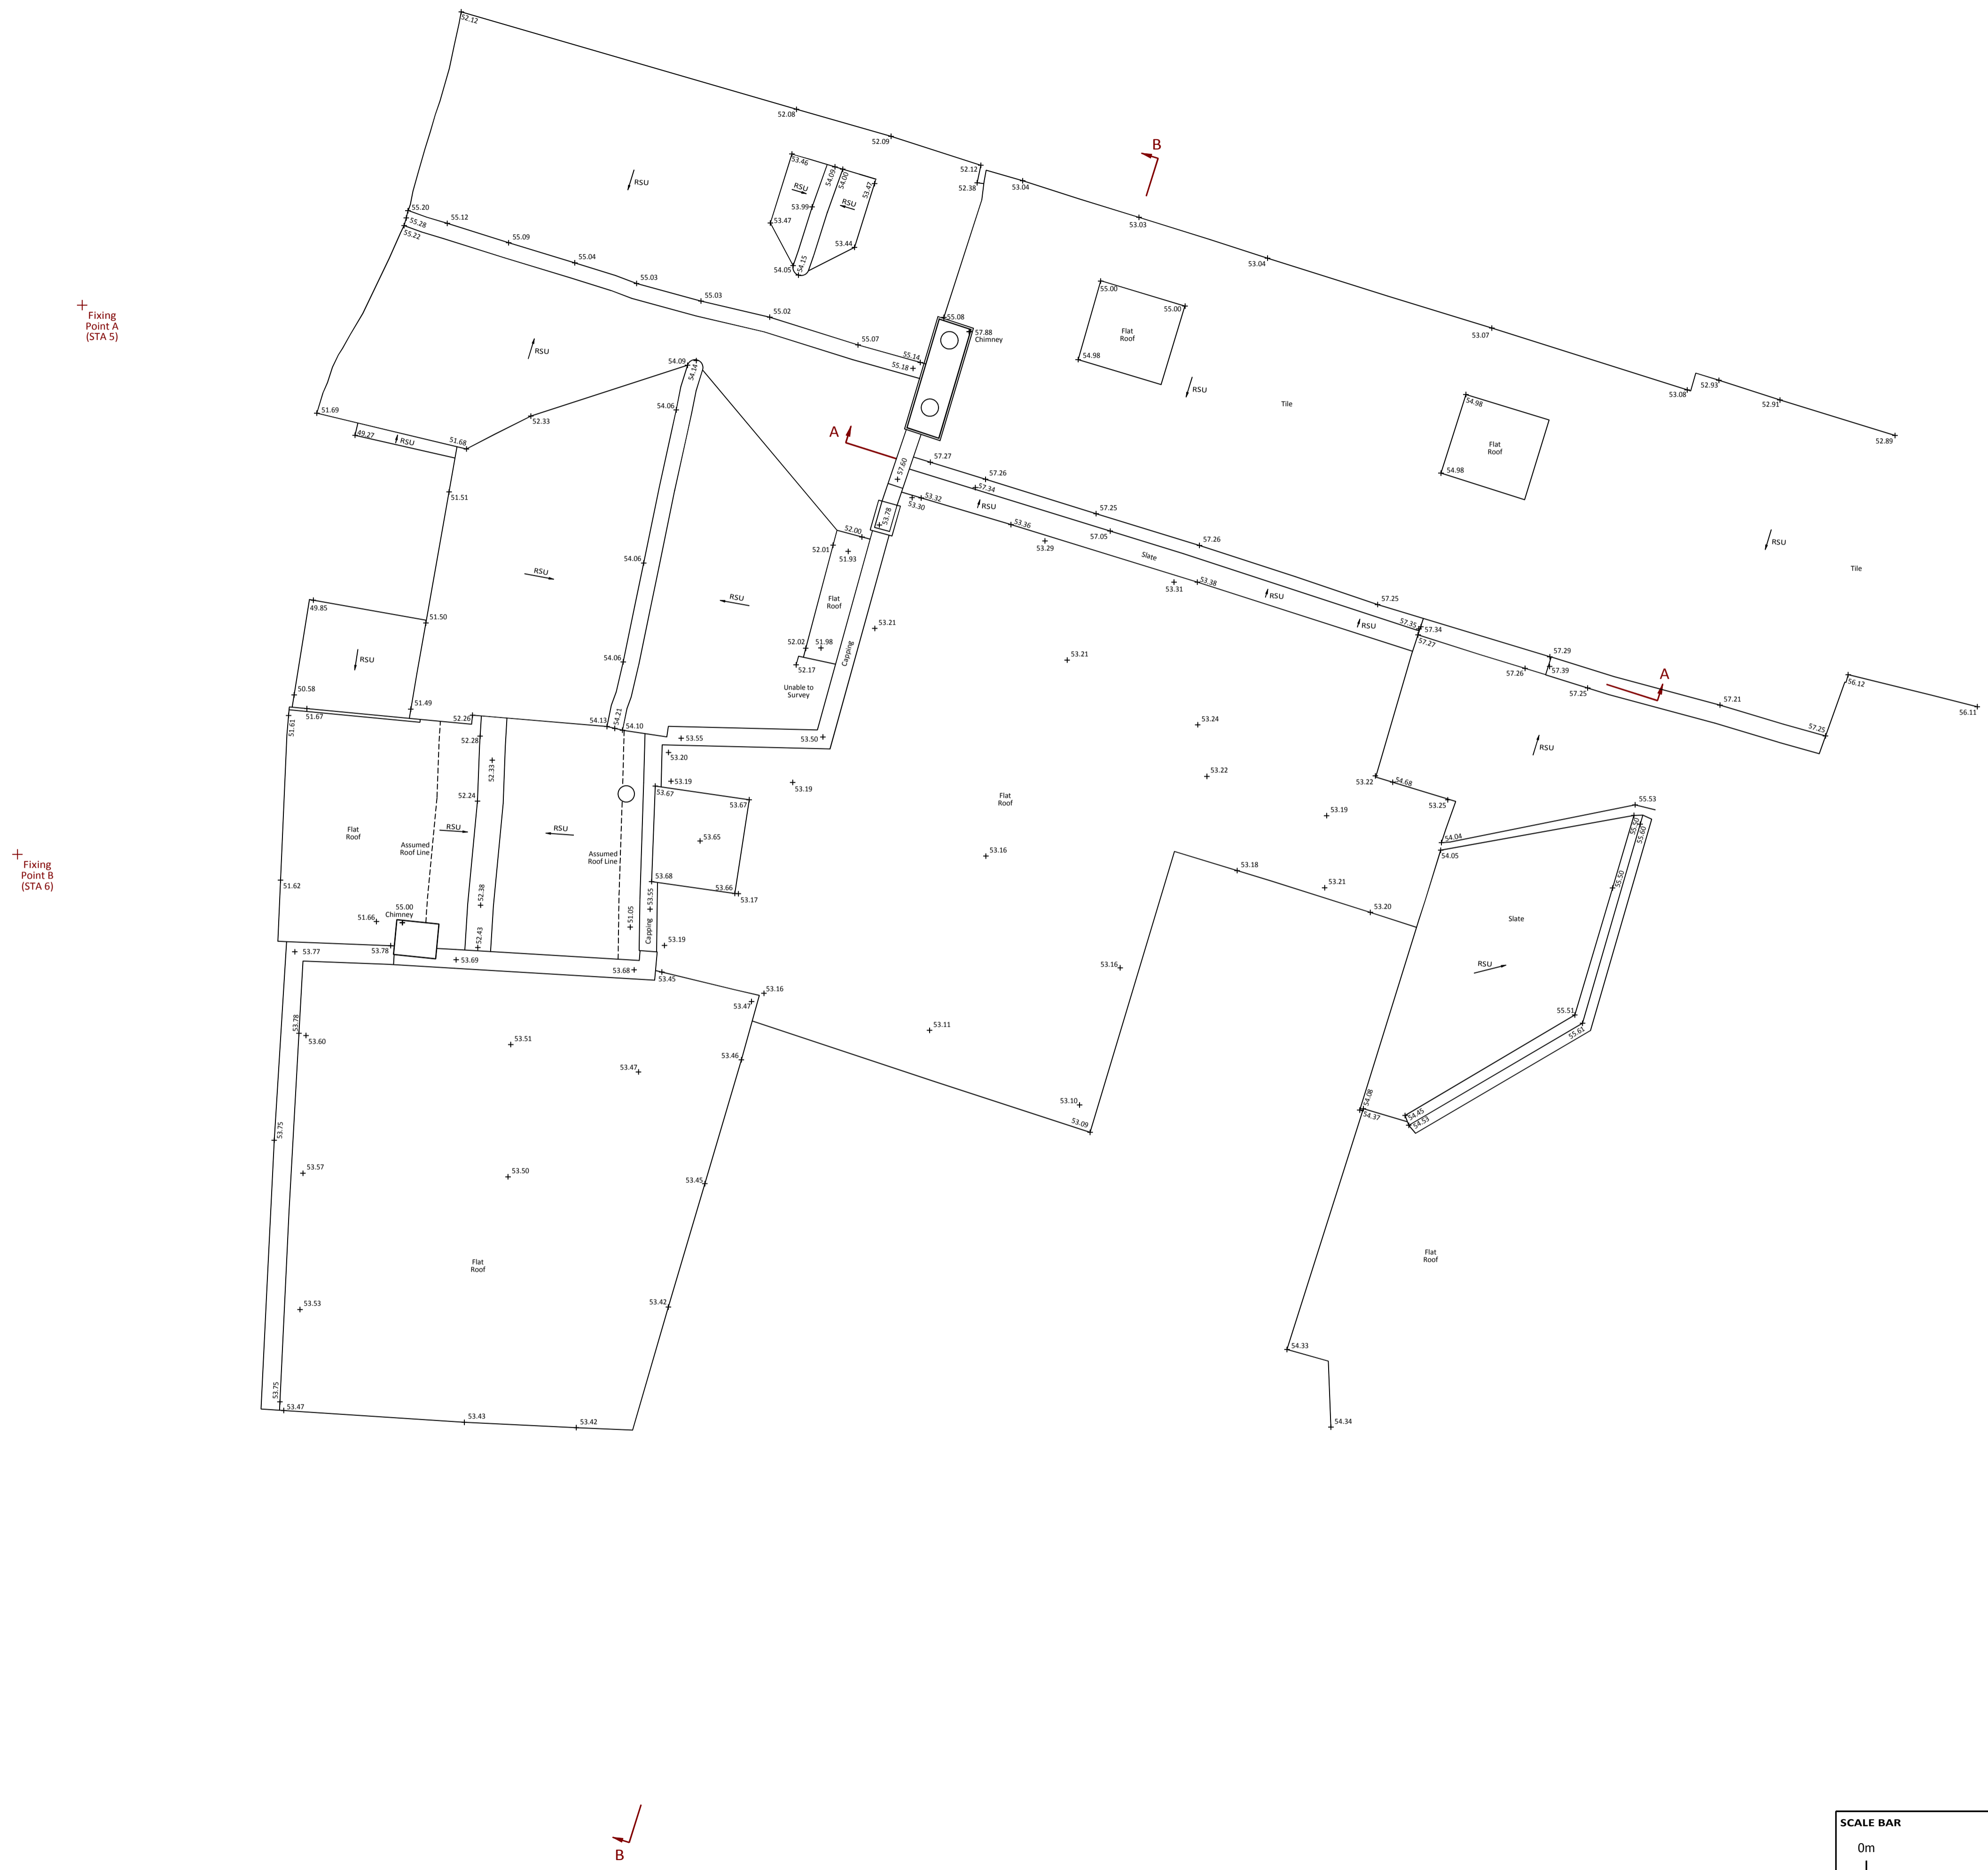

NOTES

- LEVELS ARE RELATED TO ORDNANCE SURVEY BY GPS OBSERVATION.
- SURVEY HAS BEEN CARRIED OUT TO AN ACCURACY COMMENSURATE WITH A 1:50 SCALE DRAWING.

ABBREVIATION LIST

AC	AIR CONDITIONING VENTS OR EQUIPMENT
BSP	BEAM SPRING LEVEL
BSU	BEAM SLOPES UP
CSP	CEILING SPRING LEVEL
CSU	CEILING SLOPES UP
DP	DOUBLE PLUG
ELS	EMERGENCY LIGHT SWITCH
EP	ELECTRIC POINT
ESM	ELECTRIC SWITCH MACHINE
FA	FIRE ALARM
FL	FLOOR LEVEL
FS	FUSED ELECTRIC SWITCH
JB	JUNCTION BOX
L	LIGHT
LCB	LIFT CALL BUTTON
LS	LIGHT SWITCH
SP	SINGLE PLUG
TOB	TOP OF BOXING
TOW	TOP OF WALL
WL	WALL LIGHT
s 1.00	SILL LEVEL
h 1.00	HEAD LEVEL
usa 1.00	LEVEL OF UNDERSIDE OF ARCH
usb 1.00	LEVEL OF UNDERSIDE OF BEAM
usd 1.00	LEVEL OF UNDERSIDE OF DUCTING
usp 1.00	LEVEL OF UNDERSIDE OF PIPE
us 1.00	UNDERSIDE LEVEL
(SOLID)	SOLID CEILING LEVEL
(FALSE)	FALSE CEILING LEVEL

NO.	DATE	DETAILS

REVISIONS

74 WATCHET LANE
HOLMER GREEN
HIGH WYCOMBE
BUCKINGHAMSHIRE
HP15 6UG

Tel: 01494 718453
Fax: 01494 717576
e-mail: enquiry@kndsveys.com

CLIENT


CHEES ARCHITECTURE & DEVELOPMENT LTD
PIA HOUSE
4 NORFOLK COURT
NORFOLK ROAD
RICKMANSWORTH
HERTS
WD3 1LA

JOB TITLE

129 & 131 HIGH STREET
RICKMANSWORTH
WD3 1AN

DRAWING TITLE

ROOF PLAN

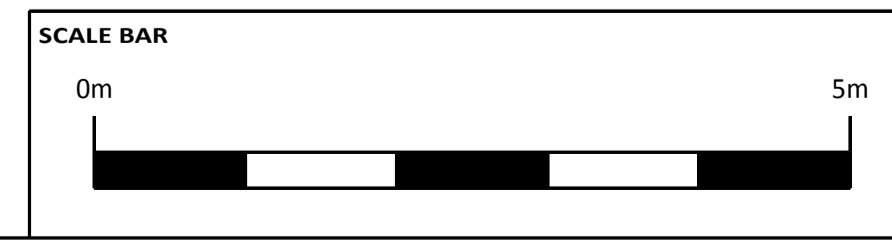

DRAWING No. F0918 - R	DRAWN BY MTP	DATE 11 JUN 2018
SURVEYED BY MTP		SCALE 1:50 A1 Sheet