
 


**Proposed Ground floor**  
1 : 100

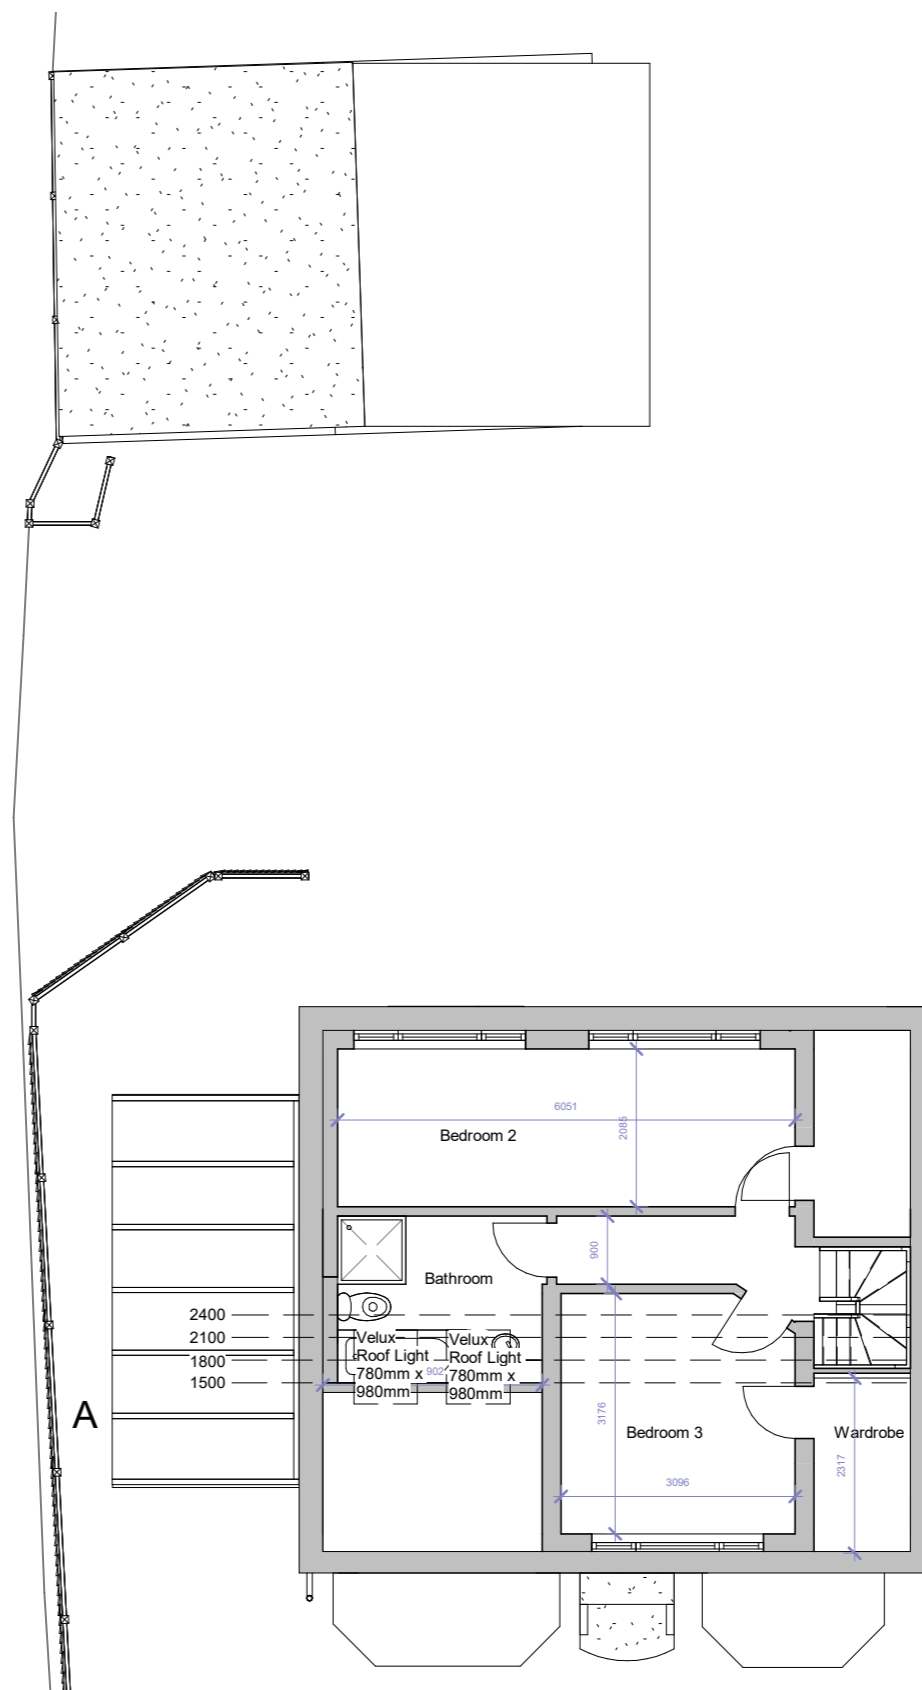

**Proposed First Floor**  
1 : 100



- Legend
- MH Man Hole
  - B Boiler

**Fluent**  
ARCHITECTURAL DESIGN SERVICES

FLUENT  
ARCHITECTURAL DESIGN SERVICES

TEL: 0800 043 8838  
E-MAIL: INFO@FLUENT-ADS.CO.UK  
WEB: FLUENT-ADS.CO.UK

Kilomron Farnham Road Holt Pound

---

Existing Floor Plans

Scale @ A3  
1 : 100

Date  
11.09.2019

Drawn by  
D.Owolana

Drawing number  
FLU.1268.2.02

Rev

No.	Description	Date