






ELECTRICAL SYMBOLS

 
- 

 
CEILING OUTLET LIGHTING FILAMENT LAMP
- 

 
CONCEALED SPOT-LIGHTS
- 


ONE-WAY SWITCH
- 


Low level spur with high level switch
- 

Double 13 Amp switched socket outlet (at low level)
- 

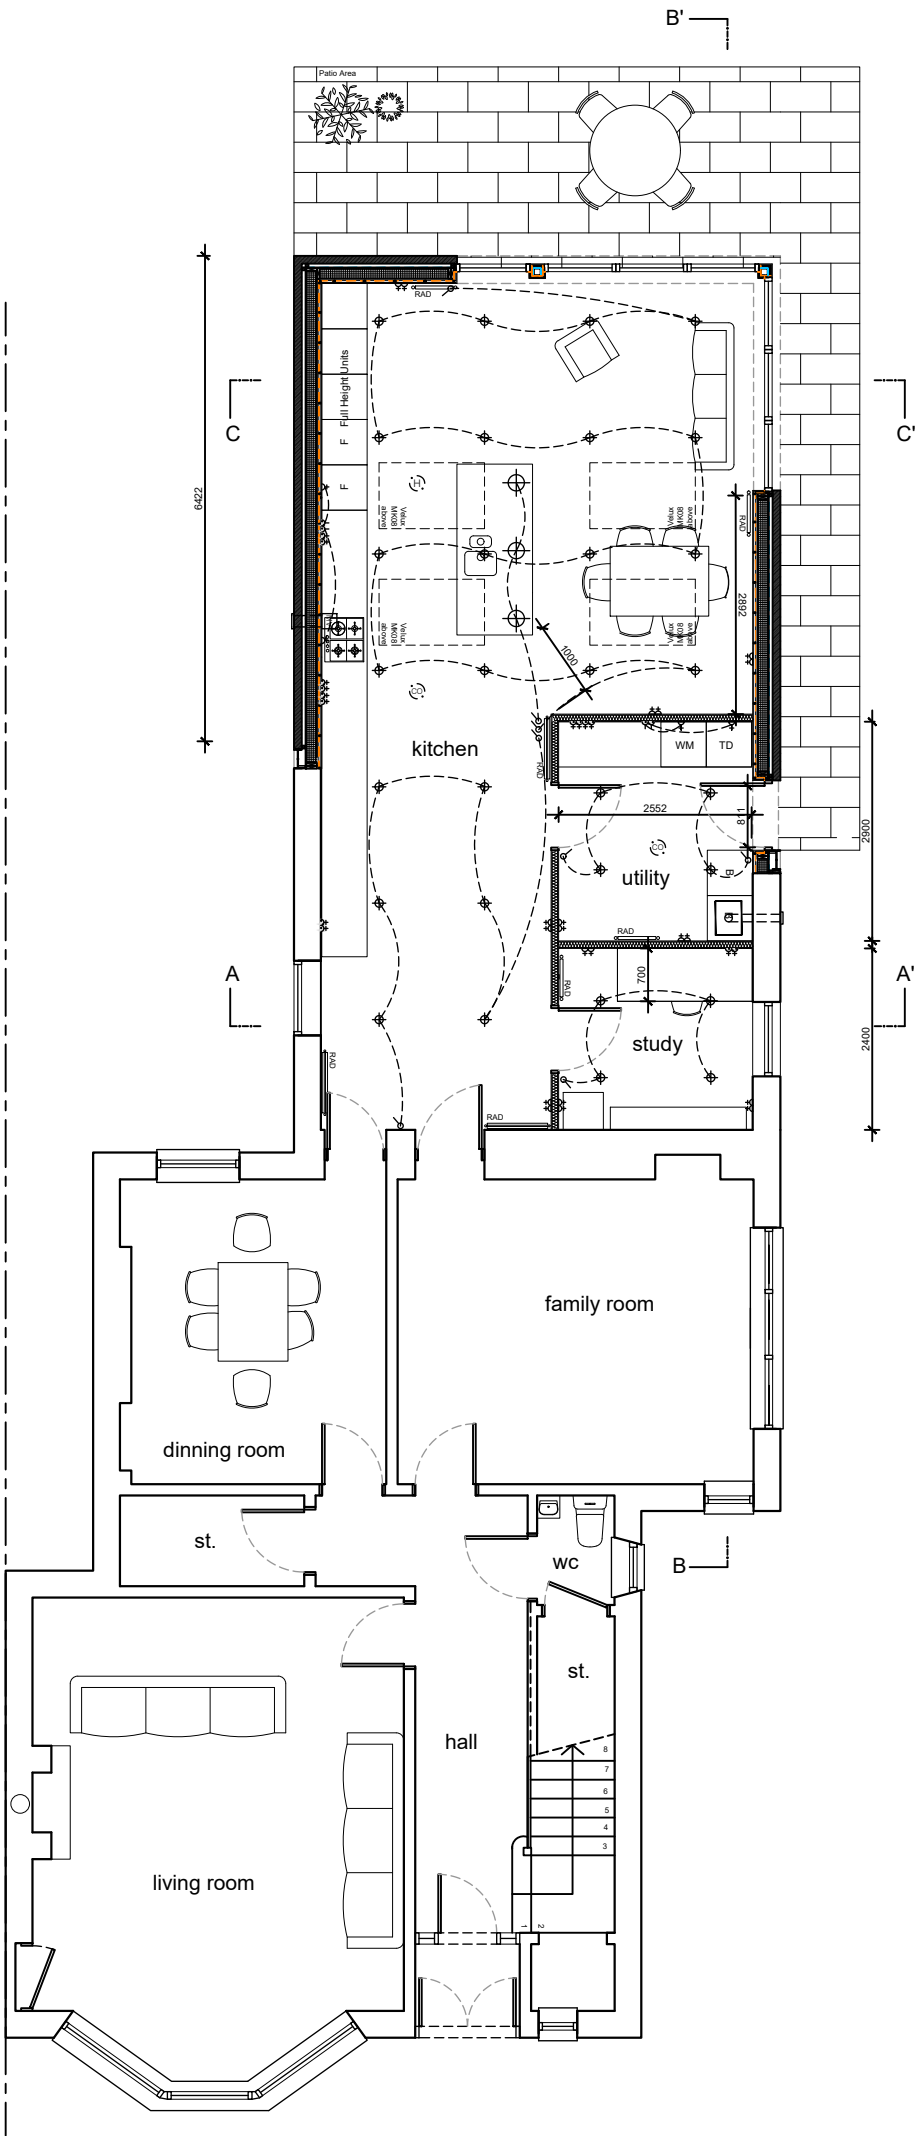
Double 13 Amp switched socket outlet (at high level)
- 

Carbon Monoxide monitor
- 

Audible smoke alarm (interwired & mains powered with battery backup)
- 

Audible heat alarm (interwired & mains powered with battery backup)
- 

Mechanical extract fan (horizontal extract) with fused isolator spur.



Revisions

Status

PLANNING/BUILDING WARRANT

Client

Adrienne Amner and Roy Amner

Project

6 Laggan Road
Glasgow
G43 2SY

Title

Ground Floor Plan
as Proposed

Scale	Size	Date	Drawn	Checked
1:100	A3	30.03.21	FH	SA



Allison Architecture
13 Royal Crescent
Glasgow G3 7SL

t: +44 (0)141 353 1082
e: hello@allisonarchitecture.co.uk
www.allisonarchitecture.co.uk

Project No.	Drawing No.	Rev.
20058	02-001	-

