


**Typical Detail 01: Underfloor Heating to Lower Ground Floor**  
1:10



**Typical Detail 02: Underfloor Heating to upper floors**  
1:10

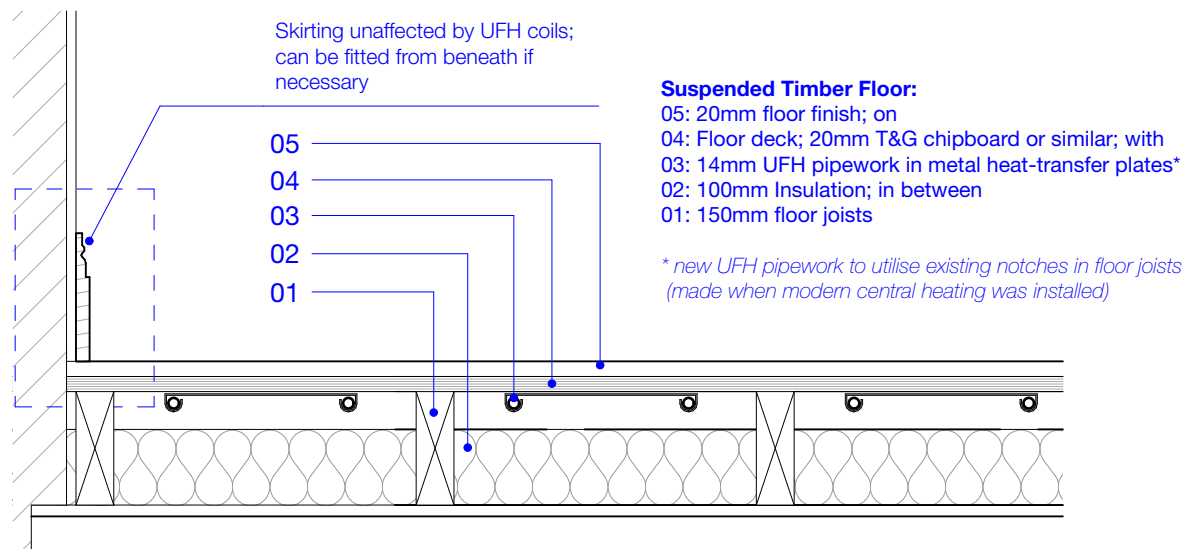

**Key Plan: Section A**  
1:100

REV	DATE	DRAWN	AMENDMENT



Studios 18-19, 16 Porteus Place,  
Clapham, London SW4 0AS

t +44 (0) 20 7924 4555  
e info@granit.co.uk  
w www.granit.co.uk

Project **29 Champion Grove**

For **Damian Thornton**

Project Address **29 Champion Grove  
Camberwell, London SE5 8BN  
United Kingdom**

Drawing No. **2020/D/503**

Drawing **Typical Under-Floor Heating Details**

Purpose **FOR PLANNING**

Revision
*

Scale 1:10, 1:100 @ A3 Date 19/05/2021 Drawn WM

Notes IF THIS DRAWING HAS BEEN ISSUED 'FOR CONSTRUCTION' DO NOT SCALE DIRECTLY FROM IT. ALL DIMENSIONS TO BE CHECKED ON-SITE. PLEASE CONTACT ARCHITECT IF YOU REQUIRE CONFIRMATION OF ANY DIMENSIONS. ANY DISCREPANCIES TO BE RAISED WITH CONTRACT ADMINISTRATOR.

File 2020\_CHAMPION\_GROVE\_CURRENT.pln