



Reproduced by permission of Ordnance Survey on behalf of the Controller of Her Majesty's Stationery Office
All rights reserved. © Crown Copyright licence no.100022432

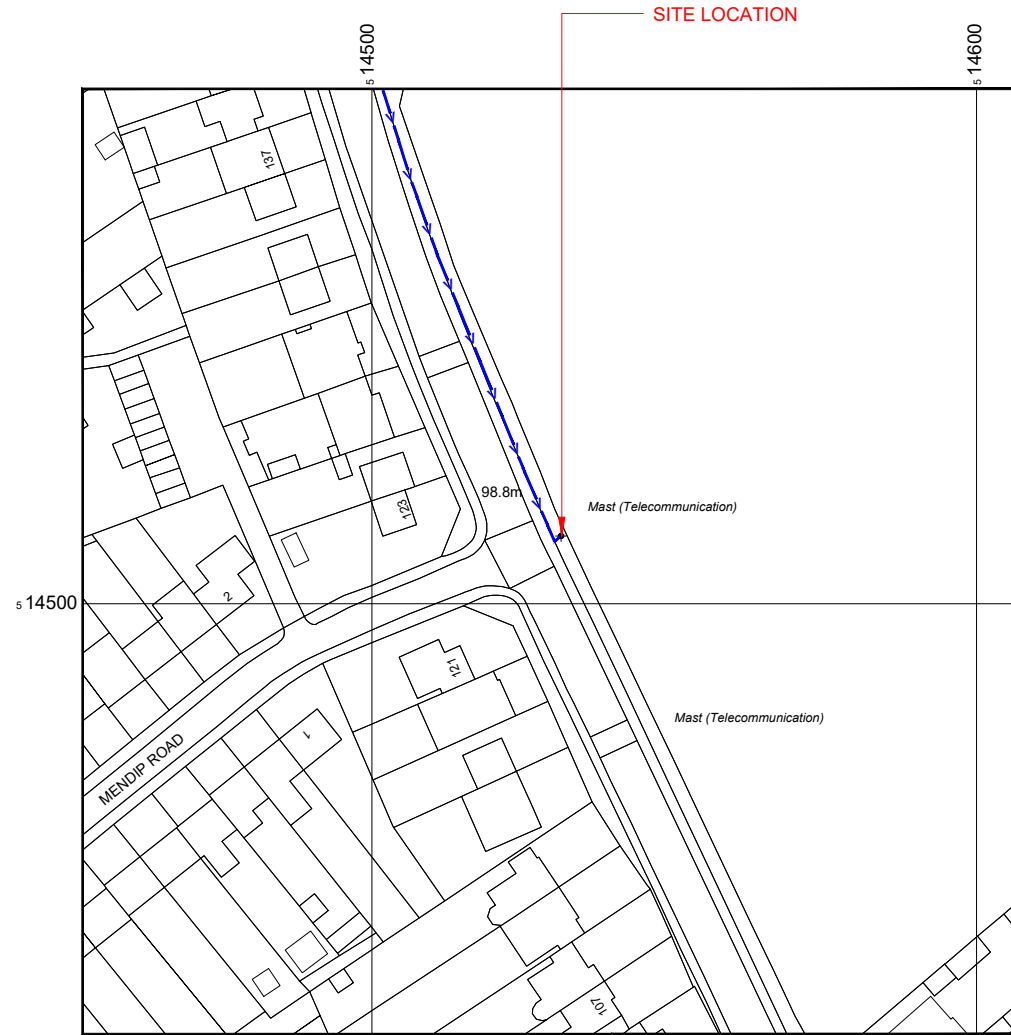

Reproduced by permission of Ordnance Survey on behalf of the Controller of Her Majesty's Stationery Office
All rights reserved. © Crown Copyright licence no.100062043

NGR E: 514529 N: 195410

 NOTES:
1. ALL DIMENSIONS IN MM UNLESS OTHERWISE NOTED.
DIRECTIONS TO SITE: M1 J5 take the A41 south, turn right at roundabout onto B462, then first left onto Little Bushey Lane, Site is approx 2k down road. Traffic management required



Master: M001	MBNL / EE / H3G: MBNL	Project: VENDOR SWAP	Purpose of Issue: Planning	Issue: A
Date: 10/10/2020	Revision / Upgrade Description: First Issue			
Drawn: C.D.N				
Checked: S.Farrell				
Approved: S.Farrell				



Hatfield Business Park
Hatfield
Hertfordshire
AL10 9BW

Tel: 01707 315000
Fax: 01707 319001

Design Consultant & Principal Contractor:



Unit E, Madison Place, Northampton Road,
Manchester, M40 5AG
Tel: 0161 785 4500 Fax: 0161 785 4501
Web: www.clarke-telecom.com

Site Name: **MENDIP**

Site ID: **957324**

Address:
**LITTLE BUSHEY LANE
BUSHEY WATFORD
HERTFORDSHIRE
WD23 4SB**

Title: **002 SITE LOCATION PLAN**


Project: **VENDOR SWAP**

Purpose of Issue: **GENERAL ARRANGEMENT**

EE Cell ID: 50715	MBNL Cell ID: HTM006	3UK Cell ID: WD0096
-----------------------------	--------------------------------	-------------------------------


Master Drawing No: **957324_HTM006_50715_WD0096_M001** Issue: **A**

 SITE AREA PLAN



SITE PHOTOGRAPH

 SITE LOCATION PLAN




GOOGLE MAPS QR CODE


GOOGLE MAPS - <https://goo.gl/maps/beW2YwmaYvoxkeiHA>

GOOGLE STREET VIEW - <https://goo.gl/maps/x53opvesjQLWjBQF7>

100mm
50mm
10mm

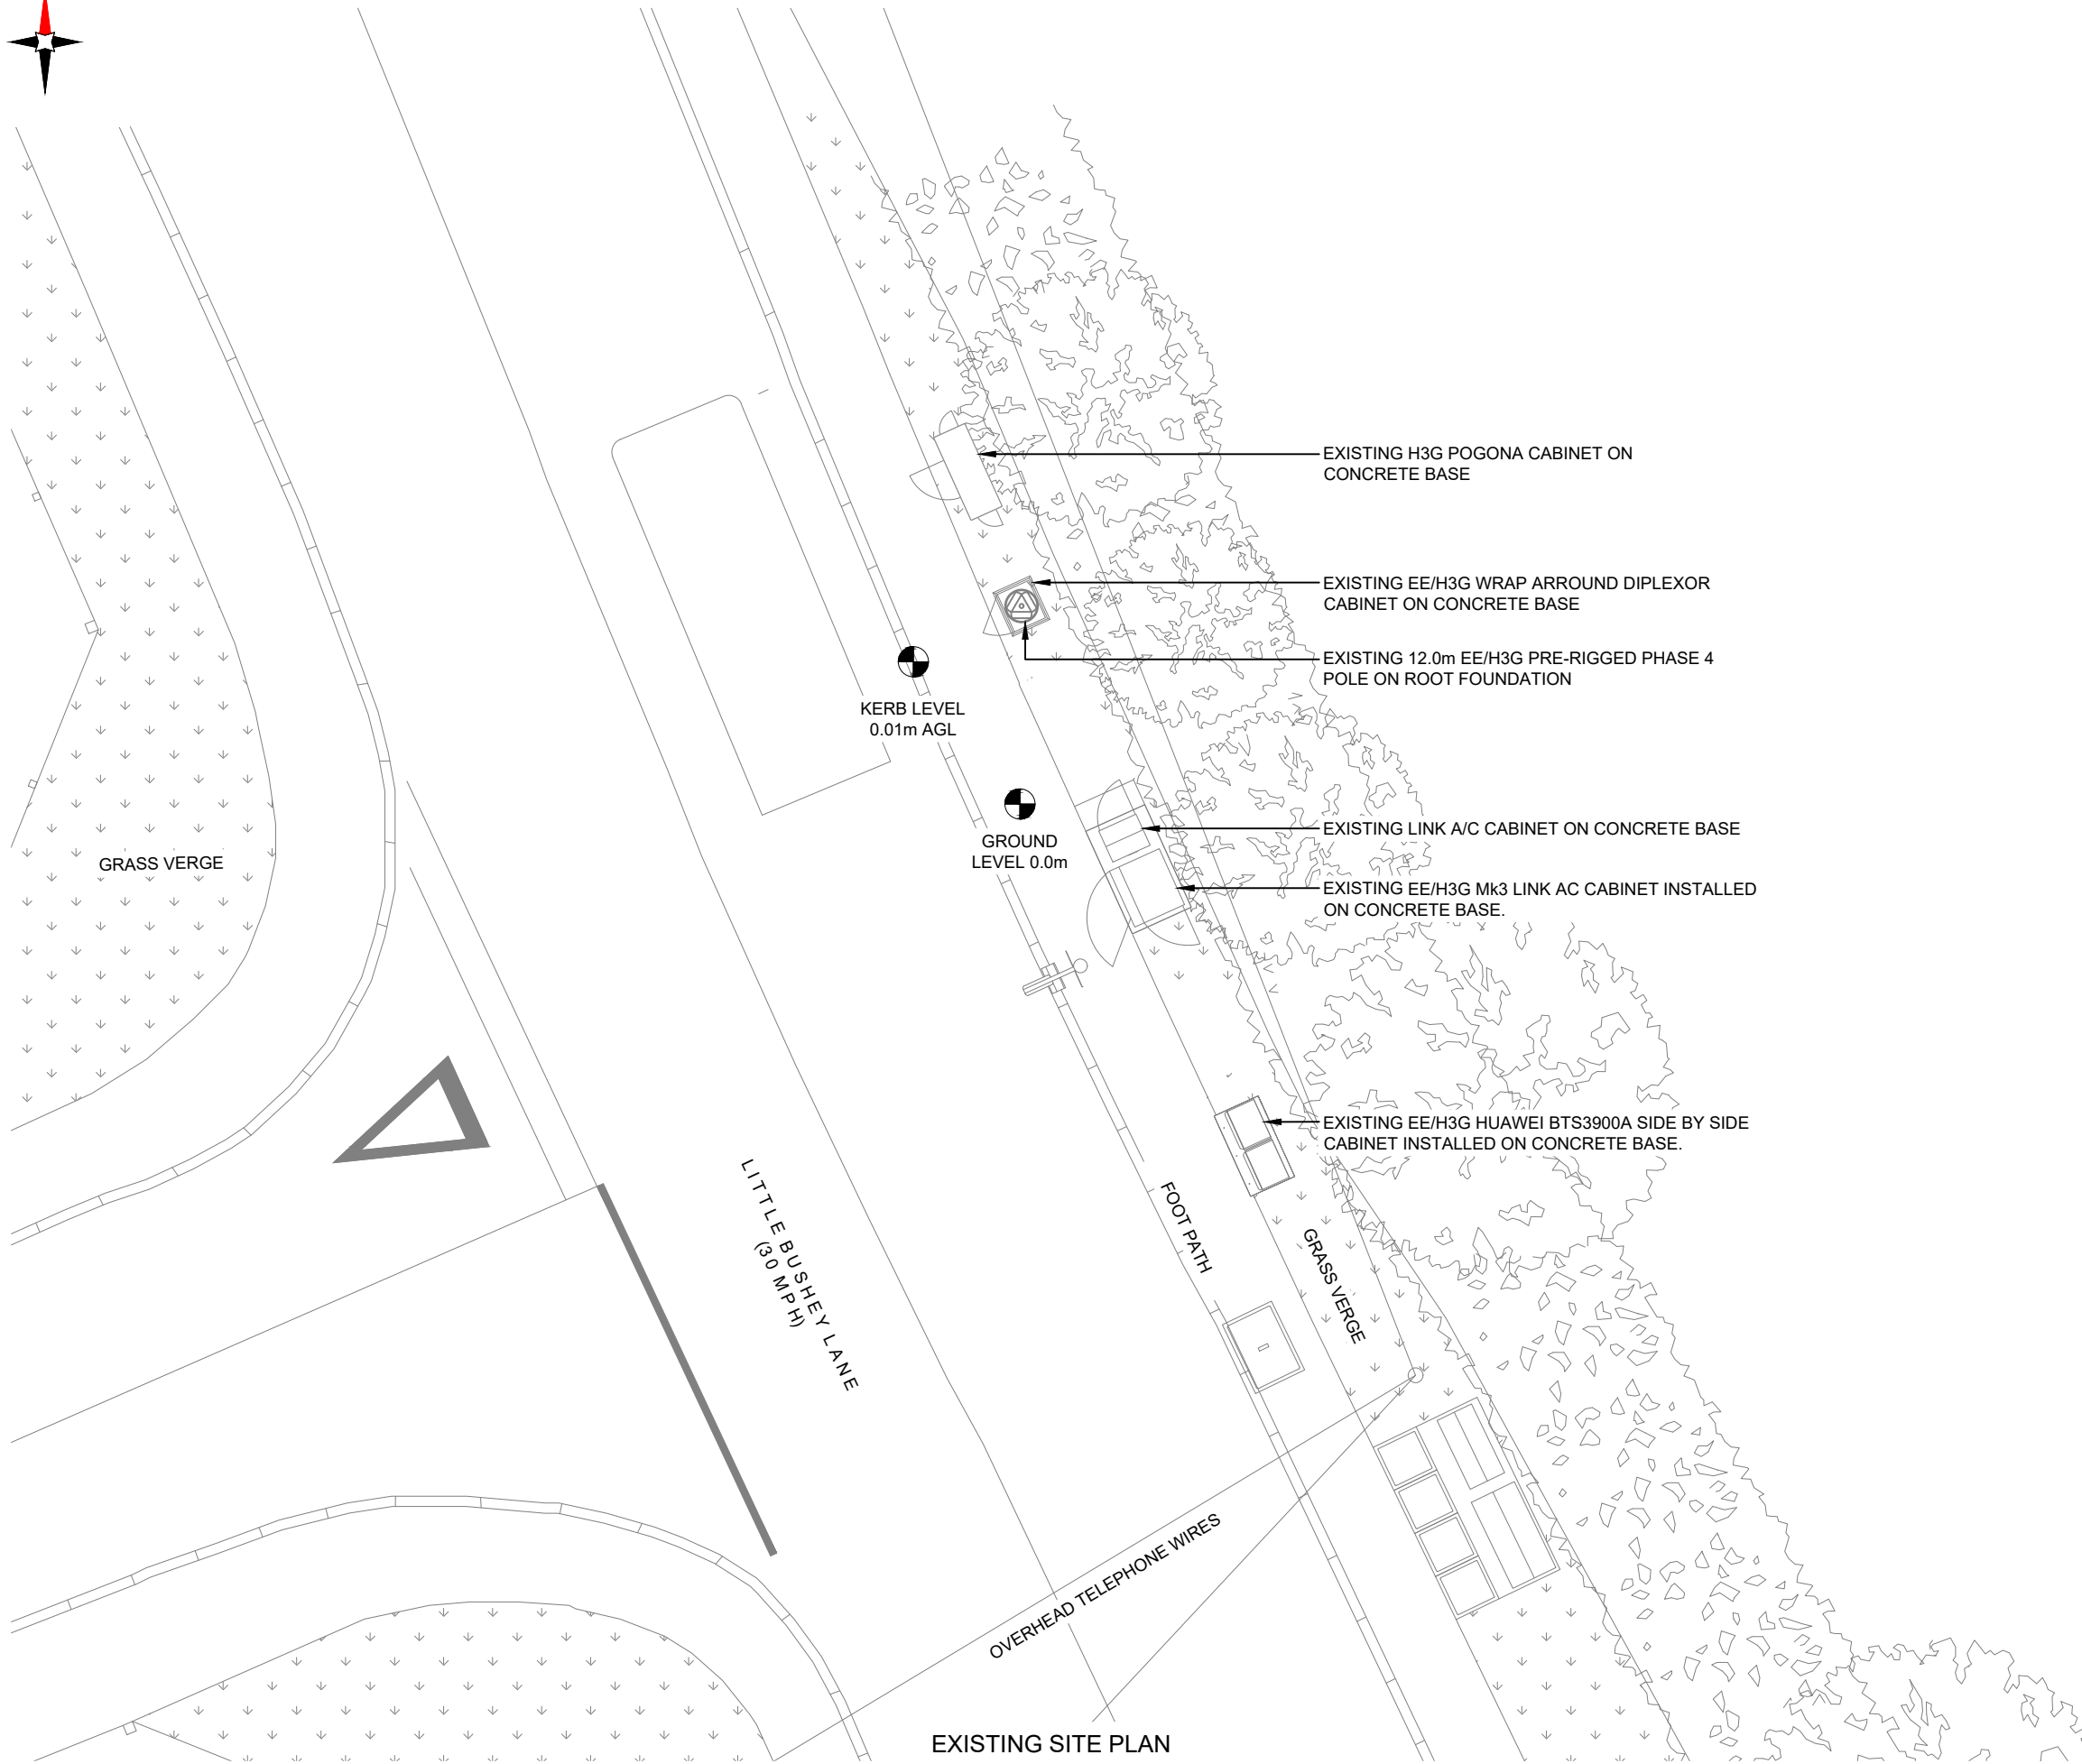

EXISTING SITE PLAN

 

NOTES:
1. ALL DIMENSIONS IN MM UNLESS OTHERWISE NOTED.

Master:	MBNL / EE / H3G:	Project:	Purpose of Issue:	Issue:
M001	MBNL	VENDOR SWAP	Planning	A
Date:	10/10/2020	Revision / Upgrade Description:		
Drawn:	C.D.N	First Issue		
Checked:	S.Farrell			
Approved:	S.Farrell			



Hatfield Business Park
Hatfield
Hertfordshire
AL10 9BW

Tel: 01707 315000
Fax: 01707 319001

Design Consultant & Principal Contractor:



Unit E, Madison Place, Northampton Road,
Manchester, M40 5AG
Tel: 0161 785 4500 Fax: 0161 785 4501
Web: www.clarke-telecom.com

Site Name: MENDIP

Site ID: 957324

Address:
LITTLE BUSHEY LANE
BUSHEY WATFORD
HERTFORDSHIRE
WD23 4SB

Title: 100 EXISTING SITE PLAN


Project: VENDOR SWAP

Purpose of Issue: GENERAL ARRANGEMENT


EE Cell ID:	MBNL Cell ID:	3UK Cell ID:
50715	HTM006	WD0096

Master Drawing No: 957324_HTM006_50715_WD0096_M001 Issue: A

100mm
50mm
10mm

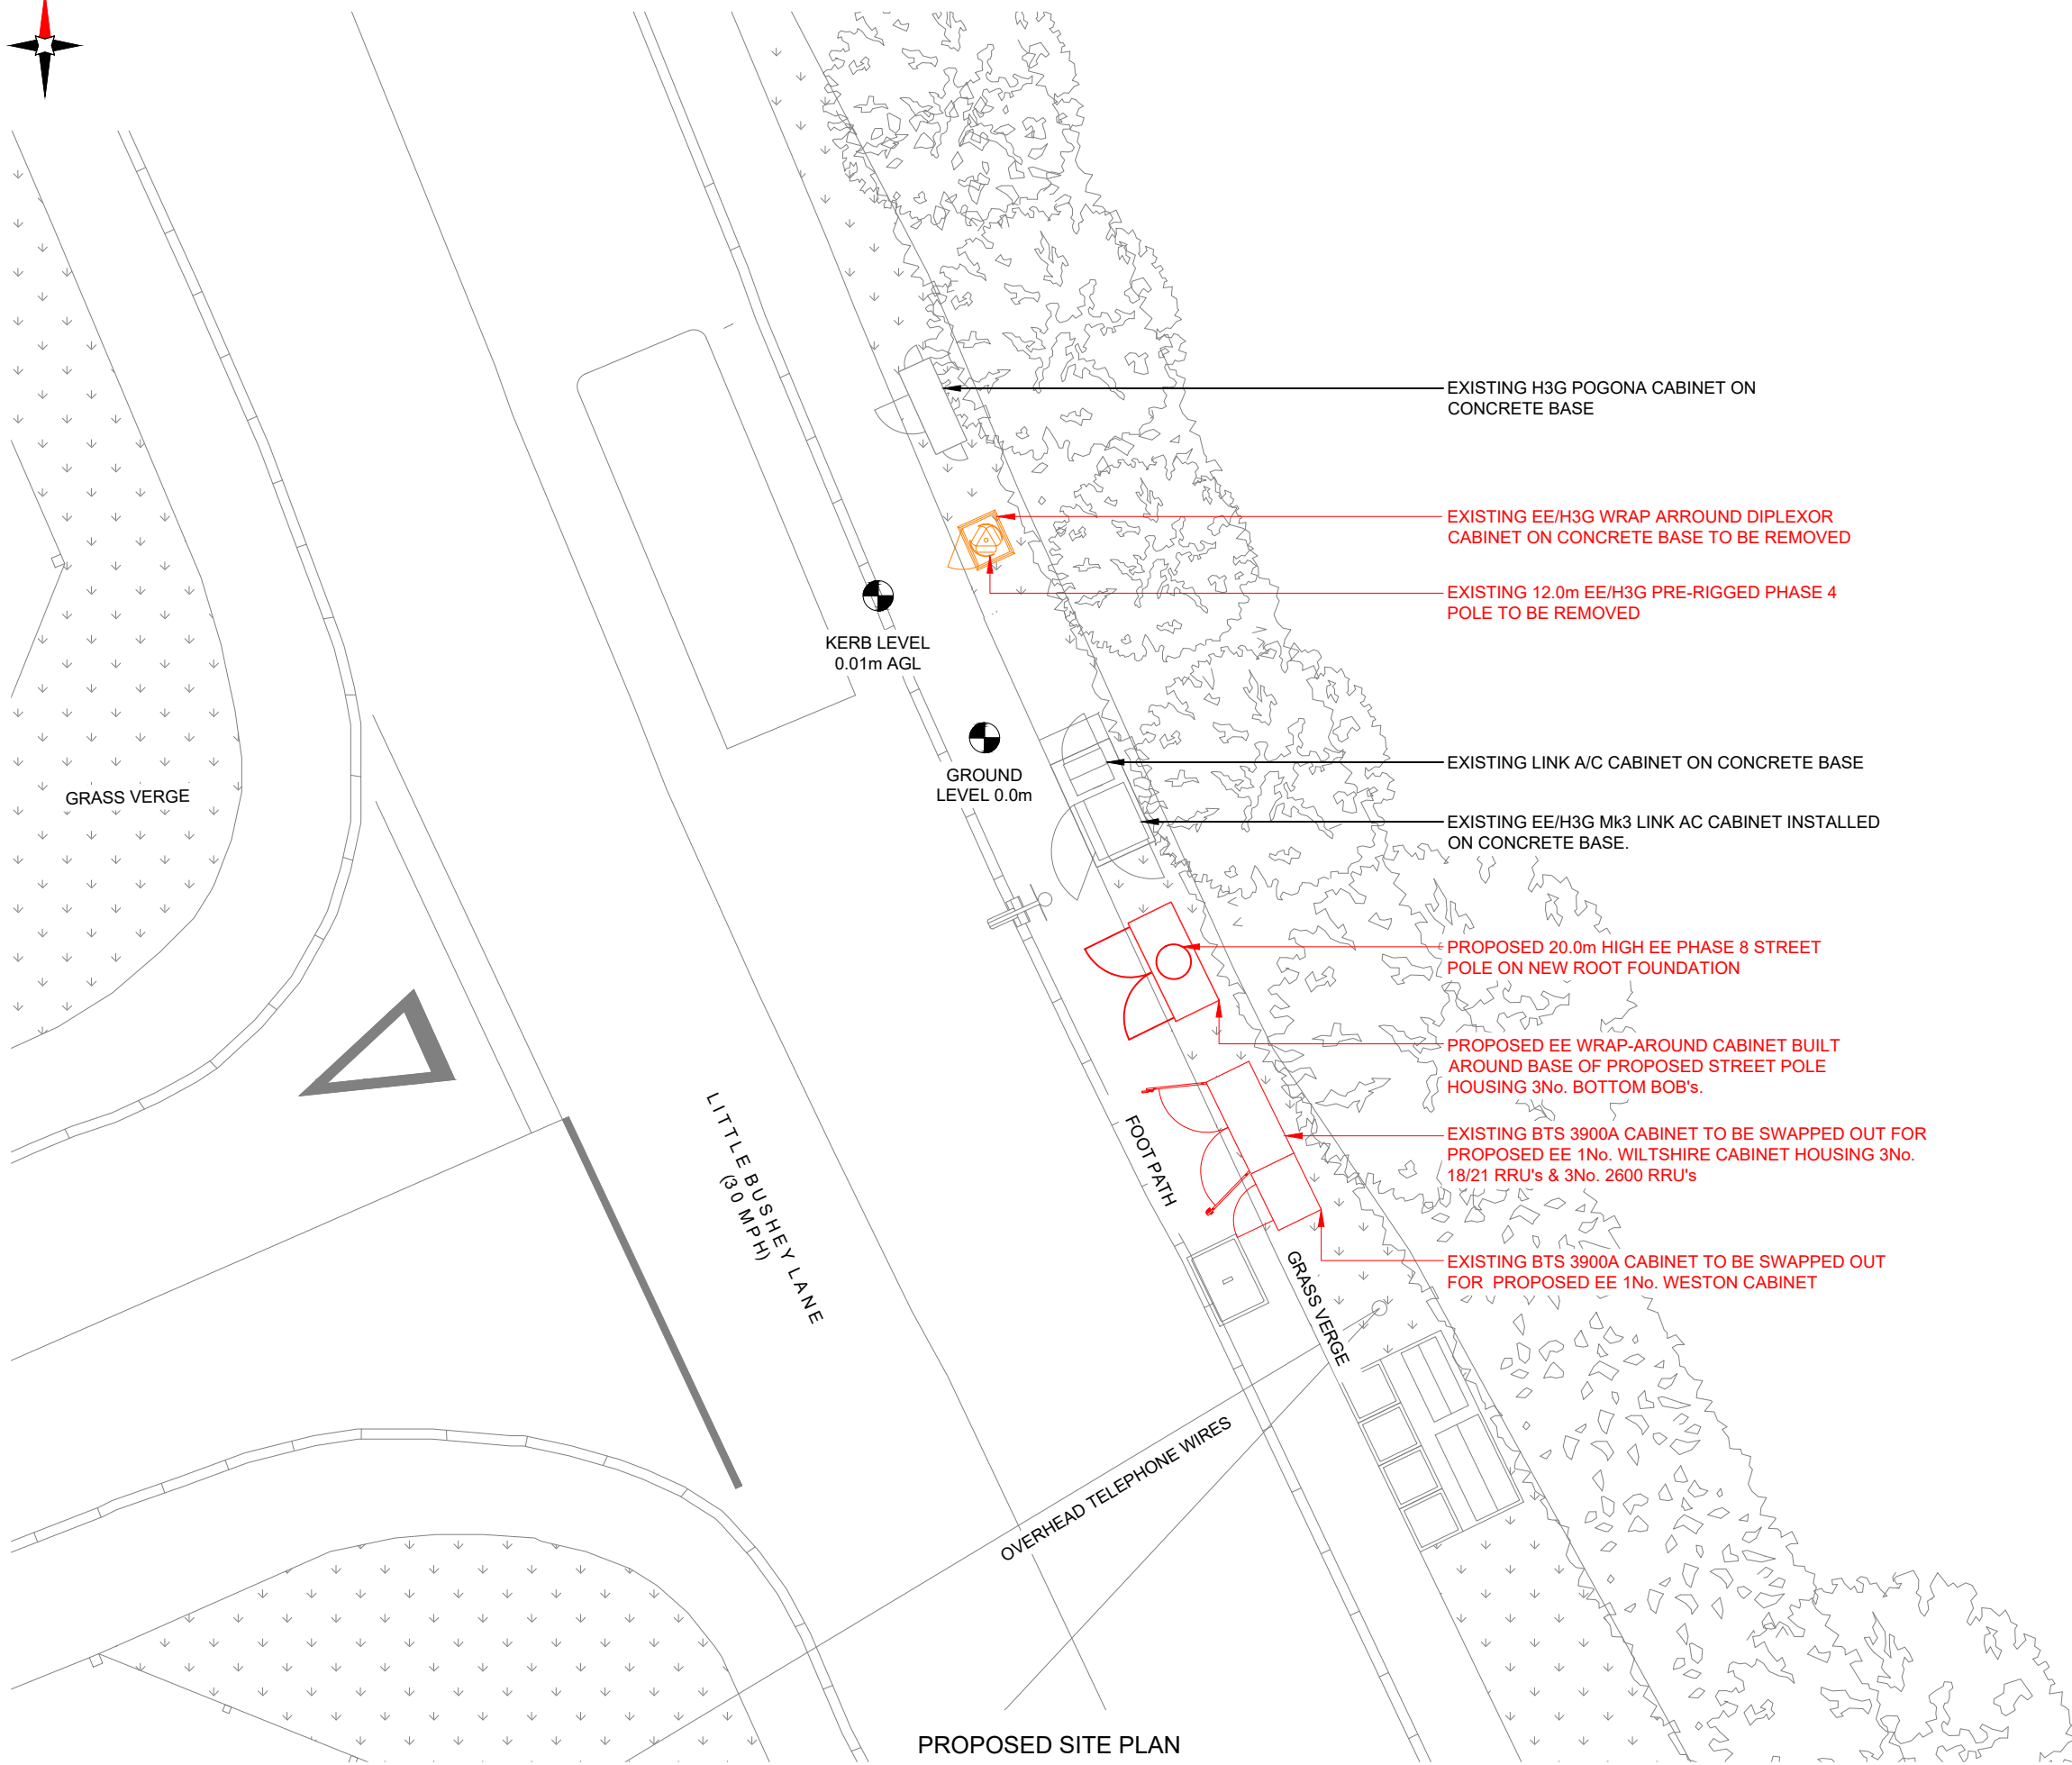

PROPOSED SITE PLAN

 

NOTES:

1. ALL DIMENSIONS IN MM UNLESS OTHERWISE NOTED.

Note:
All existing fibre / feeder cables to be re-used. Subject to testing. Un-used feeder cables to remain and be capped

ANTENNAS			
EXISTING	PROPOSED	TO BE REMOVED	TOTAL
3	3	0	6

EQUIPMENT CABINETS			
EXISTING	PROPOSED	TO BE REMOVED	TOTAL
5	3	1	7

Master: M001	MBNL / EE / H3G: MBNL	Project: VENDOR SWAP	Purpose of Issue: Planning	Issue: A
Date: 10/10/2020	Drawn: C.D.N	Revision / Upgrade Description: First Issue		
Checked: S.Farrell	Approved: S.Farrell			



Hatfield Business Park
Hatfield
Hertfordshire
AL10 9BW

Tel: 01707 315000
Fax: 01707 319001

Design Consultant & Principal Contractor:



Unit E, Madison Place, Northampton Road,
Manchester, M40 5AG
Tel: 0161 785 4500 Fax: 0161 785 4501
Web: www.clarke-telecom.com

Site Name: MENDIP

Site ID: 957324

Address:
LITTLE BUSHEY LANE
BUSHEY WATFORD
HERTFORDSHIRE
WD23 4SB

Title: 150 PROPOSED SITE PLAN


Project: VENDOR SWAP

Purpose of Issue: GENERAL ARRANGEMENT


EE Cell ID: 50715	MBNL Cell ID: HTM006	3UK Cell ID: WD0096
-----------------------------	--------------------------------	-------------------------------

Master Drawing No: 957324_HTM006_50715_WD0096_M001	Issue: A
---	-------------

100mm
50mm
10mm

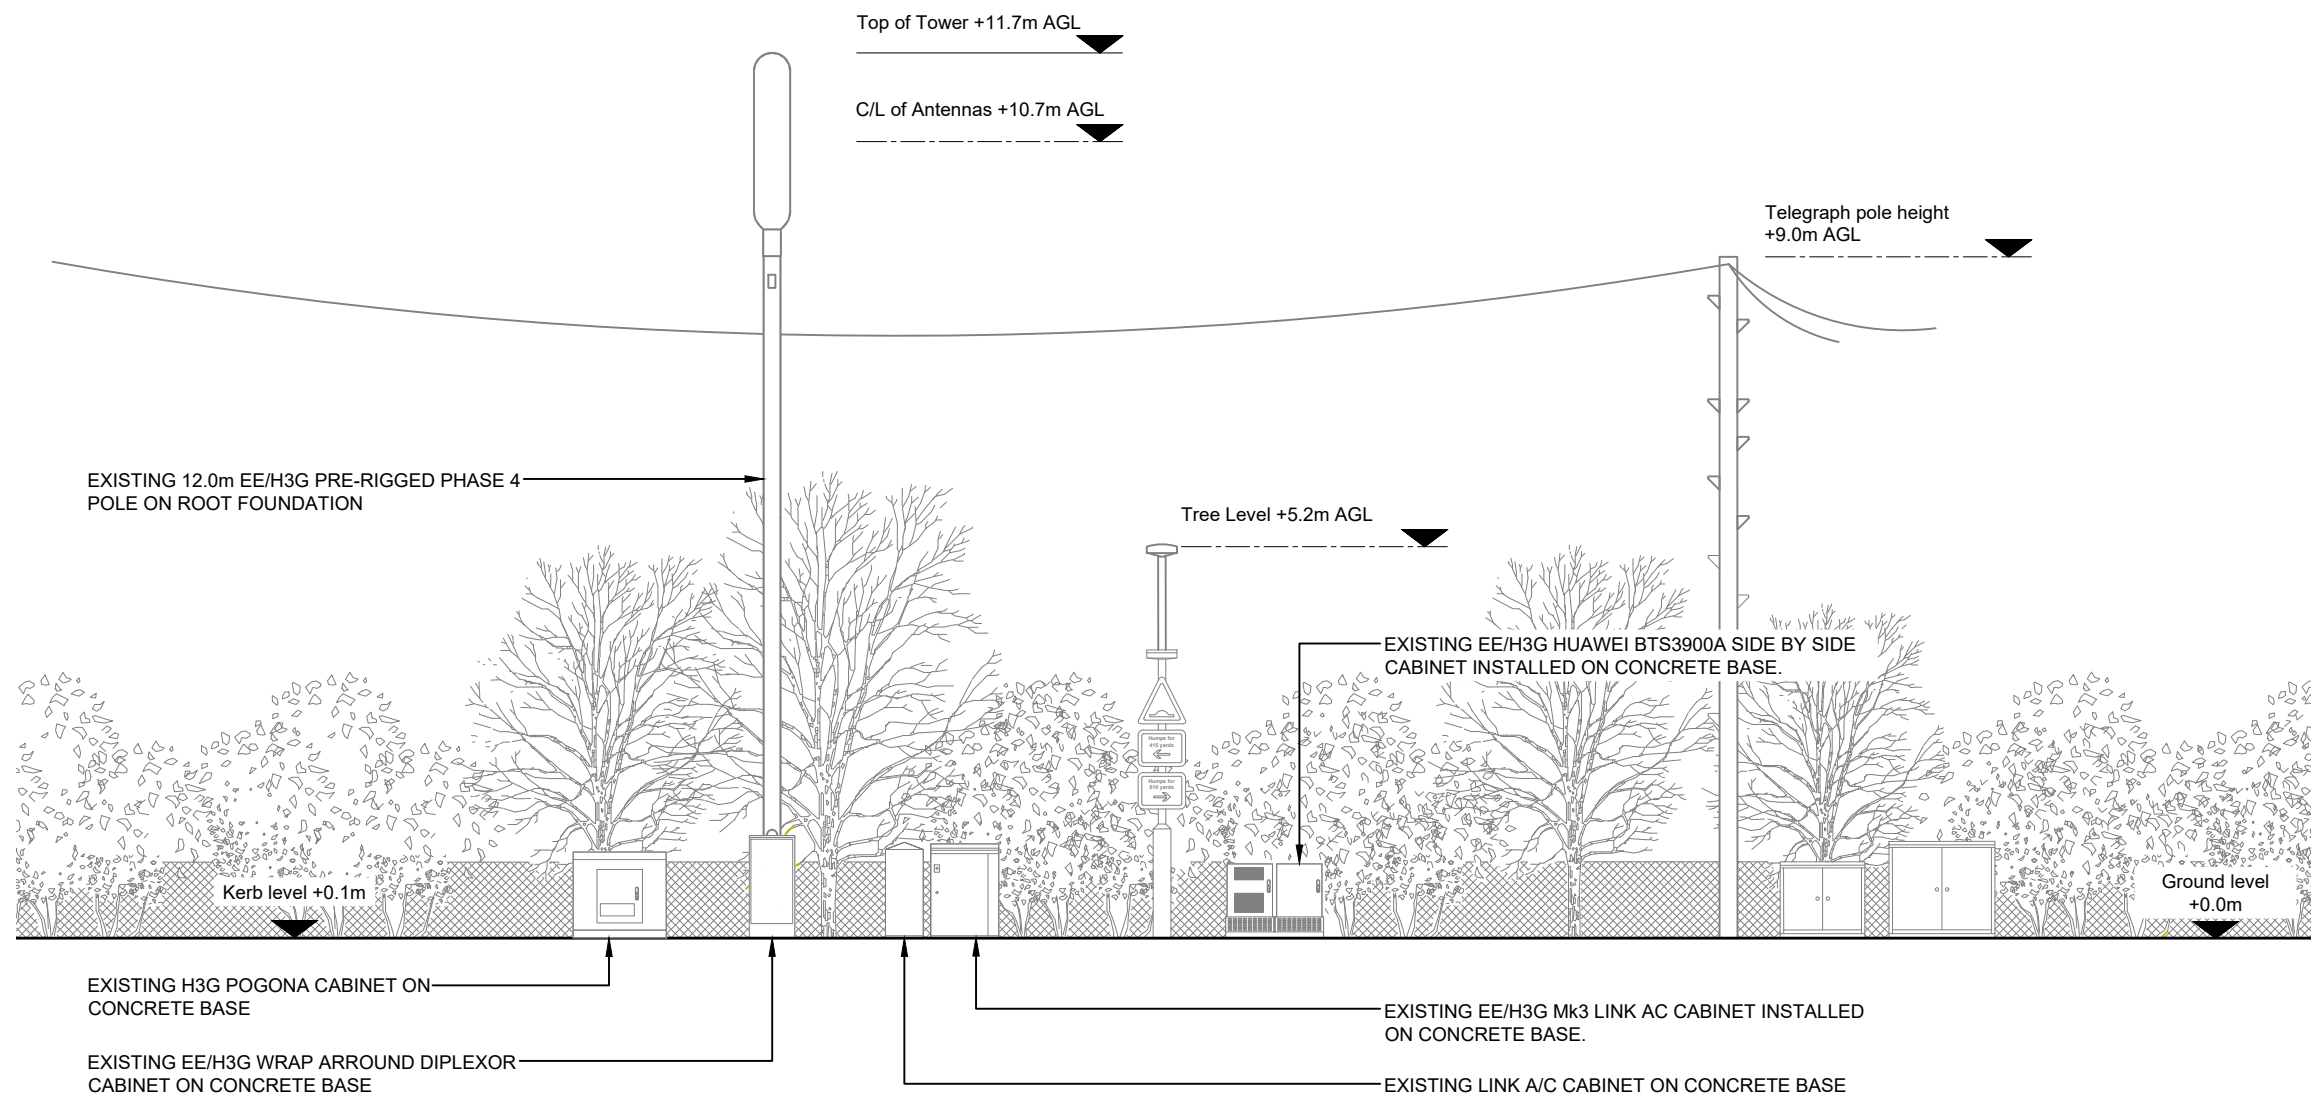

EXISTING SITE ELEVATION A

 

NOTES:
1. ALL DIMENSIONS IN MM UNLESS OTHERWISE NOTED.

Master:	MBNL / EE / H3G:	Project:	Purpose of Issue:	Issue:
M001	MBNL	VENDOR SWAP	Planning	A
Date:	10/10/2020	Revision / Upgrade Description:		
Drawn:	C.D.N	First Issue		
Checked:	S.Farrell			
Approved:	S.Farrell			



Hatfield Business Park
Hatfield
Hertfordshire
AL10 9BW

Tel: 01707 315000
Fax: 01707 319001

Design Consultant & Principal Contractor:



Unit E, Madison Place, Northampton Road,
Manchester, M40 5AG
Tel: 0161 785 4500 Fax: 0161 785 4501
Web: www.clarke-telecom.com

Site Name: MENDIP

Site ID: 957324

Address:
LITTLE BUSHEY LANE
BUSHEY WATFORD
HERTFORDSHIRE
WD23 4SB


Title: 200 EXISTING SITE ELEVATION A

Project: VENDOR SWAP


Purpose of Issue: GENERAL ARRANGEMENT

EE Cell ID:	MBNL Cell ID:	3UK Cell ID:
50715	HTM006	WD0096

Master Drawing No:	Issue:
957324_HTM006_50715_WD0096_M001	A

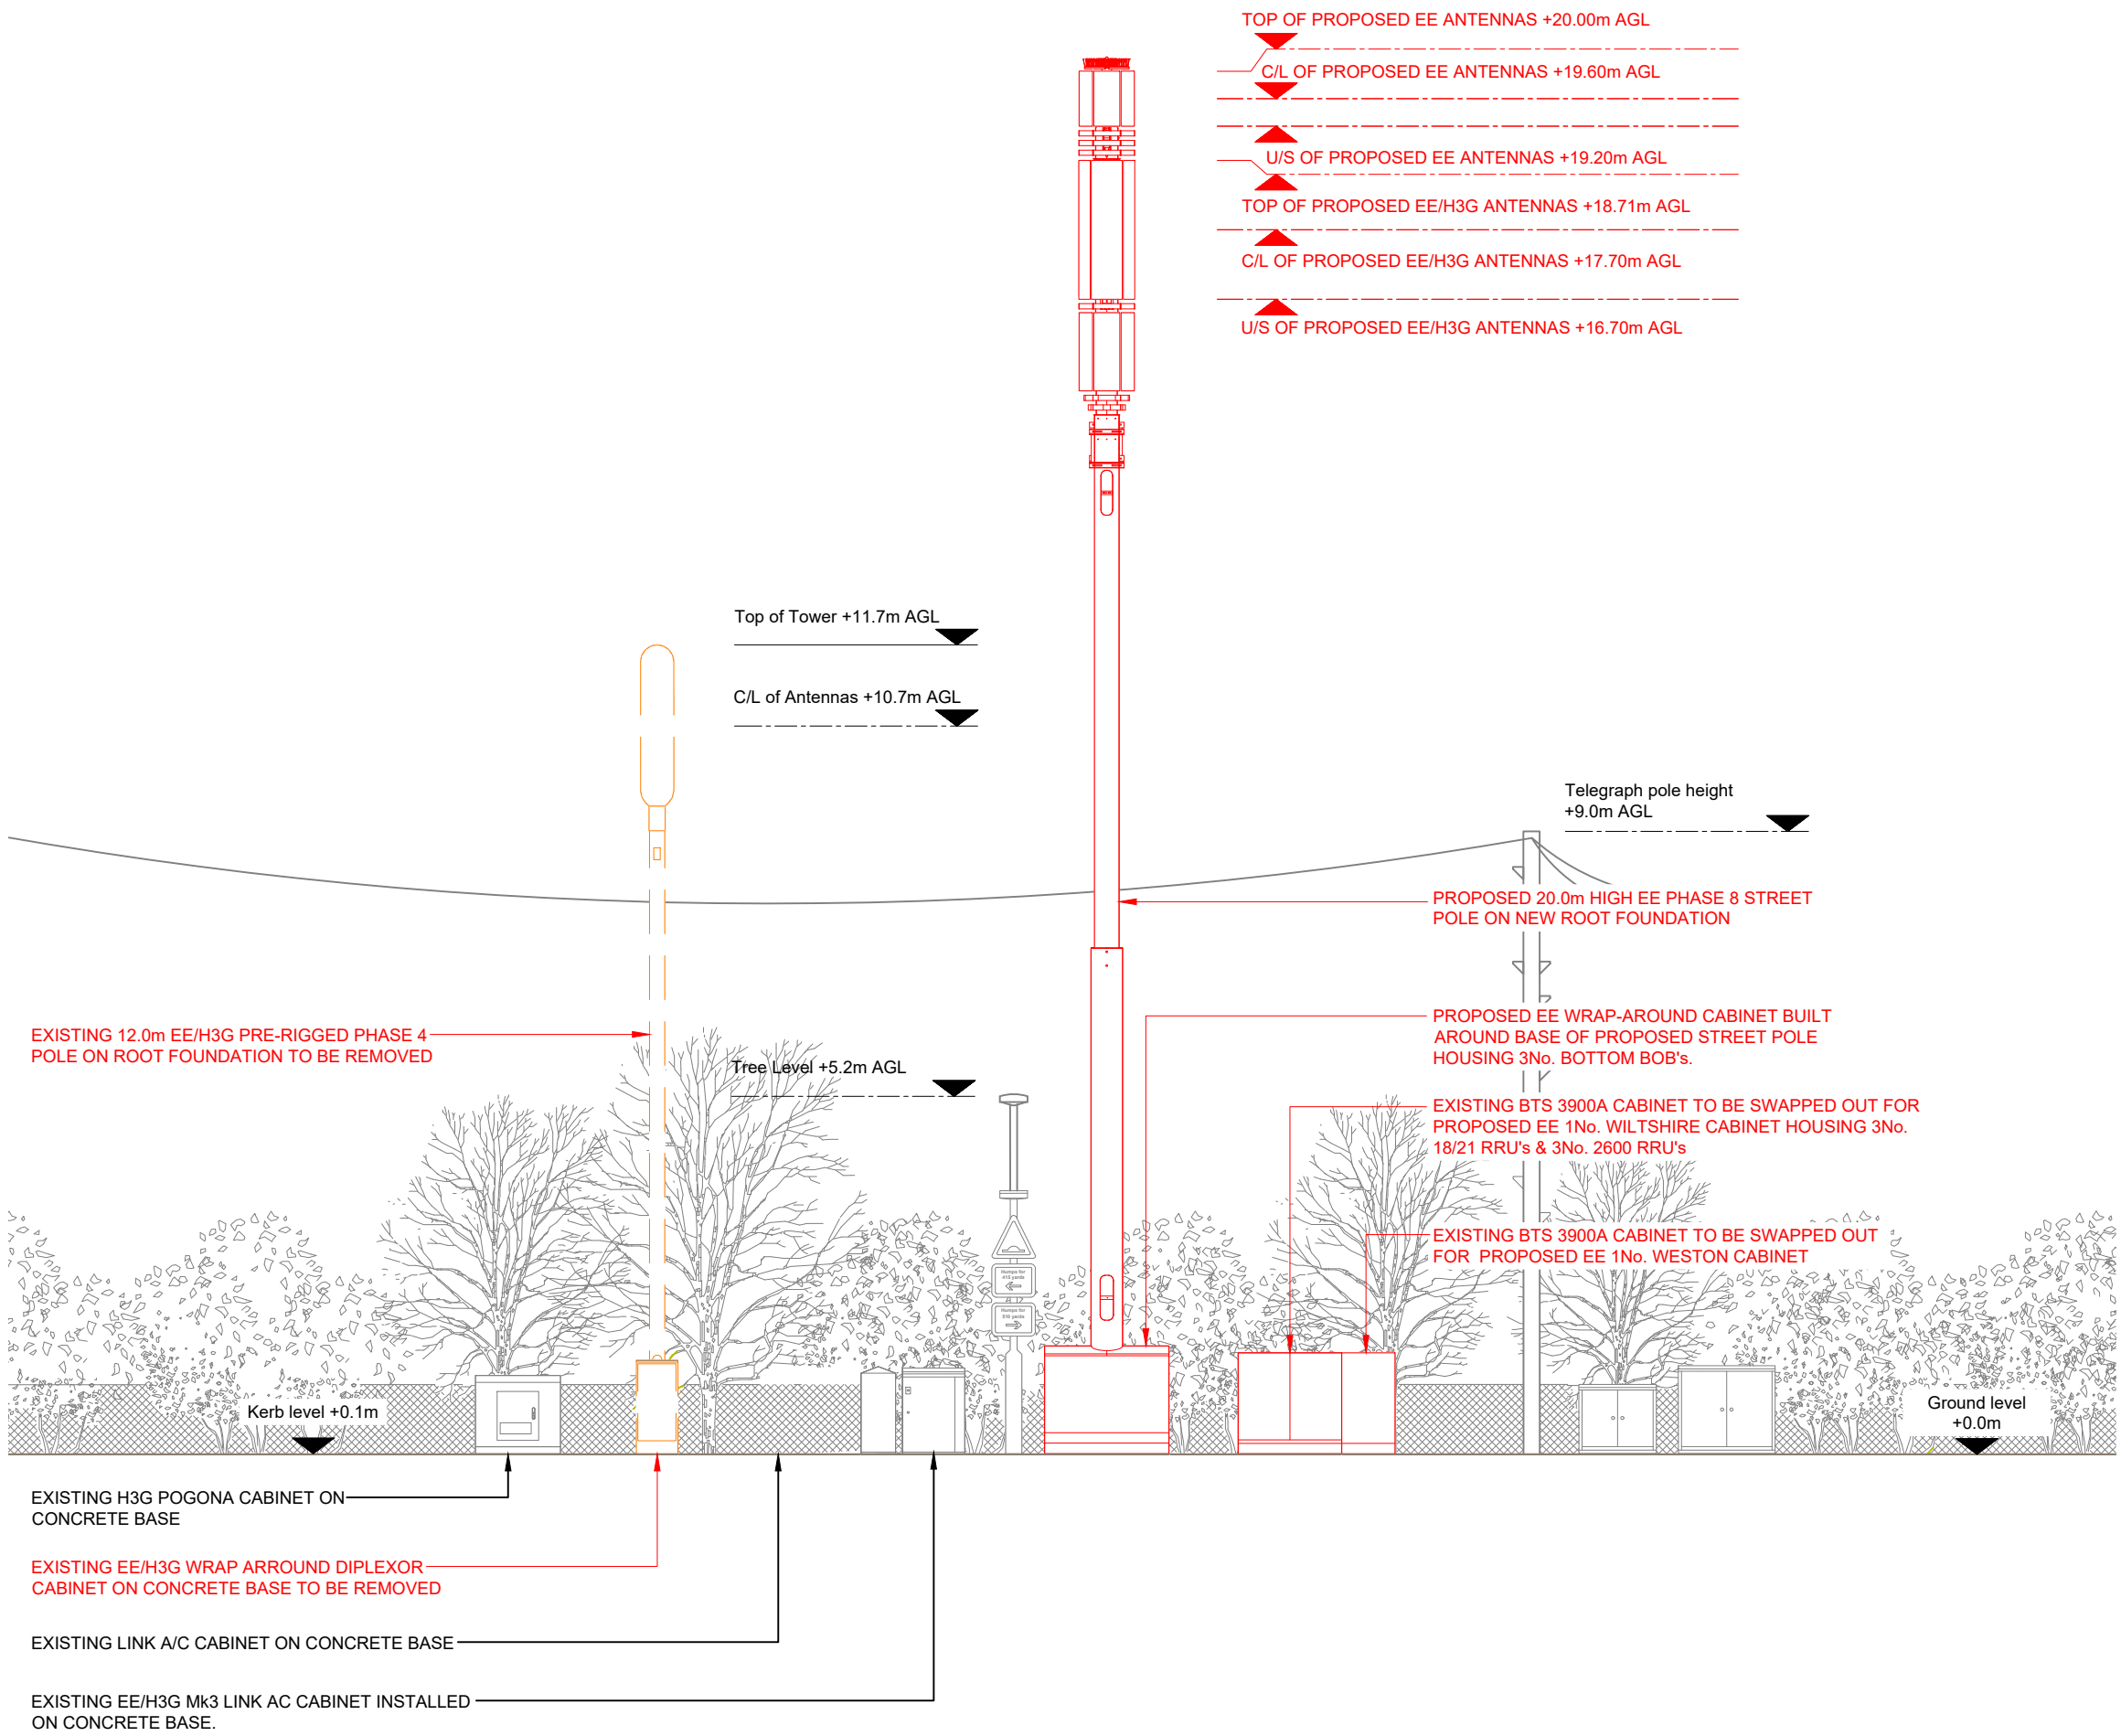

PROPOSED SITE ELEVATION A

 

NOTES:

1. ALL DIMENSIONS IN MM UNLESS OTHERWISE NOTED.

Note:
All existing fibre / feeder cables to be re-used. Subject to testing. Un-used feeder cables to remain and be capped

ANTENNAS			
EXISTING	PROPOSED	TO BE REMOVED	TOTAL
3	3	0	6

EQUIPMENT CABINETS			
EXISTING	PROPOSED	TO BE REMOVED	TOTAL
5	3	1	7

Master: M001	MBNL / EE / H3G: MBNL	Project: VENDOR SWAP	Purpose of Issue: Planning	Issue: A
Date: 10/10/2020	Drawn: C.D.N	Revision / Upgrade Description: First Issue		
Checked: S.Farrell	Approved: S.Farrell			



Hatfield Business Park
Hatfield
Hertfordshire
AL10 9BW

Tel: 01707 315000
Fax: 01707 319001

Design Consultant & Principal Contractor:
CLARKE telecom
Unit E, Madison Place, Northampton Road,
Manchester, M40 5AG
Tel: 0161 785 4500 Fax: 0161 785 4501
Web: www.clarke-telecom.com

Site Name: MENDIP

Site ID: 957324

Address:
LITTLE BUSHEY LANE
BUSHEY WATFORD
HERTFORDSHIRE
WD23 4SB

Title: 250 PROPOSED SITE ELEVATION A

Project: VENDOR SWAP


Purpose of Issue: GENERAL ARRANGEMENT

EE Cell ID: 50715	MBNL Cell ID: HTM006	3UK Cell ID: WD0096
-------------------	----------------------	---------------------


Master Drawing No: 957324_HTM006_50715_WD0096_M001	Issue: A
--	----------



Note: Existing cabinets to be retained in same location (or within 300mm) where possible but must be within the 600mm standard grid. Tx with Fibre must be retained in same location. Preferred access to front of all equipment is 800mm. Minimum front access is 600mm

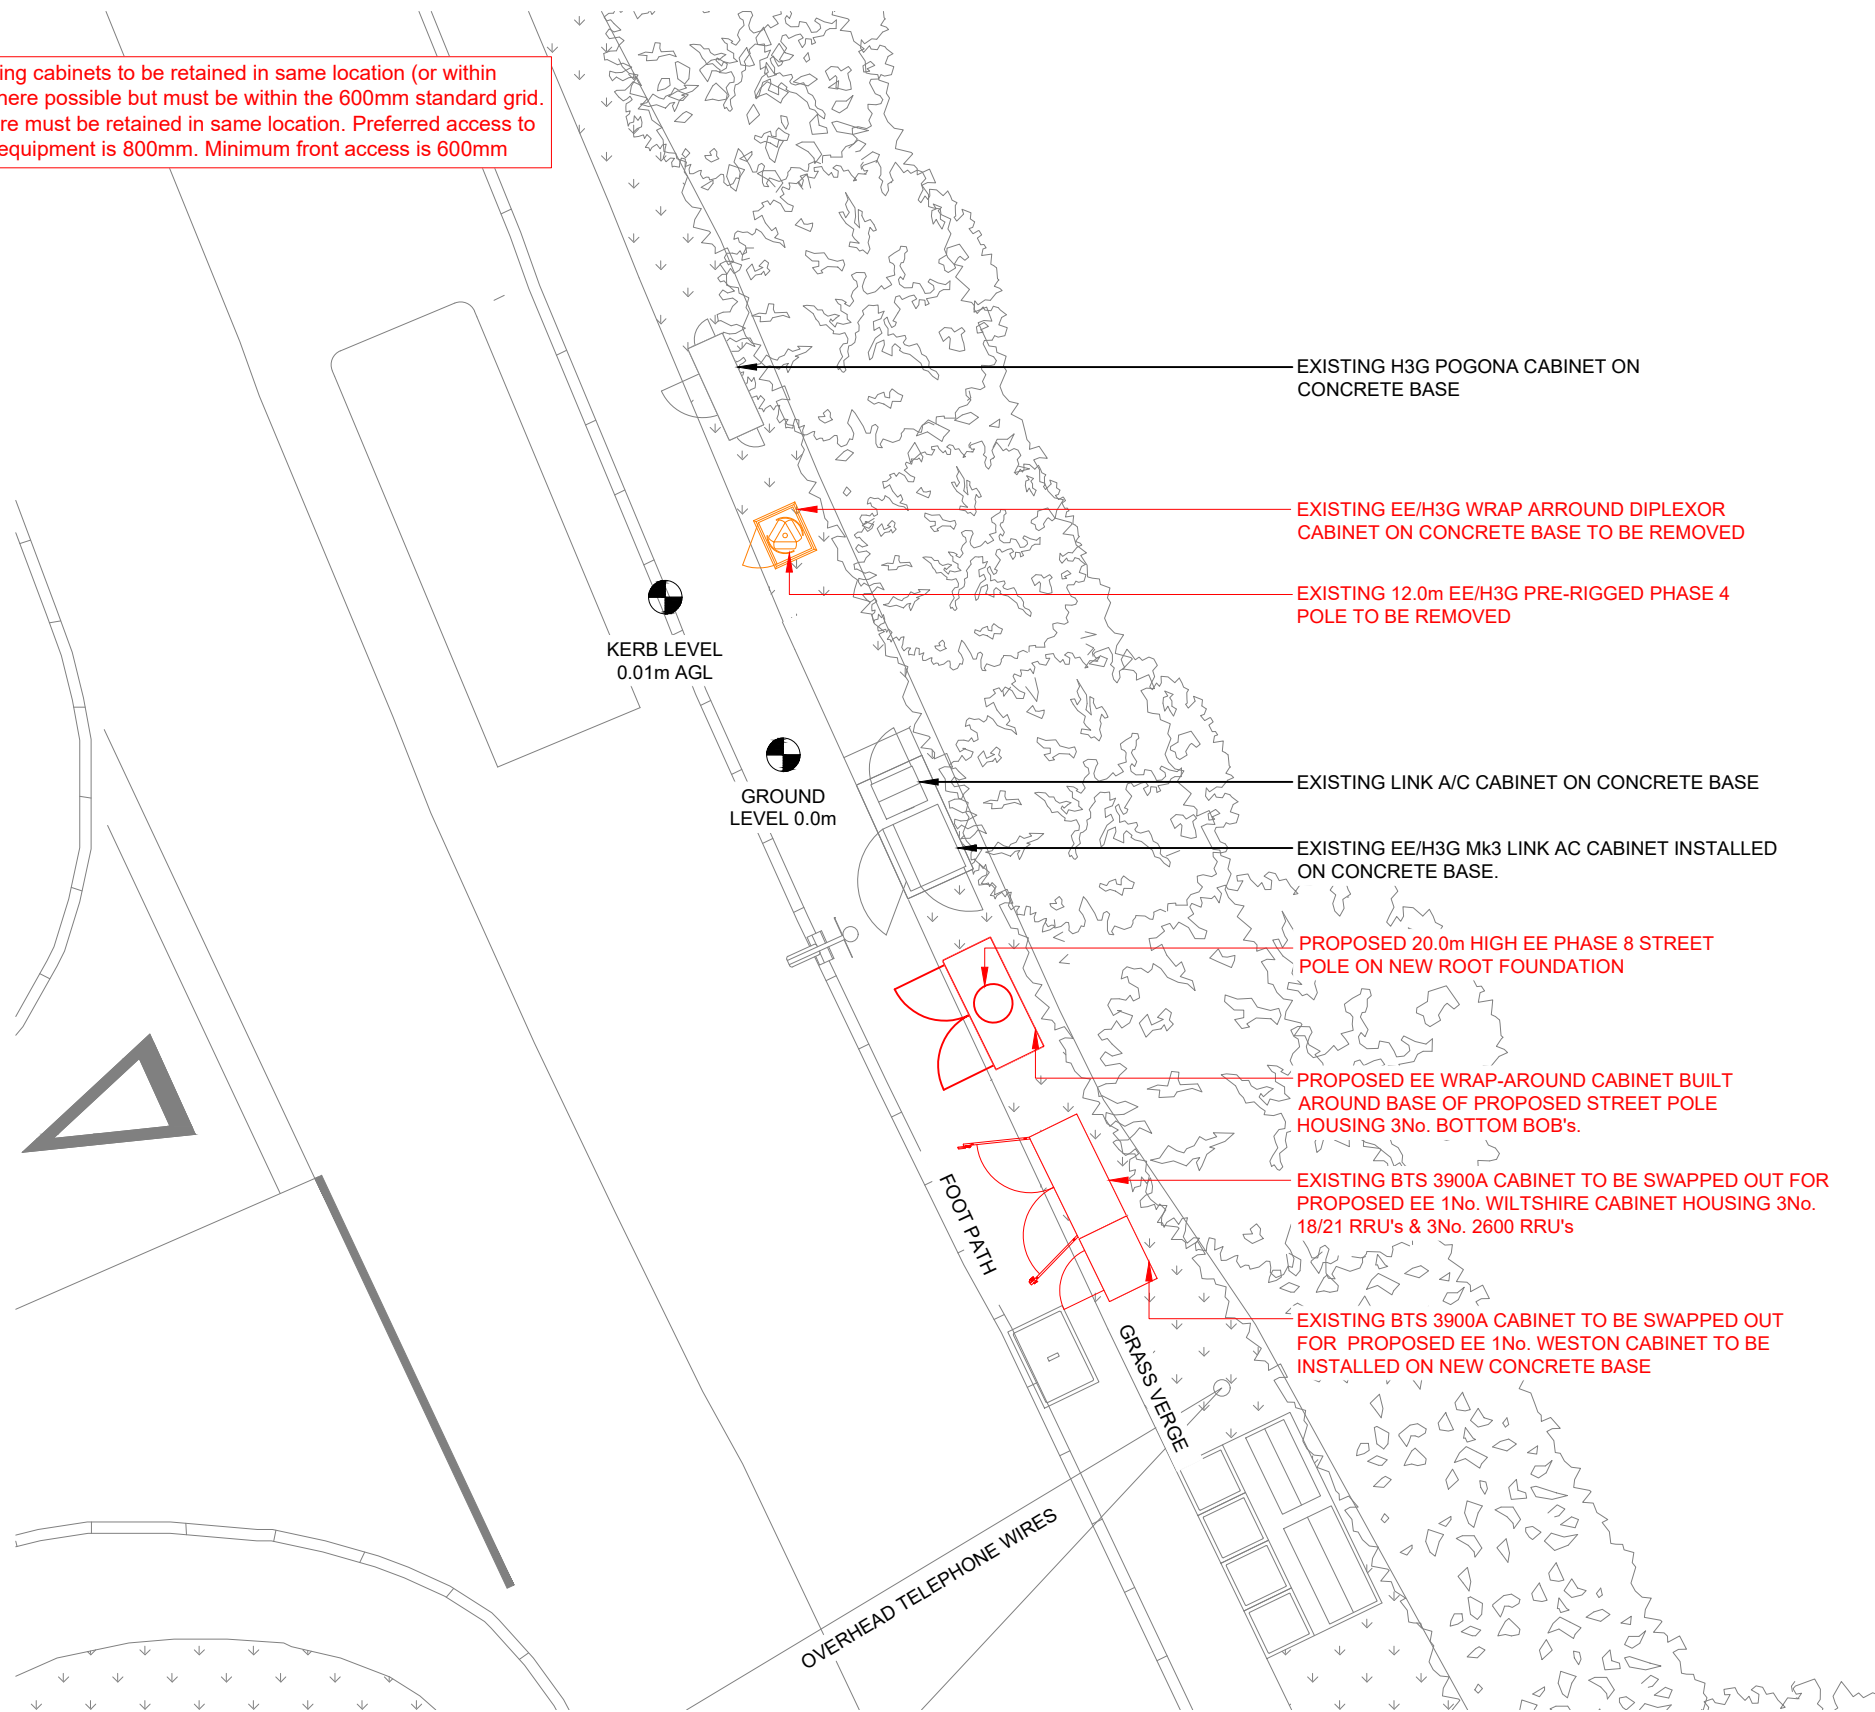

PROPOSED SITE LAYOUT

 

NOTES:

- ALL DIMENSIONS IN MM UNLESS OTHERWISE NOTED.

EQUIPMENT CABINETS			
EXISTING	PROPOSED	TO BE REMOVED	TOTAL
5	3	1	7

Master: M001	MBNL / EE / H3G: MBNL	Project: VENDOR SWAP	Purpose of Issue: Planning	Issue: A
Date: 10/10/2020	Drawn: C.D.N	Revision / Upgrade Description: First Issue		
Checked: S.Farrell	Approved: S.Farrell			



Hatfield Business Park
Hatfield
Hertfordshire
AL10 9BW

Tel: 01707 315000
Fax: 01707 319001

Design Consultant & Principal Contractor:



Unit E, Madison Place, Northampton Road,
Manchester, M40 5AG
Tel: 0161 785 4500 Fax: 0161 785 4501
Web: www.clarke-telecom.com

Site Name:	MENDIP
------------	--------

Site ID:	957324
----------	--------

Address:	LITTLE BUSHEY LANE BUSHEY WATFORD HERTFORDSHIRE WD23 4SB
----------	---

Title:	300 SITE LAYOUT
--------	-----------------

Project:	VENDOR SWAP
----------	-------------

Purpose of Issue:	GENERAL ARRANGEMENT
-------------------	---------------------

EE Cell ID: 50715	MBNL Cell ID: HTM006	3UK Cell ID: WD0096
-------------------	----------------------	---------------------

Master Drawing No: 957324_HTM006_50715_WD0096_M001	Issue: A
--	----------