
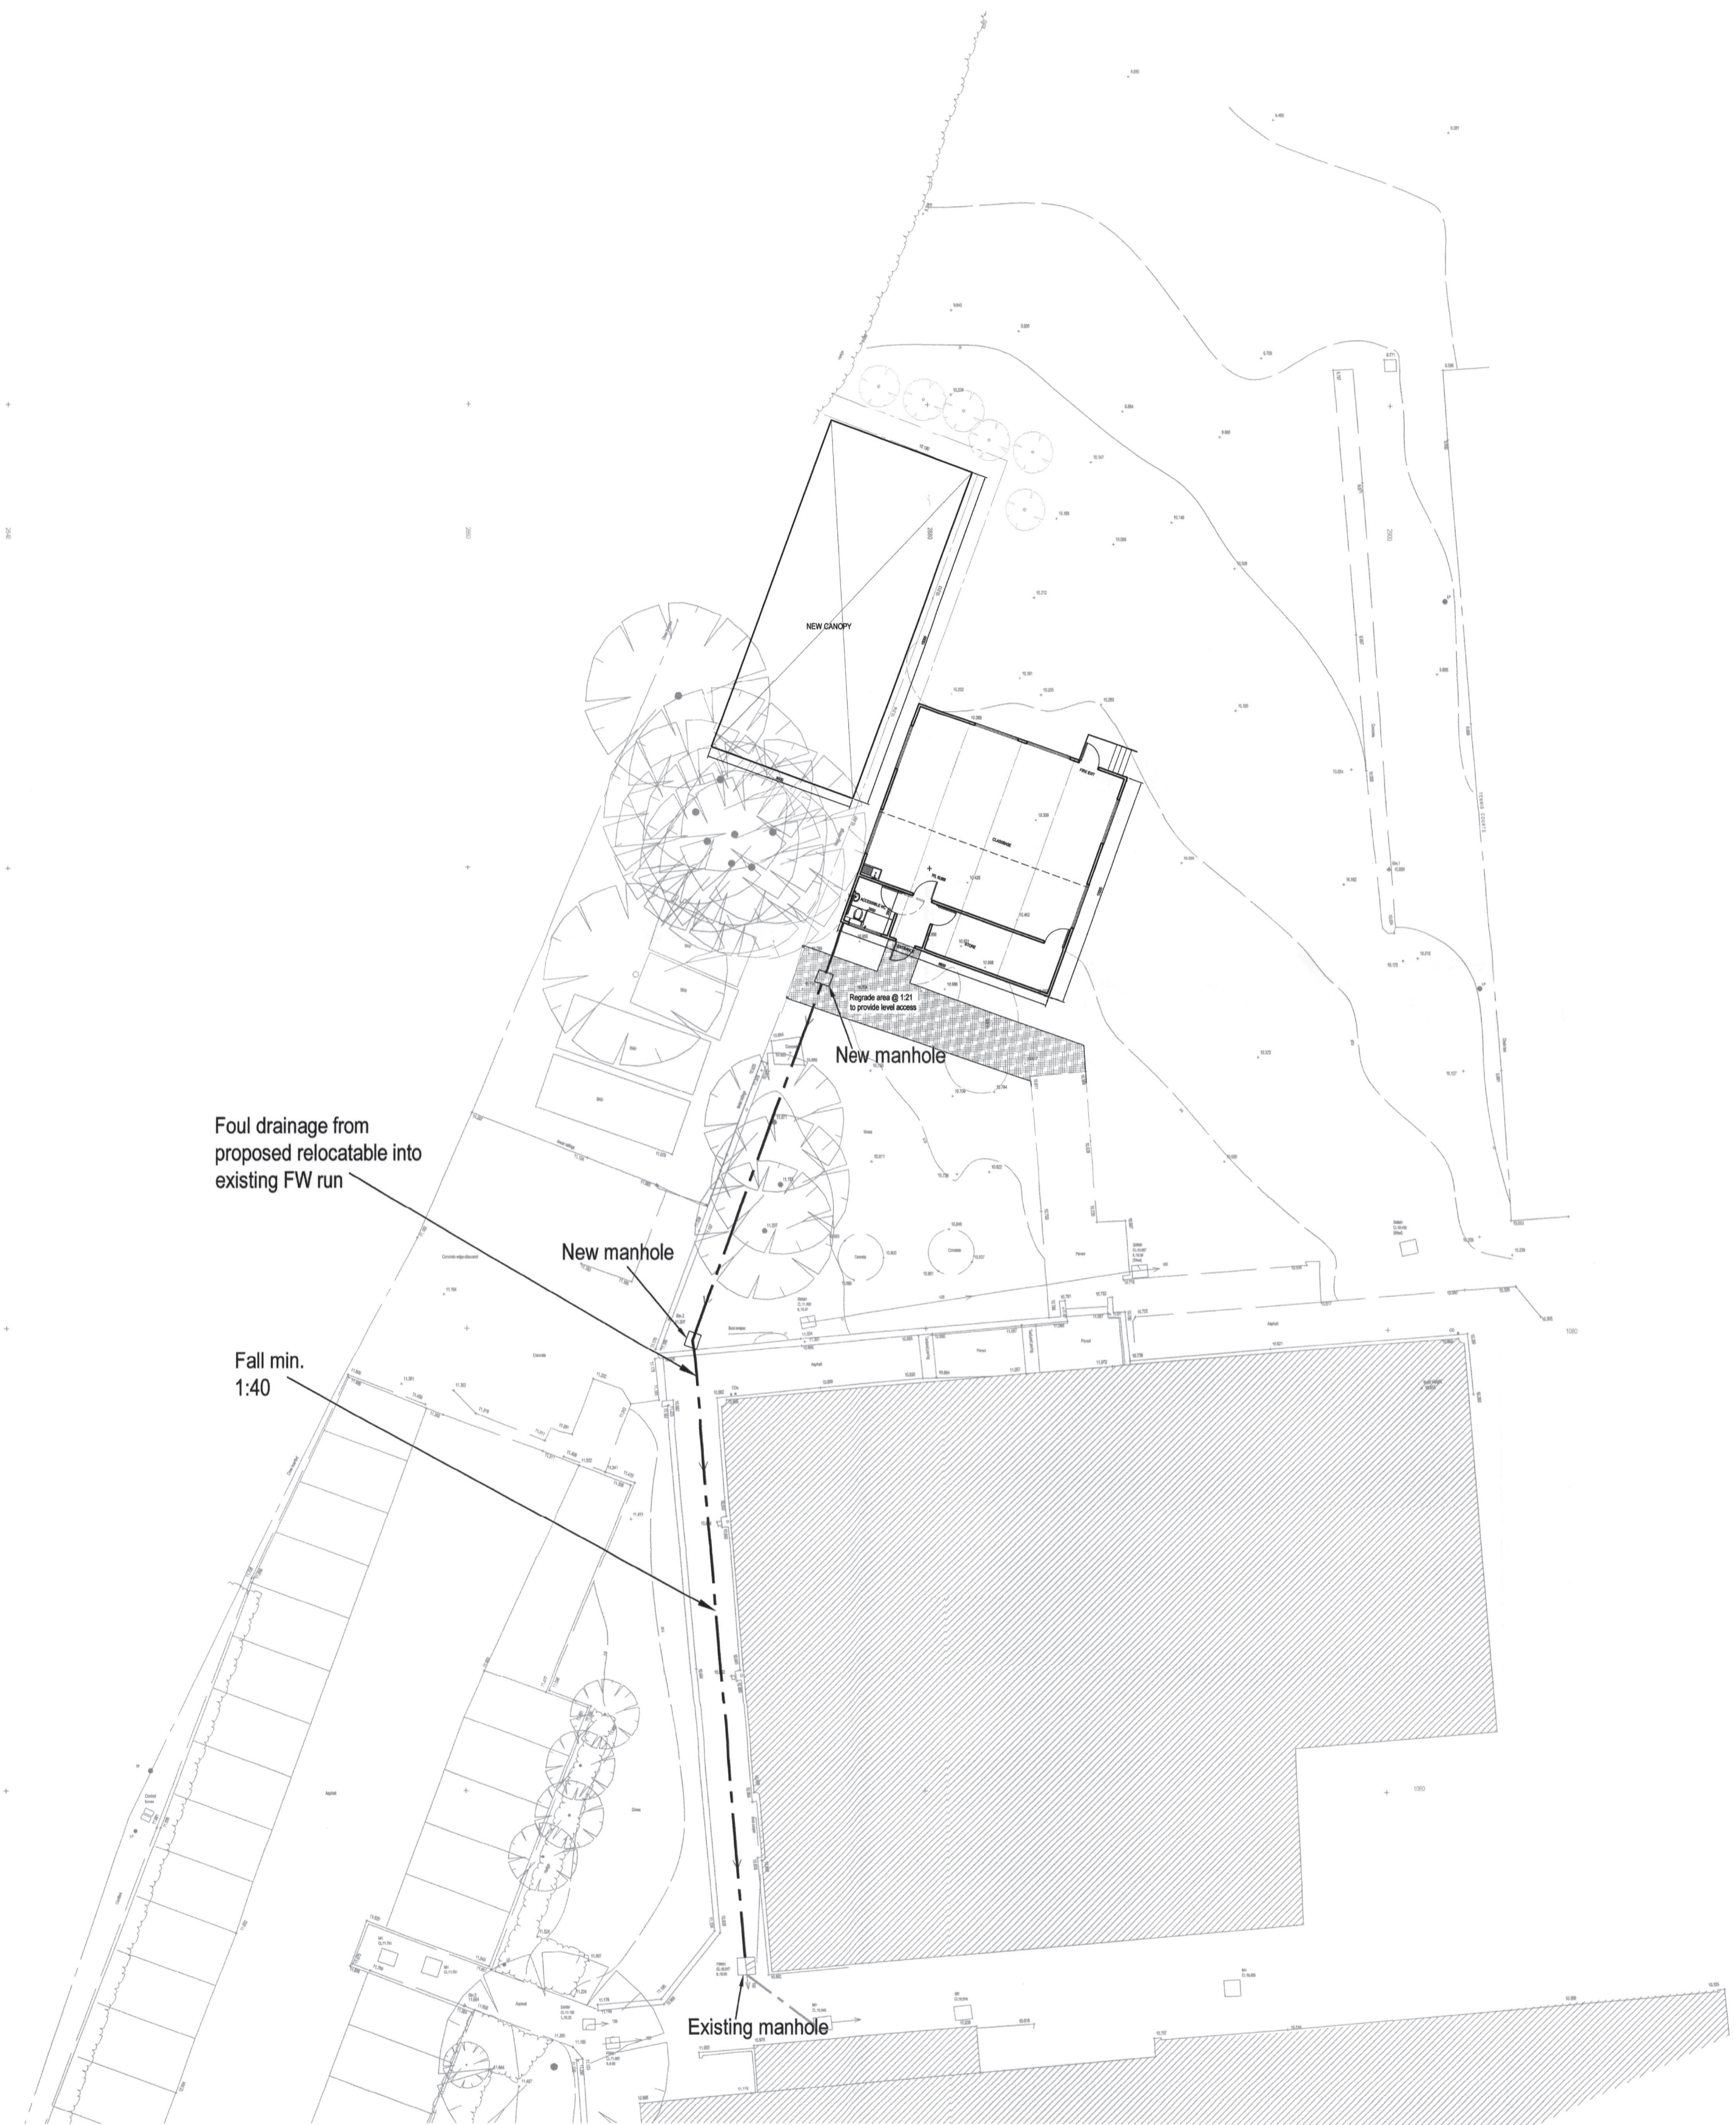


NOTES  
 1. DO NOT SCALE FROM THIS DRAWING.  
 2. THIS DRAWING IS TO BE READ IN CONJUNCTION WITH THE SPECIFICATION.

**PART SITE PLAN**

Scale 1:200

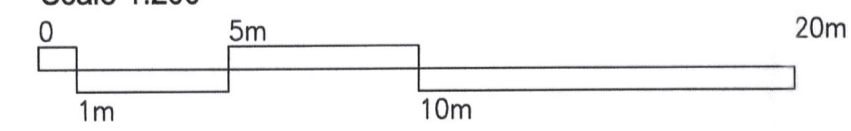

CLIENT  
 BEAUCHAMPS HIGH SCHOOL  
 WICKFORD

PROJECT  
 TEMPORARY CLASSROOM  
 PLANNING PERMISSION RENEWAL

TITLE  
 DRAINAGE LAYOUT

SCALE	ORIGINAL SIZE	DRAWN BY
	A1	CHECKED BY

PROJECT/DRAWING NO	DATE
009/21/03	MARCH 2021