


Proposed First Floor Layout Scale 1:50

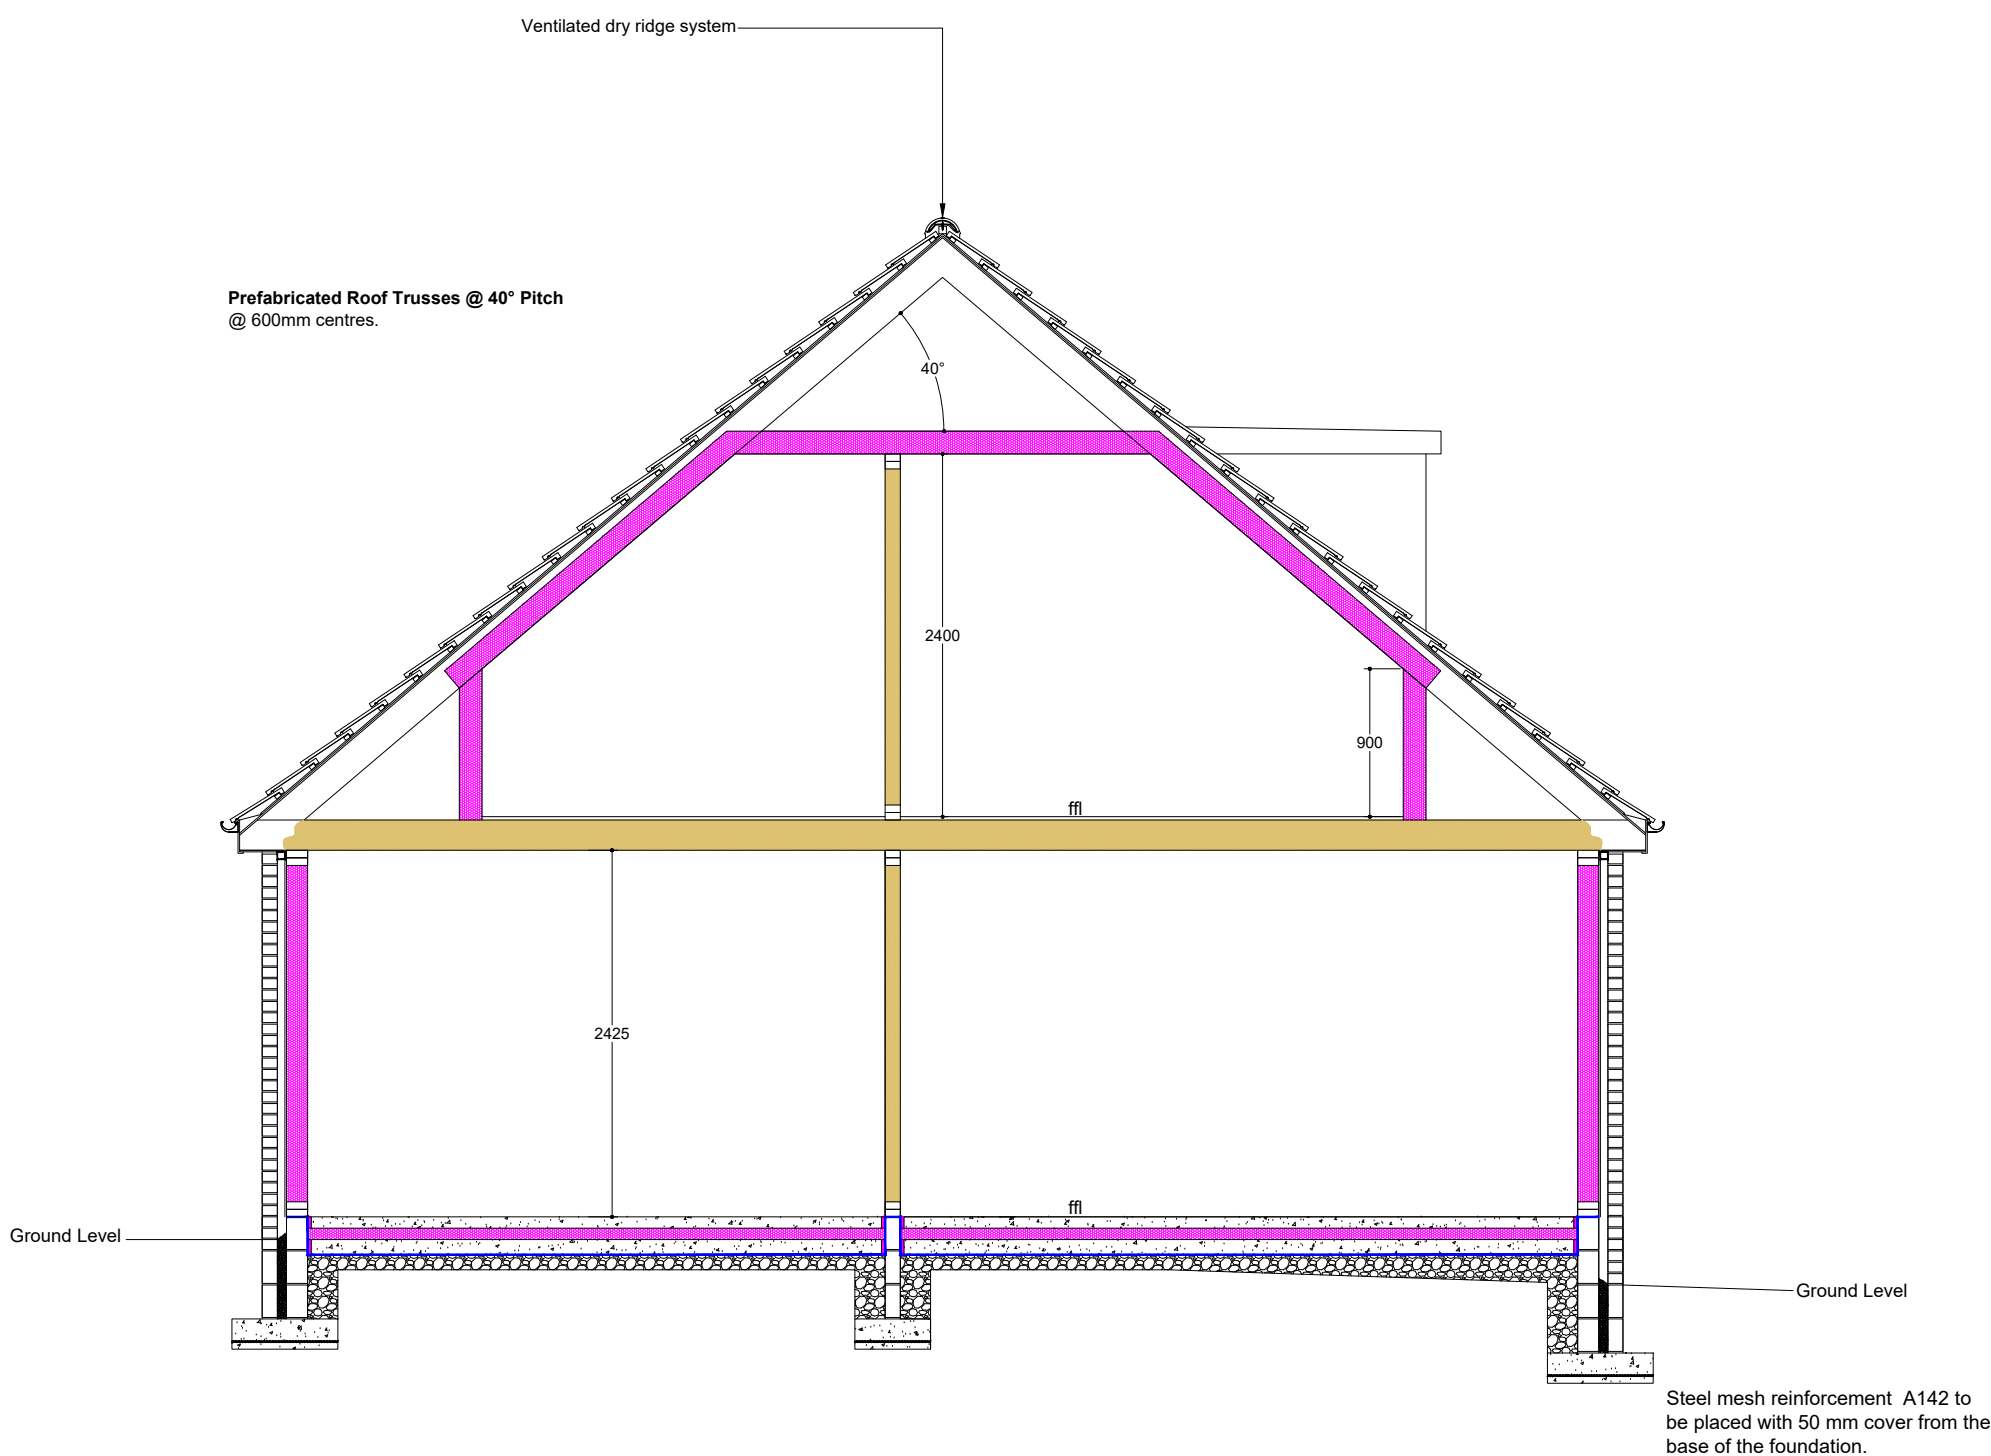

Section AA Scale 1:50

ELECTRICAL LEGEND	
	Double low level socket
	Double high level socket
	Single low level socket
	1 way switch
	2 way switch
	Mains operated smoke detector
	Cooker Unit socket
	Television socket
	Electrical consumer unit switch gear

CP DESIGN

PHONE-(01776) 500062
07999791665

CLIENT: **Messrs Preston.**

Project: **Erection of 2 Dwellinghouses at
Glen Road - Leswalt.**

Drawing NO: 5 **Proposed First Floor
Layout Plot 2.**

Scale: Annotated	Drawn by : Clarke Preston	Date: 15.05.2021
----------------------------	-------------------------------------	---------------------

DO NOT SCALE FROM DRAWINGS.

ALL DIMENSIONS TO BE CHECKED ON SITE PRIOR TO THE START
OF ANY WORK AND ANY DISCREPANCIES NOTIFIED IN WRITING.

REFER TO ENGINEERS DRAWINGS FOR ALL STRUCTURAL DETAIL.

ALL BUILDING WORKS TO COMPLY IN ACCORDANCE WITH THE
BUILDING SCOTLAND REGULATIONS 2003.

