


ISO A1 694mm x 841mm  
 Approved: VB  
 Checked: JW  
 Designer: UM  
 Project Management Initials:  
 File name: \\M:\MAN-00\JOB\_NOZ\7065487 BRUNSWICK PFI PLANNING\08 DRAWINGS\CIVIL\SITE SURVEY\ZONE 2 S278 DRAWINGS\CIVIL\SITE SURVEY\ZONE 2 S278 DRAWINGS\PHASE W60470359-ACM-BS278-DR-Z2-35.DWG

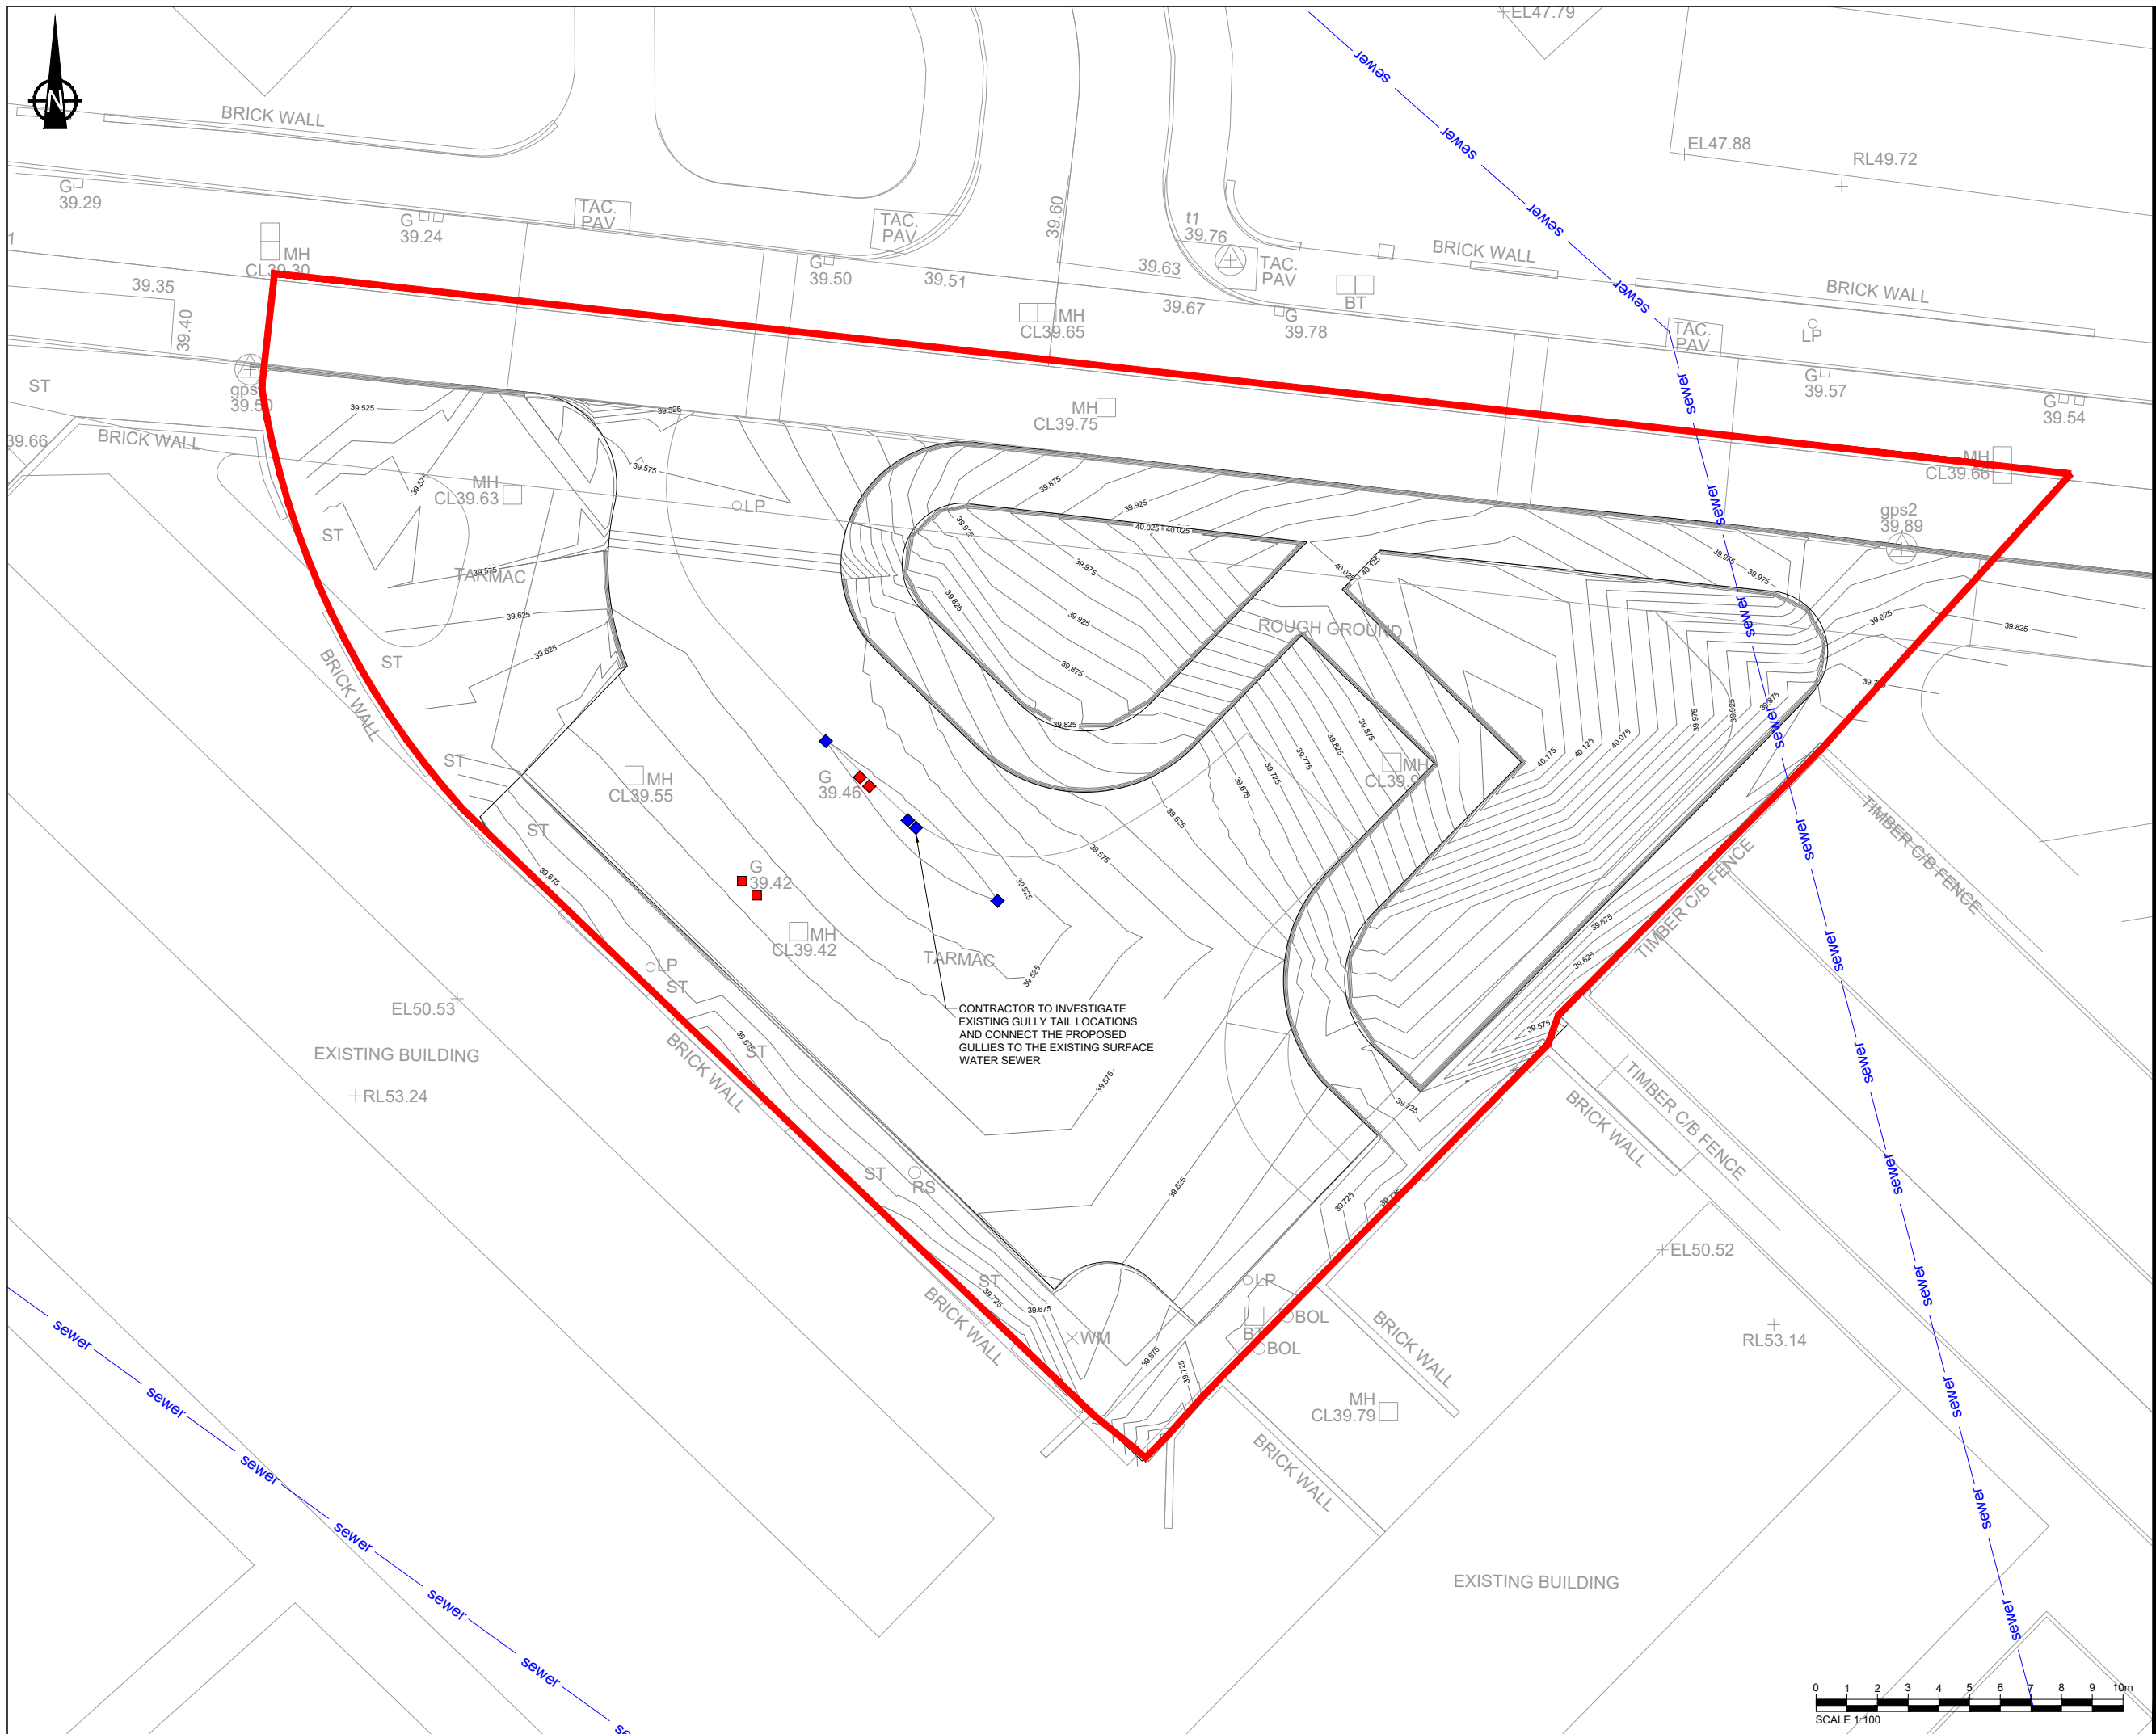

**PROJECT**  
 Brunswick PFI



**CONSULTANT**  
 AECOM Manchester  
 1 New York Street,  
 Manchester, M1 4HD  
 0161 907 3500 tel 0161 907 3599 fax  
 www.aecom.com

- NOTES**
1. DRAWN TO 1:100 SCALE @ A1
  2. IF RECEIVED ELECTRONICALLY, IT IS THE RECIPIENTS RESPONSIBILITY TO PRINT TO THE CORRECT SCALE. ONLY WRITTEN DIMENSIONS SHALL BE USED.
  3. THIS DRAWING IS FOR TECHNICAL APPROVAL ONLY.
  4. ALL WORKS TO BE INSTALLED IN LINE WITH MANCHESTER CITY COUNCIL STANDARD DETAILS.

- KEY**
- WORKS BOUNDARY
  - sewer INDICATIVE EXISTING UU SEWER LOCATION (UU RECORDS)
  - EXISTING GULLY AND CONNECTION TO BE REMOVED
  - PROPOSED RELOCATED GULLY


**ISSUE/REVISION**

 IR	DATE	DESCRIPTION
P1	24.02.21	PRELIMINARY ISSUE

**PROJECT NUMBER**  
 60470359

**SHEET TITLE**  
 BRUNSWICK SECTION 278  
 ZONE 2 - PHASE W  
 DRAINAGE LAYOUT

**SHEET NUMBER**  
 60470359-ACM-BS278-DR-Z2-35 P1



This drawing has been prepared for the use of AECOM's client. It may not be used, modified, reproduced or relied upon by third parties, except as agreed by AECOM or as required by law. AECOM accepts no responsibility, and denies any liability whatsoever, to any party that uses or relies on this drawing without AECOM's express written consent. Do not scale this document. All measurements must be obtained from the stated dimensions.