


Indicative Lighting layout 1:200

Room Lighting

Task Lighting

Display Lighting

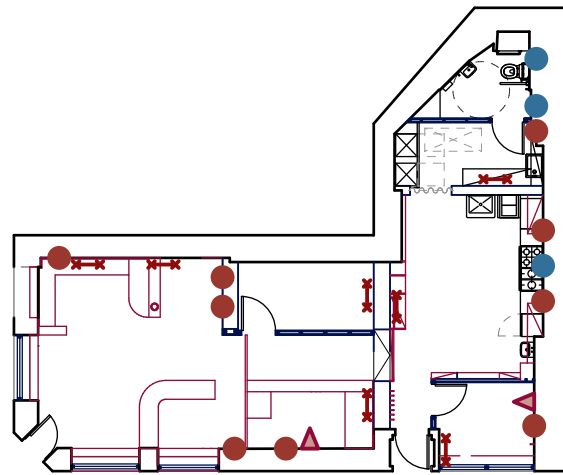


 
Indicative Services layout 1:200

Small Power

Data

Space Heating

Water

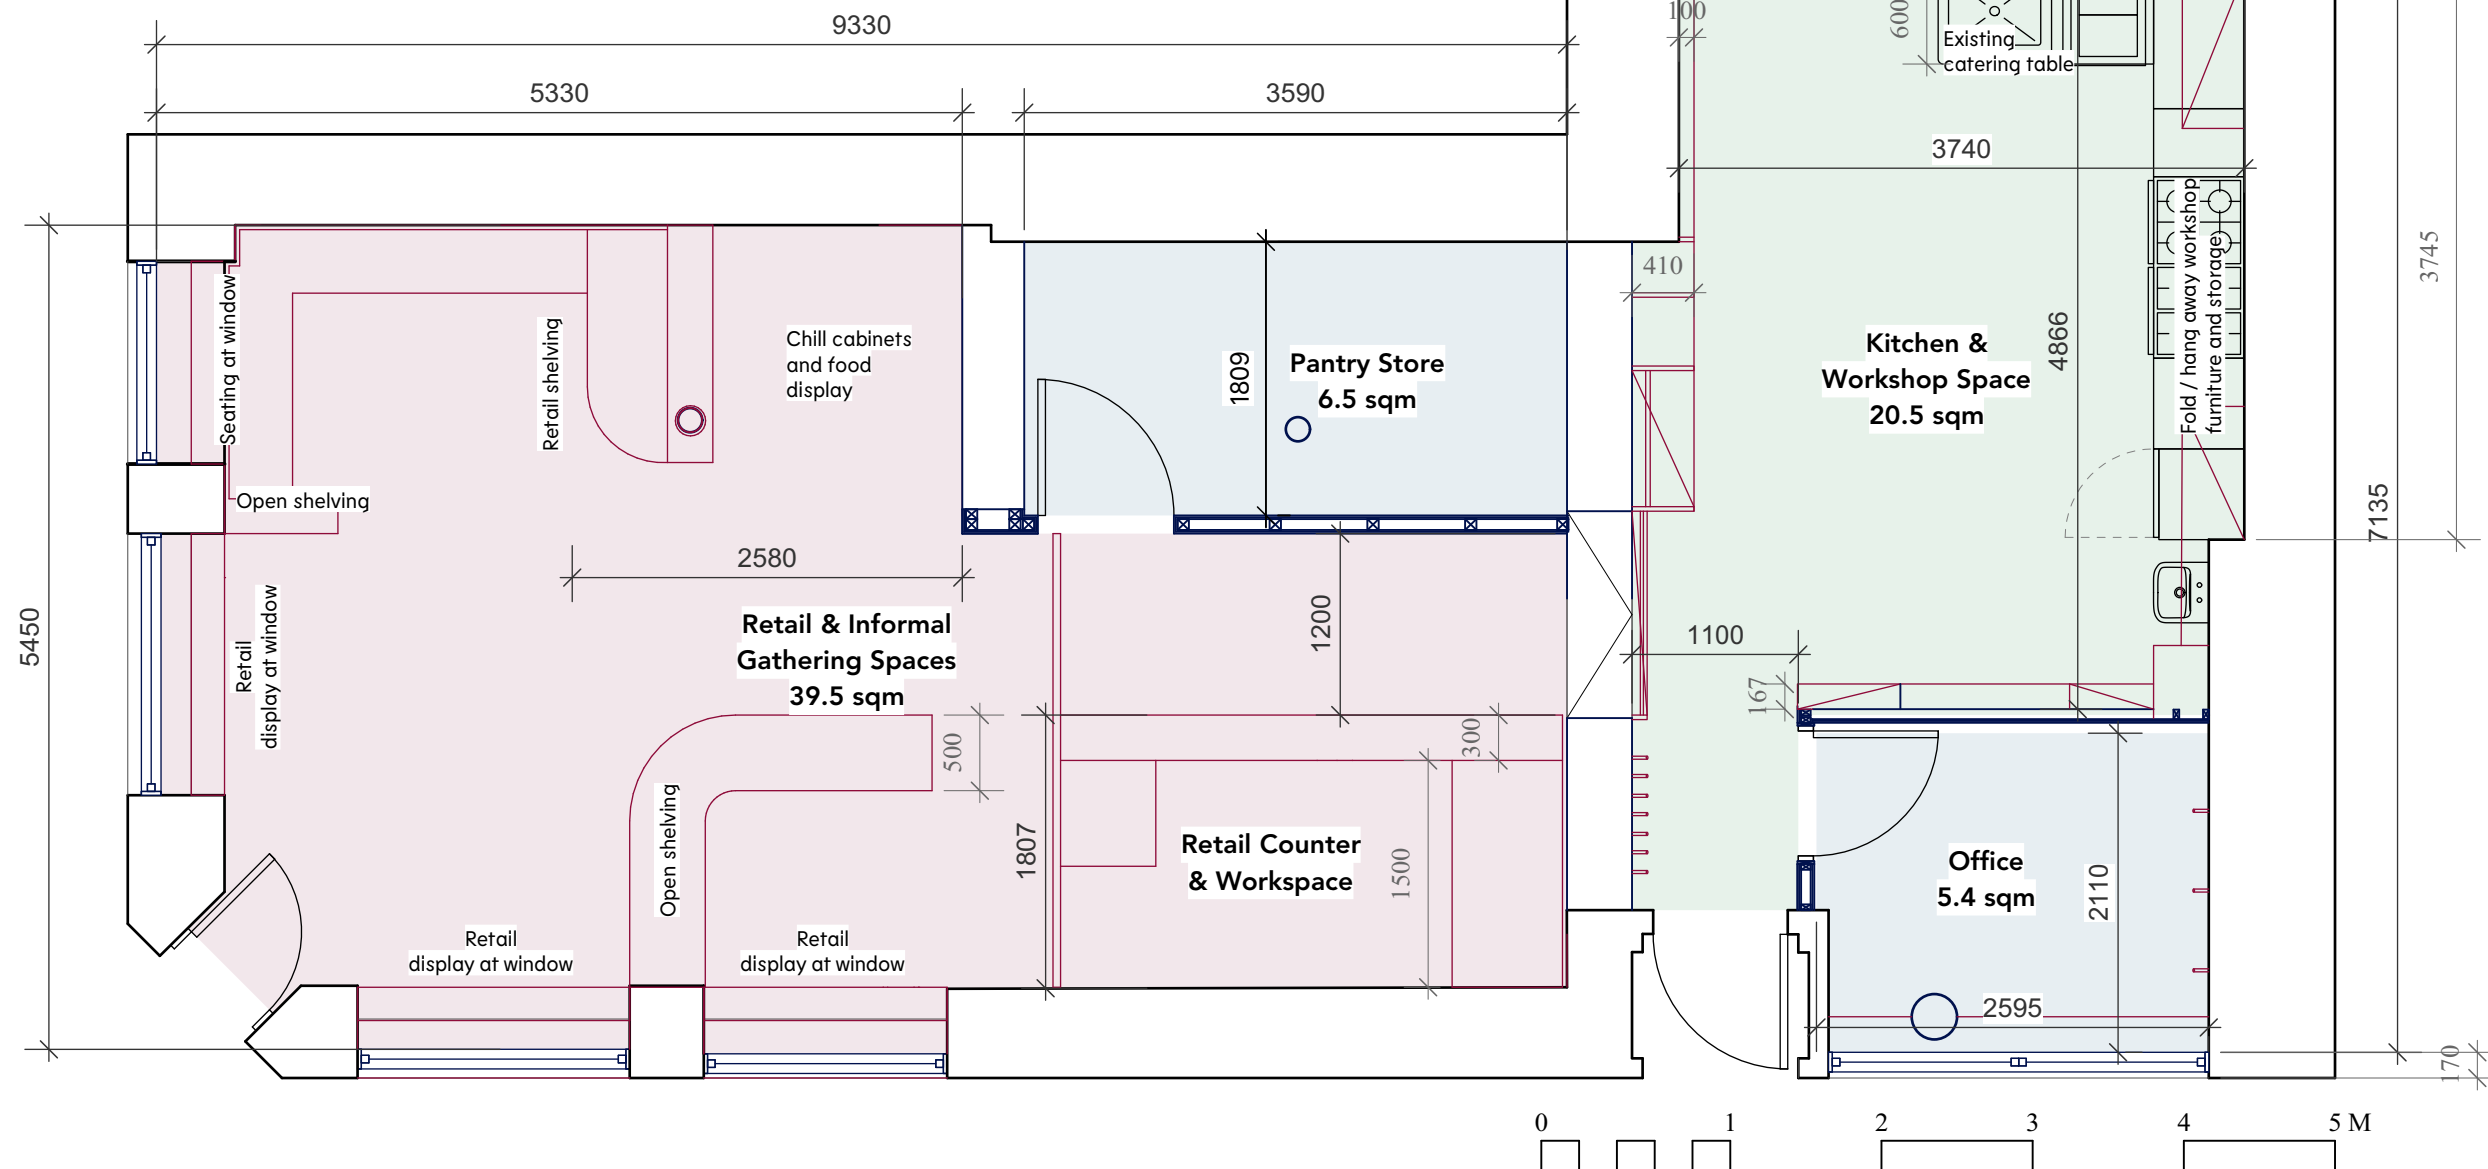

Plan, As Proposed 1:50



DO NOT SCALE FROM THIS DRAWING

ALL DIMENSIONS TO BE CHECKED ON SITE PRIOR TO THE START OF ANY WORK
AND ANY DISCREPANCIES MUST BE NOTIFIED IN WRITING

REFER TO ENGINEER'S DRAWINGS FOR ALL STRUCTURAL, HEATING, LIGHTING, POWER,
EXTERNAL AND UNDERGROUND DRAINAGE AND VENTILATION INFORMATION

ALL BUILDING WORKS COMPLY IN ALL RESPECTS TO CURRENT
BUILDING STANDARDS FOR COUNTRY IN WHICH SITE IS LOCATED

Revision Date	Revision Note

Job Reference	Drawing Number	Revision
#21008	GA(P)-001	

Scale	Paper Size
Various	A3

Drawing Name		
Plan, As Proposed		

Drawn By	Checked	Date Drawn
ZG	BT	16/03/2021

Project	
EHA Food Hub	

Client	
Elderpark Housing Association	

New Practice

3 Ross Street
Glasgow
G1 5AR

+44 (0) 141 226 4092

info@new-practice.co.uk
www.new-practice.co.uk