


**PROPOSED FLOOR PLAN.**

FOR VELUX ROOF UNITS CUT RAFTERS AS REQUIRED AND INSERT NOGGINS. INSTALL VELUX ROOF LIGHT IN ACCORDANCE WITH MANUFACTURERS INSTRUCTIONS COMPLETE WITH FLASHING KIT FOR WEATHER PROTECTION.

SCALE BAR. 1:50

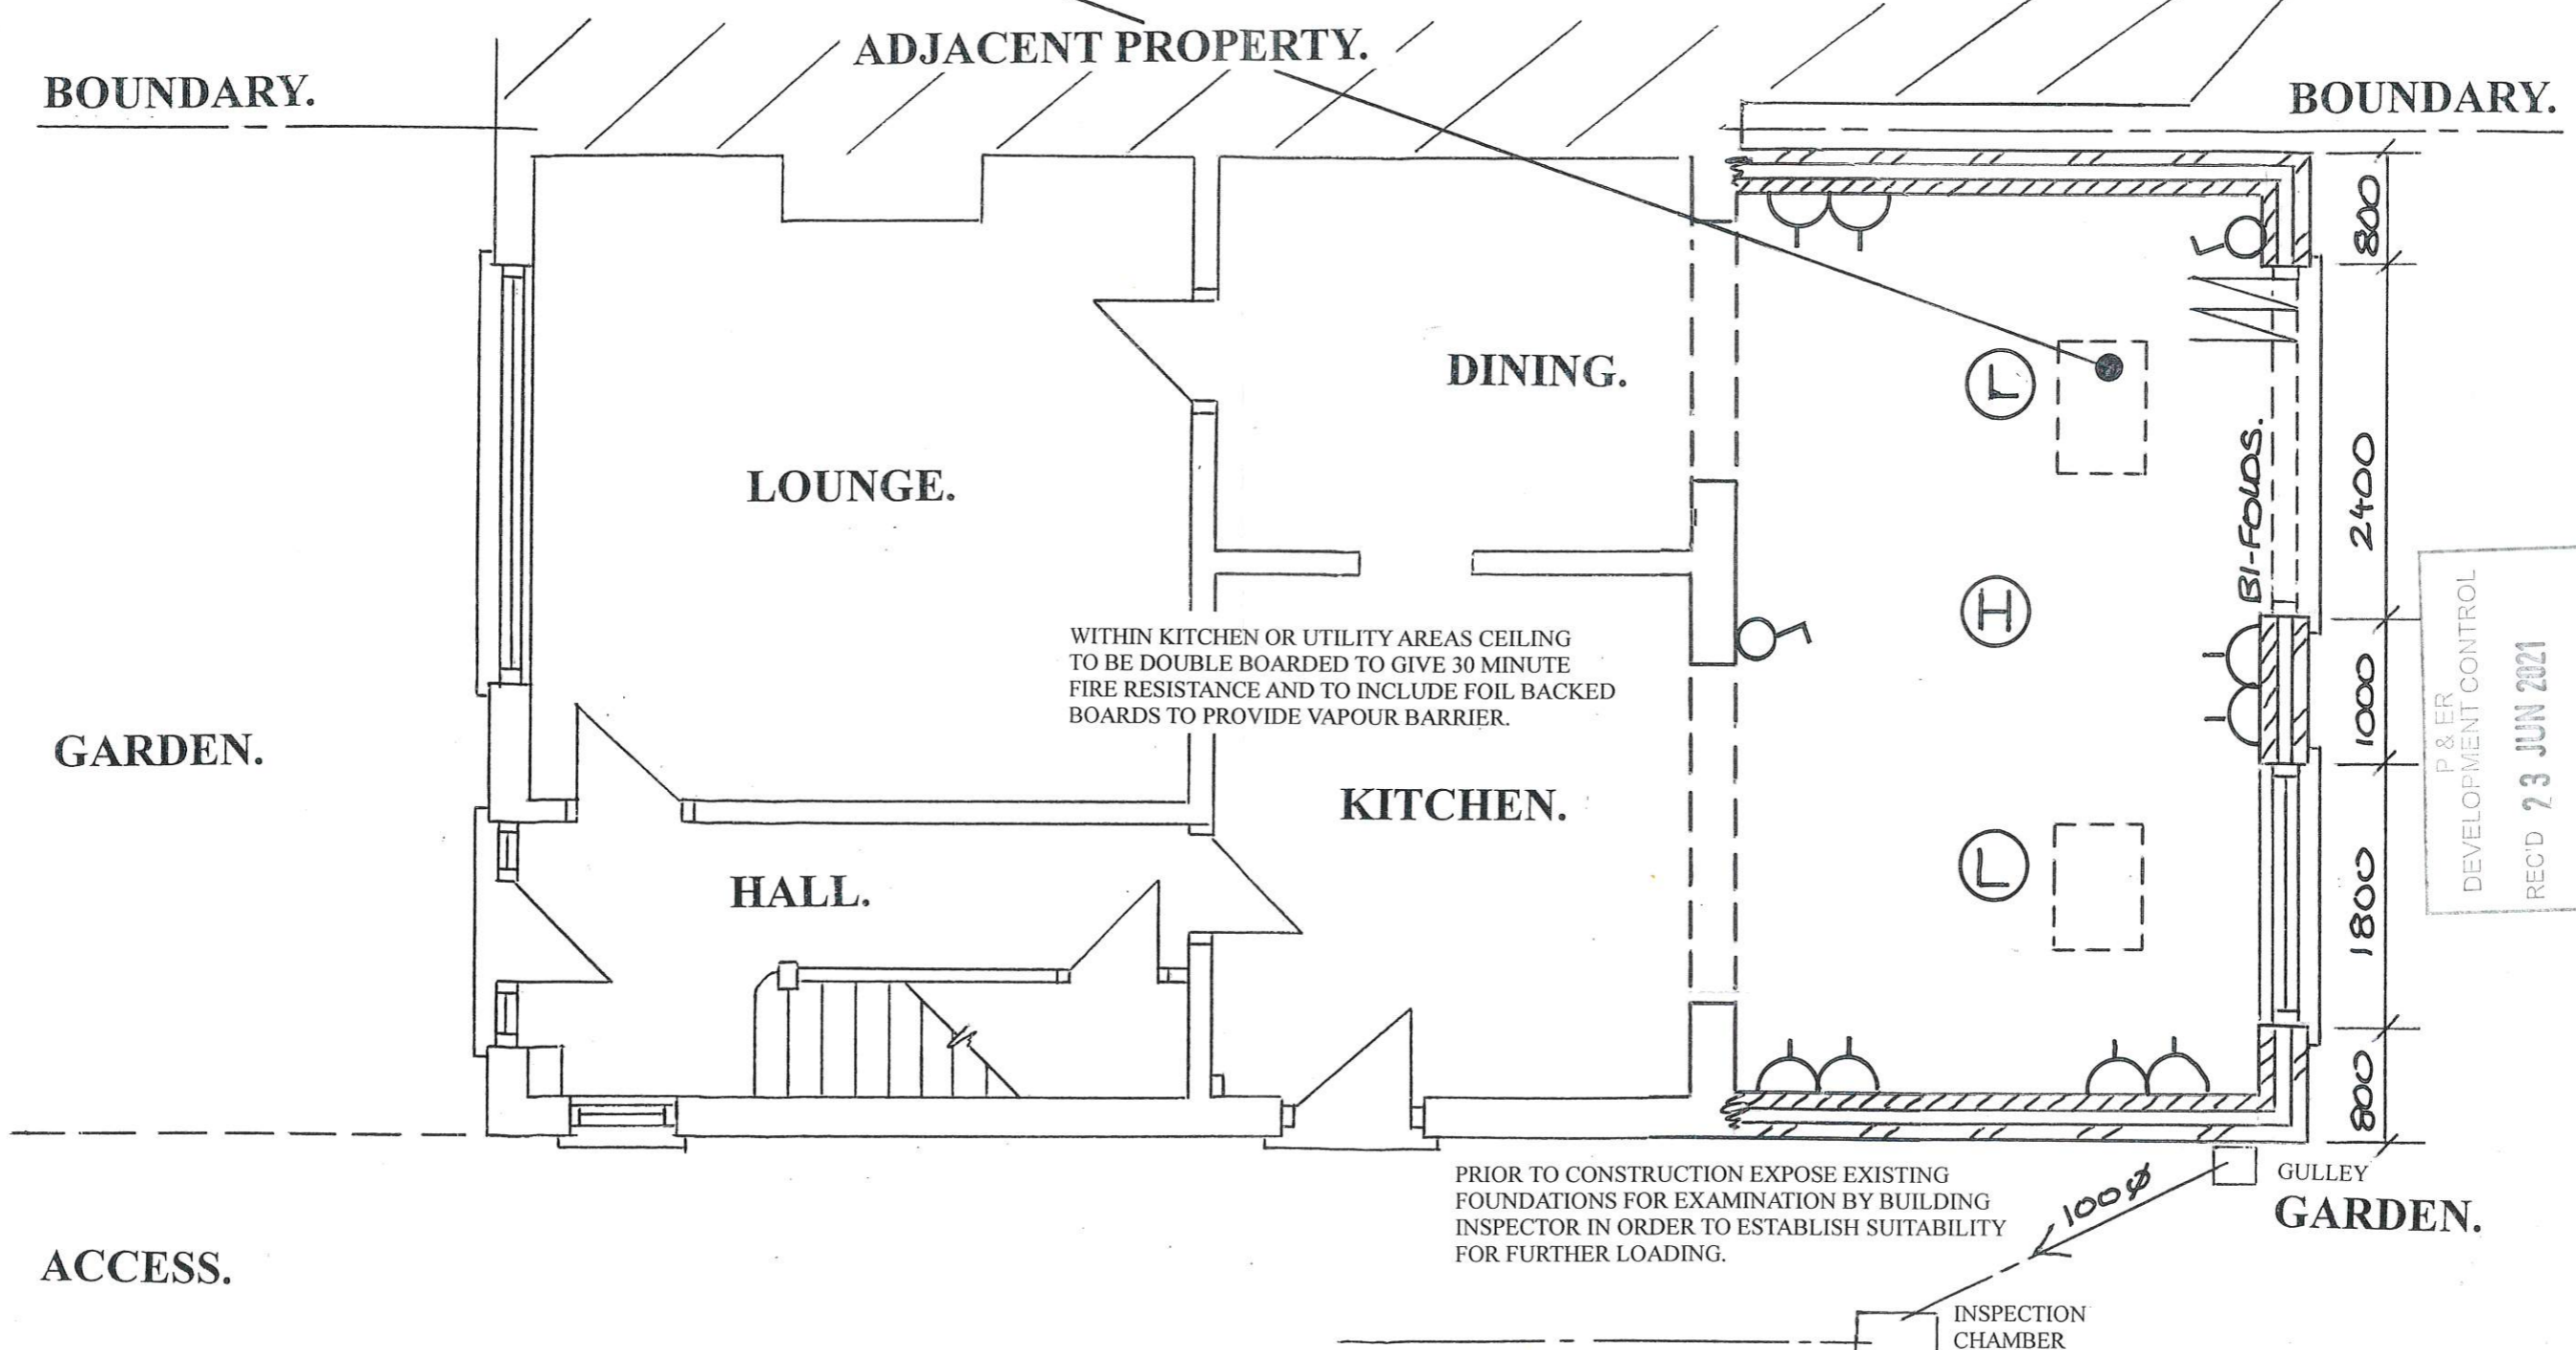

**PLANMAN**  
**BUILDING DESIGN SERVICES.**  
 No 10 MILTON STREET, GOOLE, EAST YORKSHIRE. DN14 6EL.  
 TEL; 07901 792867. E-MAIL; [planman50@yahoo.co.uk](mailto:planman50@yahoo.co.uk).

CLIENT: MS BRENN A HOOD.  
 PROJECT; PROPOSED EXTENSION.

DWG No; MC2A  
 DATE: 25.5.21  
 SCALE: 1:50