




Section - Existing Lighting
Scale 1:200

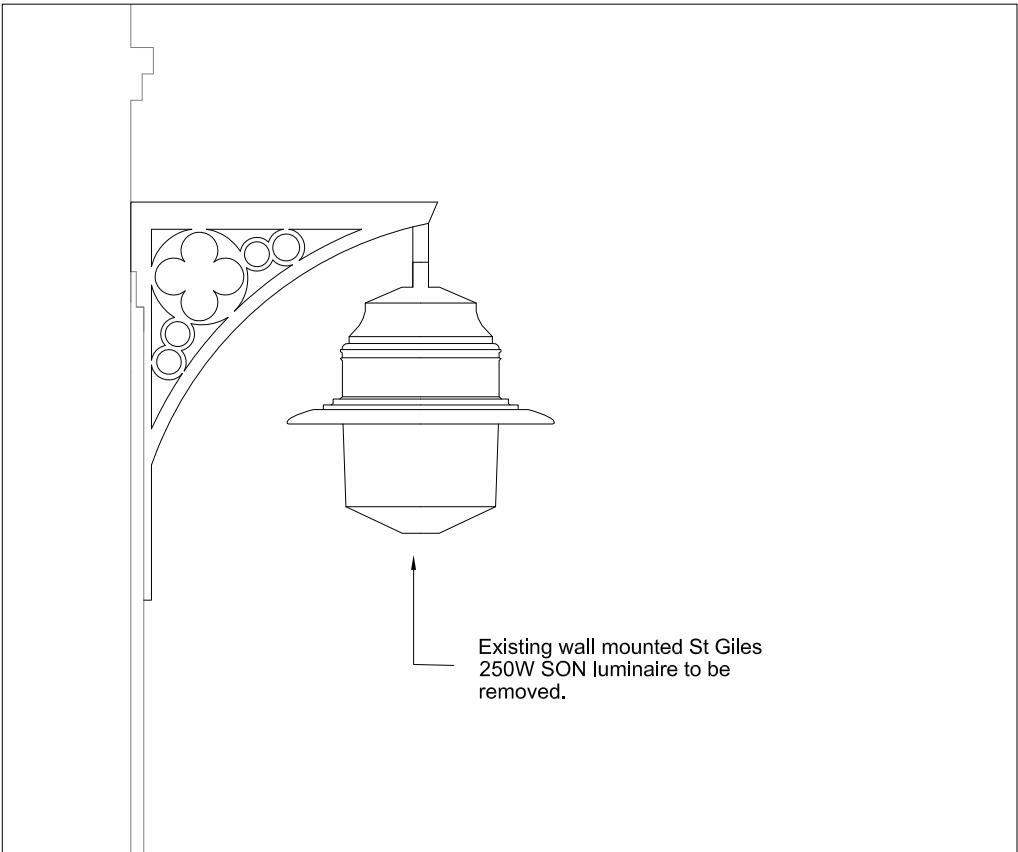


Side Elevation - Existing Luminaire and Bracket
Scale 1:20

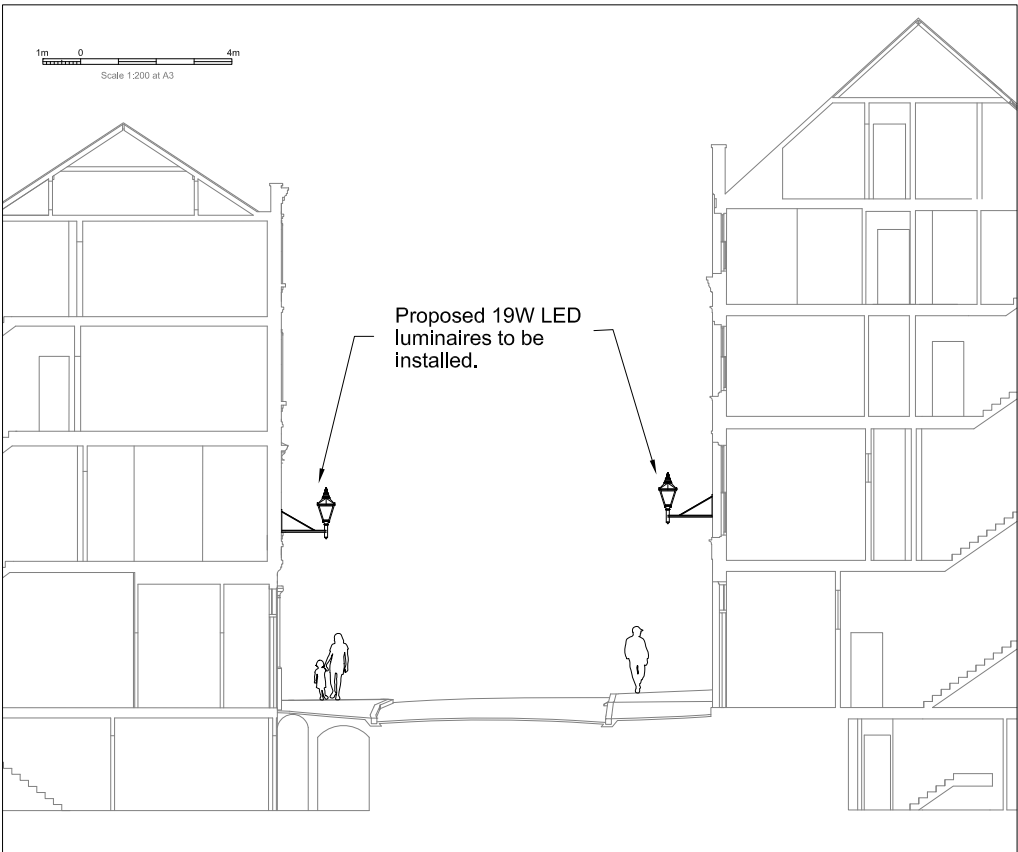


Section - Proposed Lighting
Scale 1:200

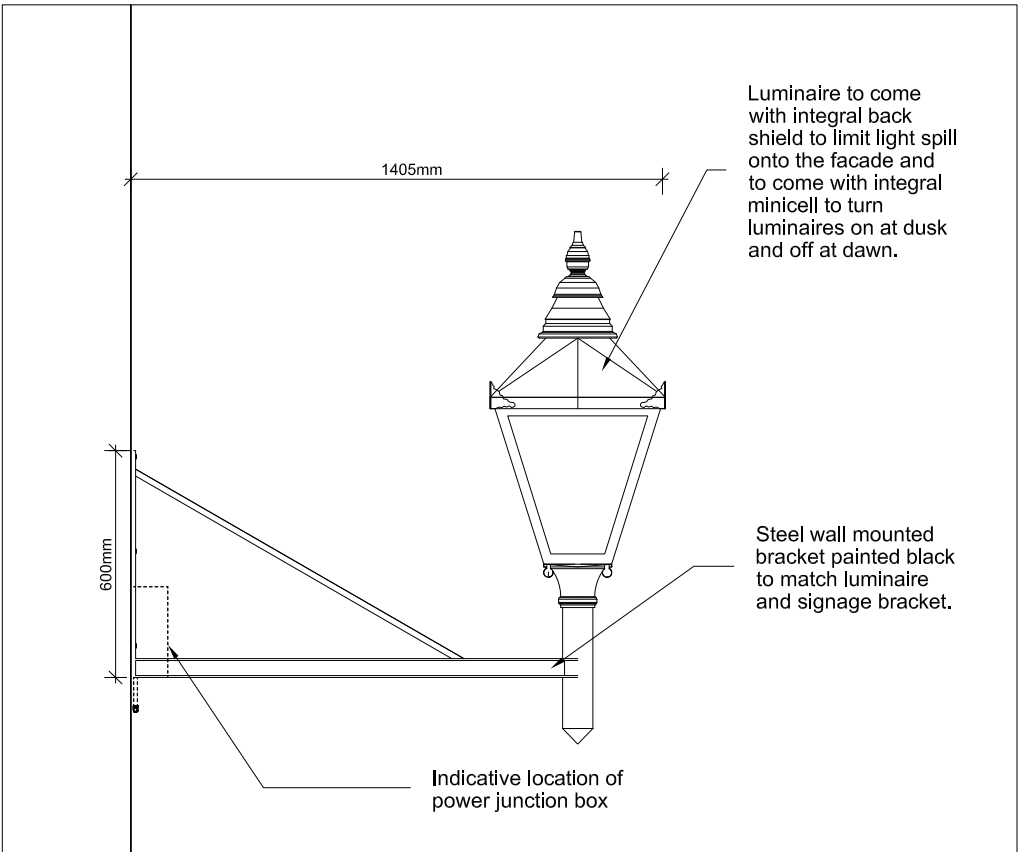

Side Elevation - Proposed X1 Luminaire and Bracket
Scale 1:20

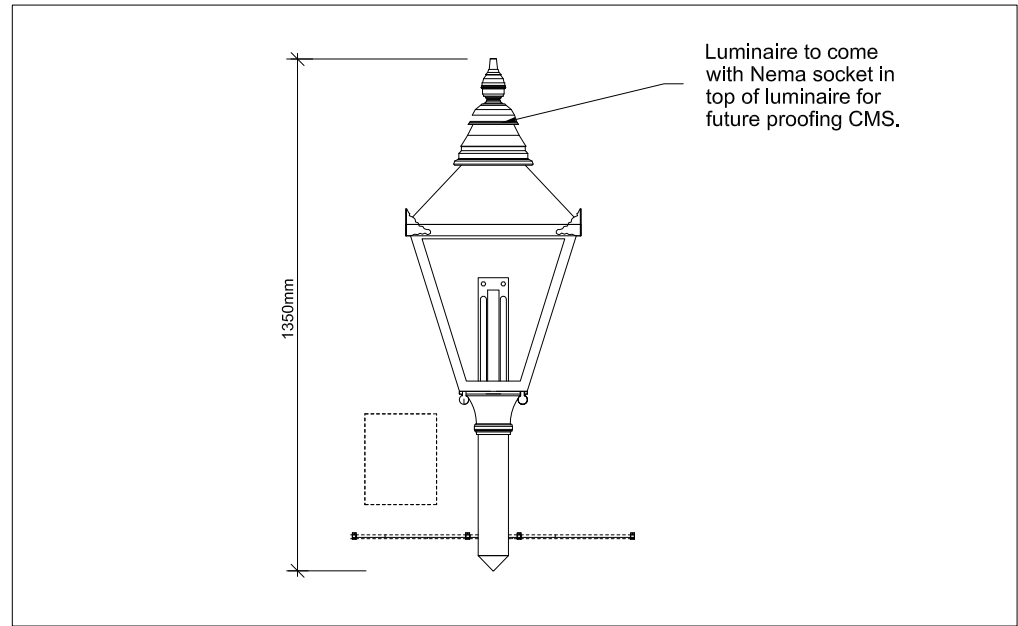

Front Elevation - Proposed X1 Luminaire and Bracket
Scale 1:20

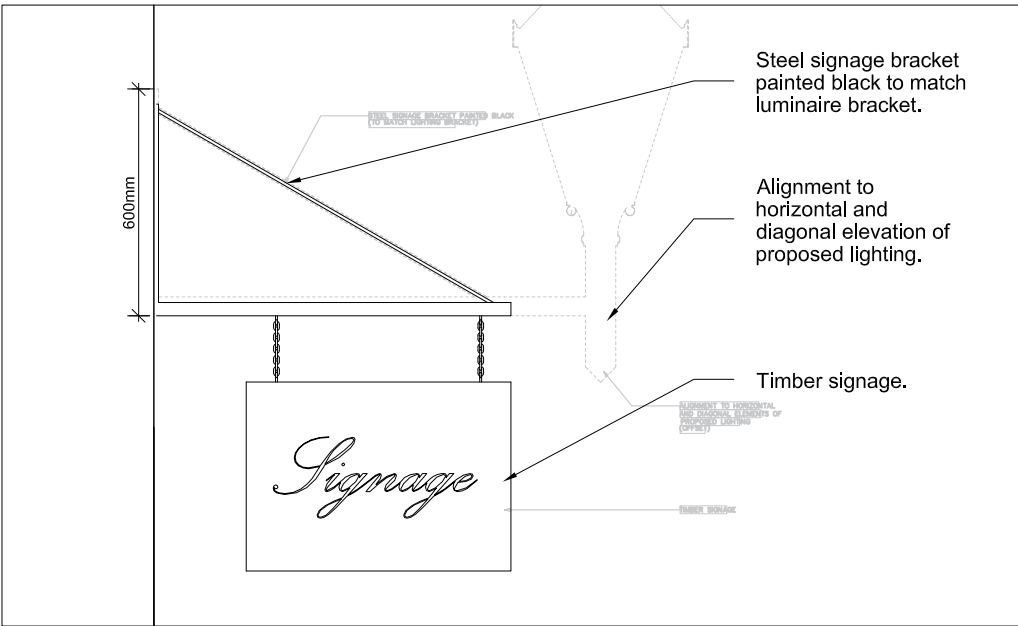

Side Elevation - Proposed X3 Signage and Bracket
Scale 1:20

STUDIO DEKKA LIMITED SHALL HAVE NO RESPONSIBILITY FOR ANY USE MADE OF THIS DOCUMENT OTHER THAN FOR THAT WHICH IT WAS PREPARED AND ISSUED. ALL DIMENSIONS SHOULD BE CHECKED ON SITE. DO NOT SCALE FROM THIS DRAWING. ANY DRAWING ERRORS OR DIVERGENCES SHOULD BE BROUGHT TO THE ATTENTION OF STUDIO DEKKA LIMITED AT THE ADDRESS SHOWN.	REVISION / OBSERVATION		REV	BY	DATE	NOTES	PROJECT TITLE	PROJECT NO.	SCALE	DATE	DRAWN BY
	For Planning Information		JH	CS	05/06/17	TO BE READ IN CONJUNCTION WITH: DRG 1138_800 - Existing Lighting Layout - Plan DRG 1138_801 - Existing Lighting Layout - Elevations DRG 1138_802 - Proposed Lighting Layout - Plan DRG 1138_803 - Proposed Lighting Layout - Elevations SCH 1138_901 - Schedule of Luminaires	King Edward Street	1138_804	Various @A3	30 Aldershott Grove York YO23 1LB studio@studioddeka.com www.studioddeka.com	
	REV A - For Comment		JH	CS	07/06/18		Oriel College, University of Oxford	1138			
	REV B - For Comment		JH	CS	29/01/19						
	REV C - Issued for Planning		JH	CS	29/03/19						
	REV D - Issued for Planning		JH	CS	08/05/19						
	REV E - For Comment		JH	CS	31/05/19						
	REV F - Issued for Planning		JH	CS	05/07/19						
	REV G - Issued for Planning		JH	CS	14/08/20						
	REV H - Issued for Planning		JH	CS	18/06/21						
	REV I - Issued for Planning		JH	CS	30/07/21						
						Existing and Proposed Lighting Details					