
 
 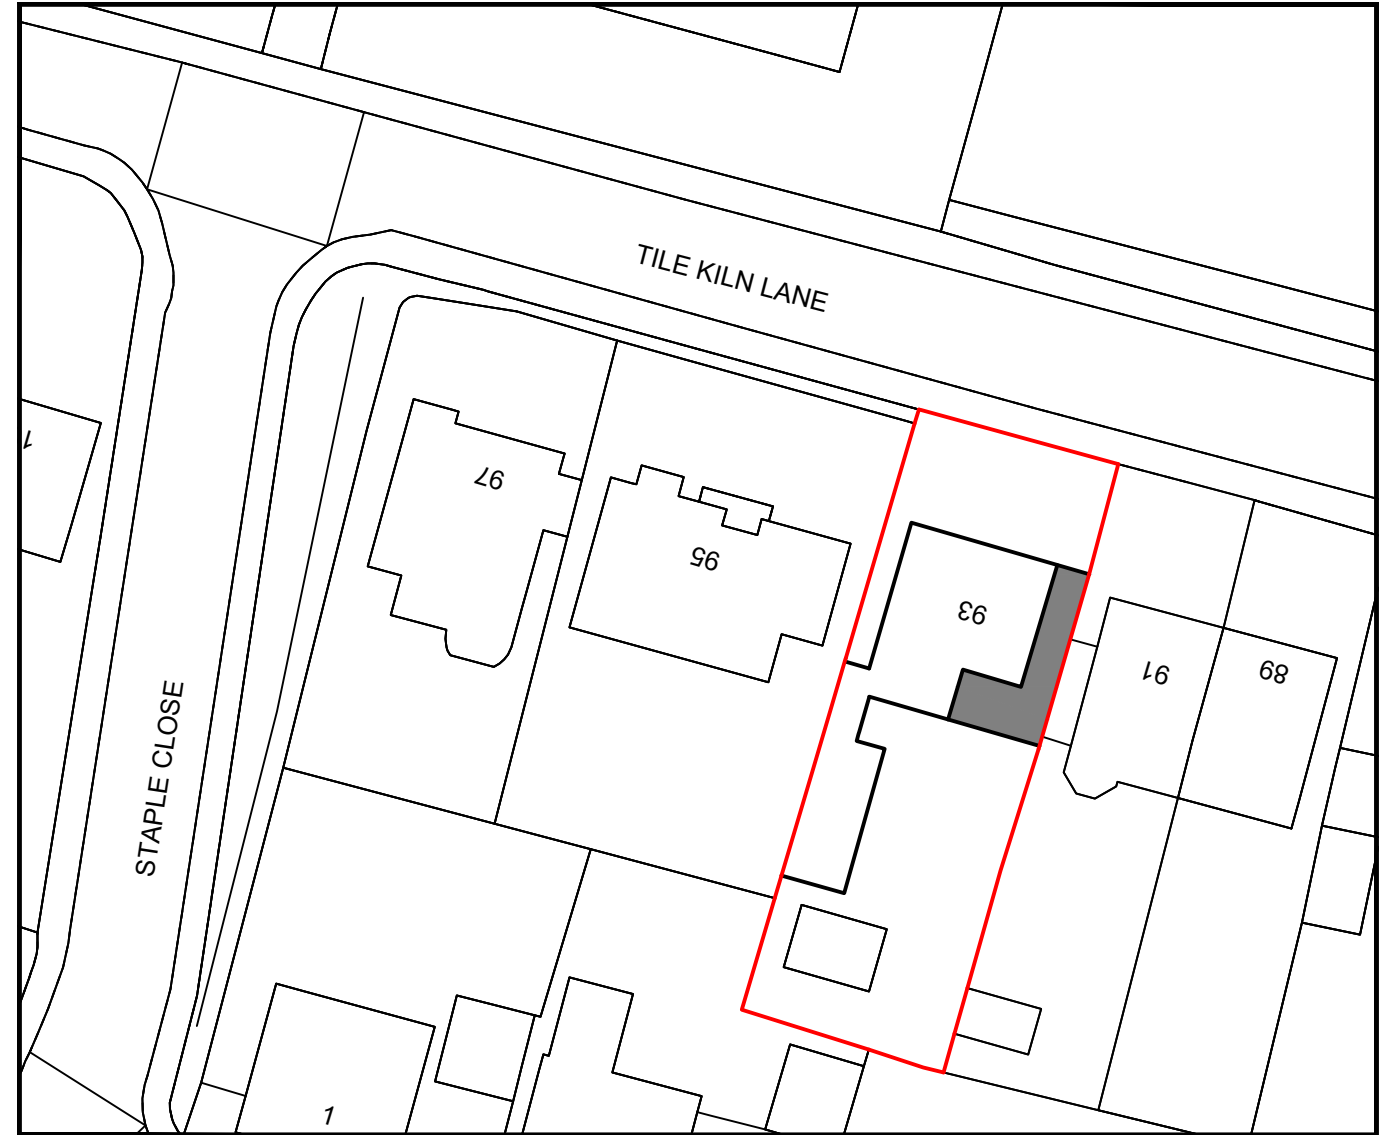


Existing Block Plan
Scale 1:500



Proposed Block Plan
Scale 1:500



Revision notes:		
Rev:	Date:	Notes:
001		<p>The Contractor must carry out His/Her own measured survey prior to works commencing on site to verify site dimensions and to report any discrepancies to the Designer. Contractor to refer to Building Control Notes. Contractor is responsible for final on site design using on site dimensions.</p> <p>Contractor responsible for on site drainage layout/runs - to be agreed by Building Control prior to Construction starting on site. All Details to be approved by Building Control prior to construction starting on site.</p>

Drawn by: FD	Project: 93 Tile Kiln Lane Bexley DA5 2BD
Client:	Drawing Title: EXISTING BLOCK PLAN PROPOSED BLOCK PLAN

Date: 21.07.2021	No.: 21-1305
Scale @ A3: 1:500	Rev: 0
Issue: BUILDING REGULATIONS DRAWINGS	Page: D02

Date: 21.07.2021	No.: 21-1305
Scale @ A3: 1:500	Rev: 0
Issue: BUILDING REGULATIONS DRAWINGS	Page: D02

Plan It
Architectural Services
www.planituk.co.uk