
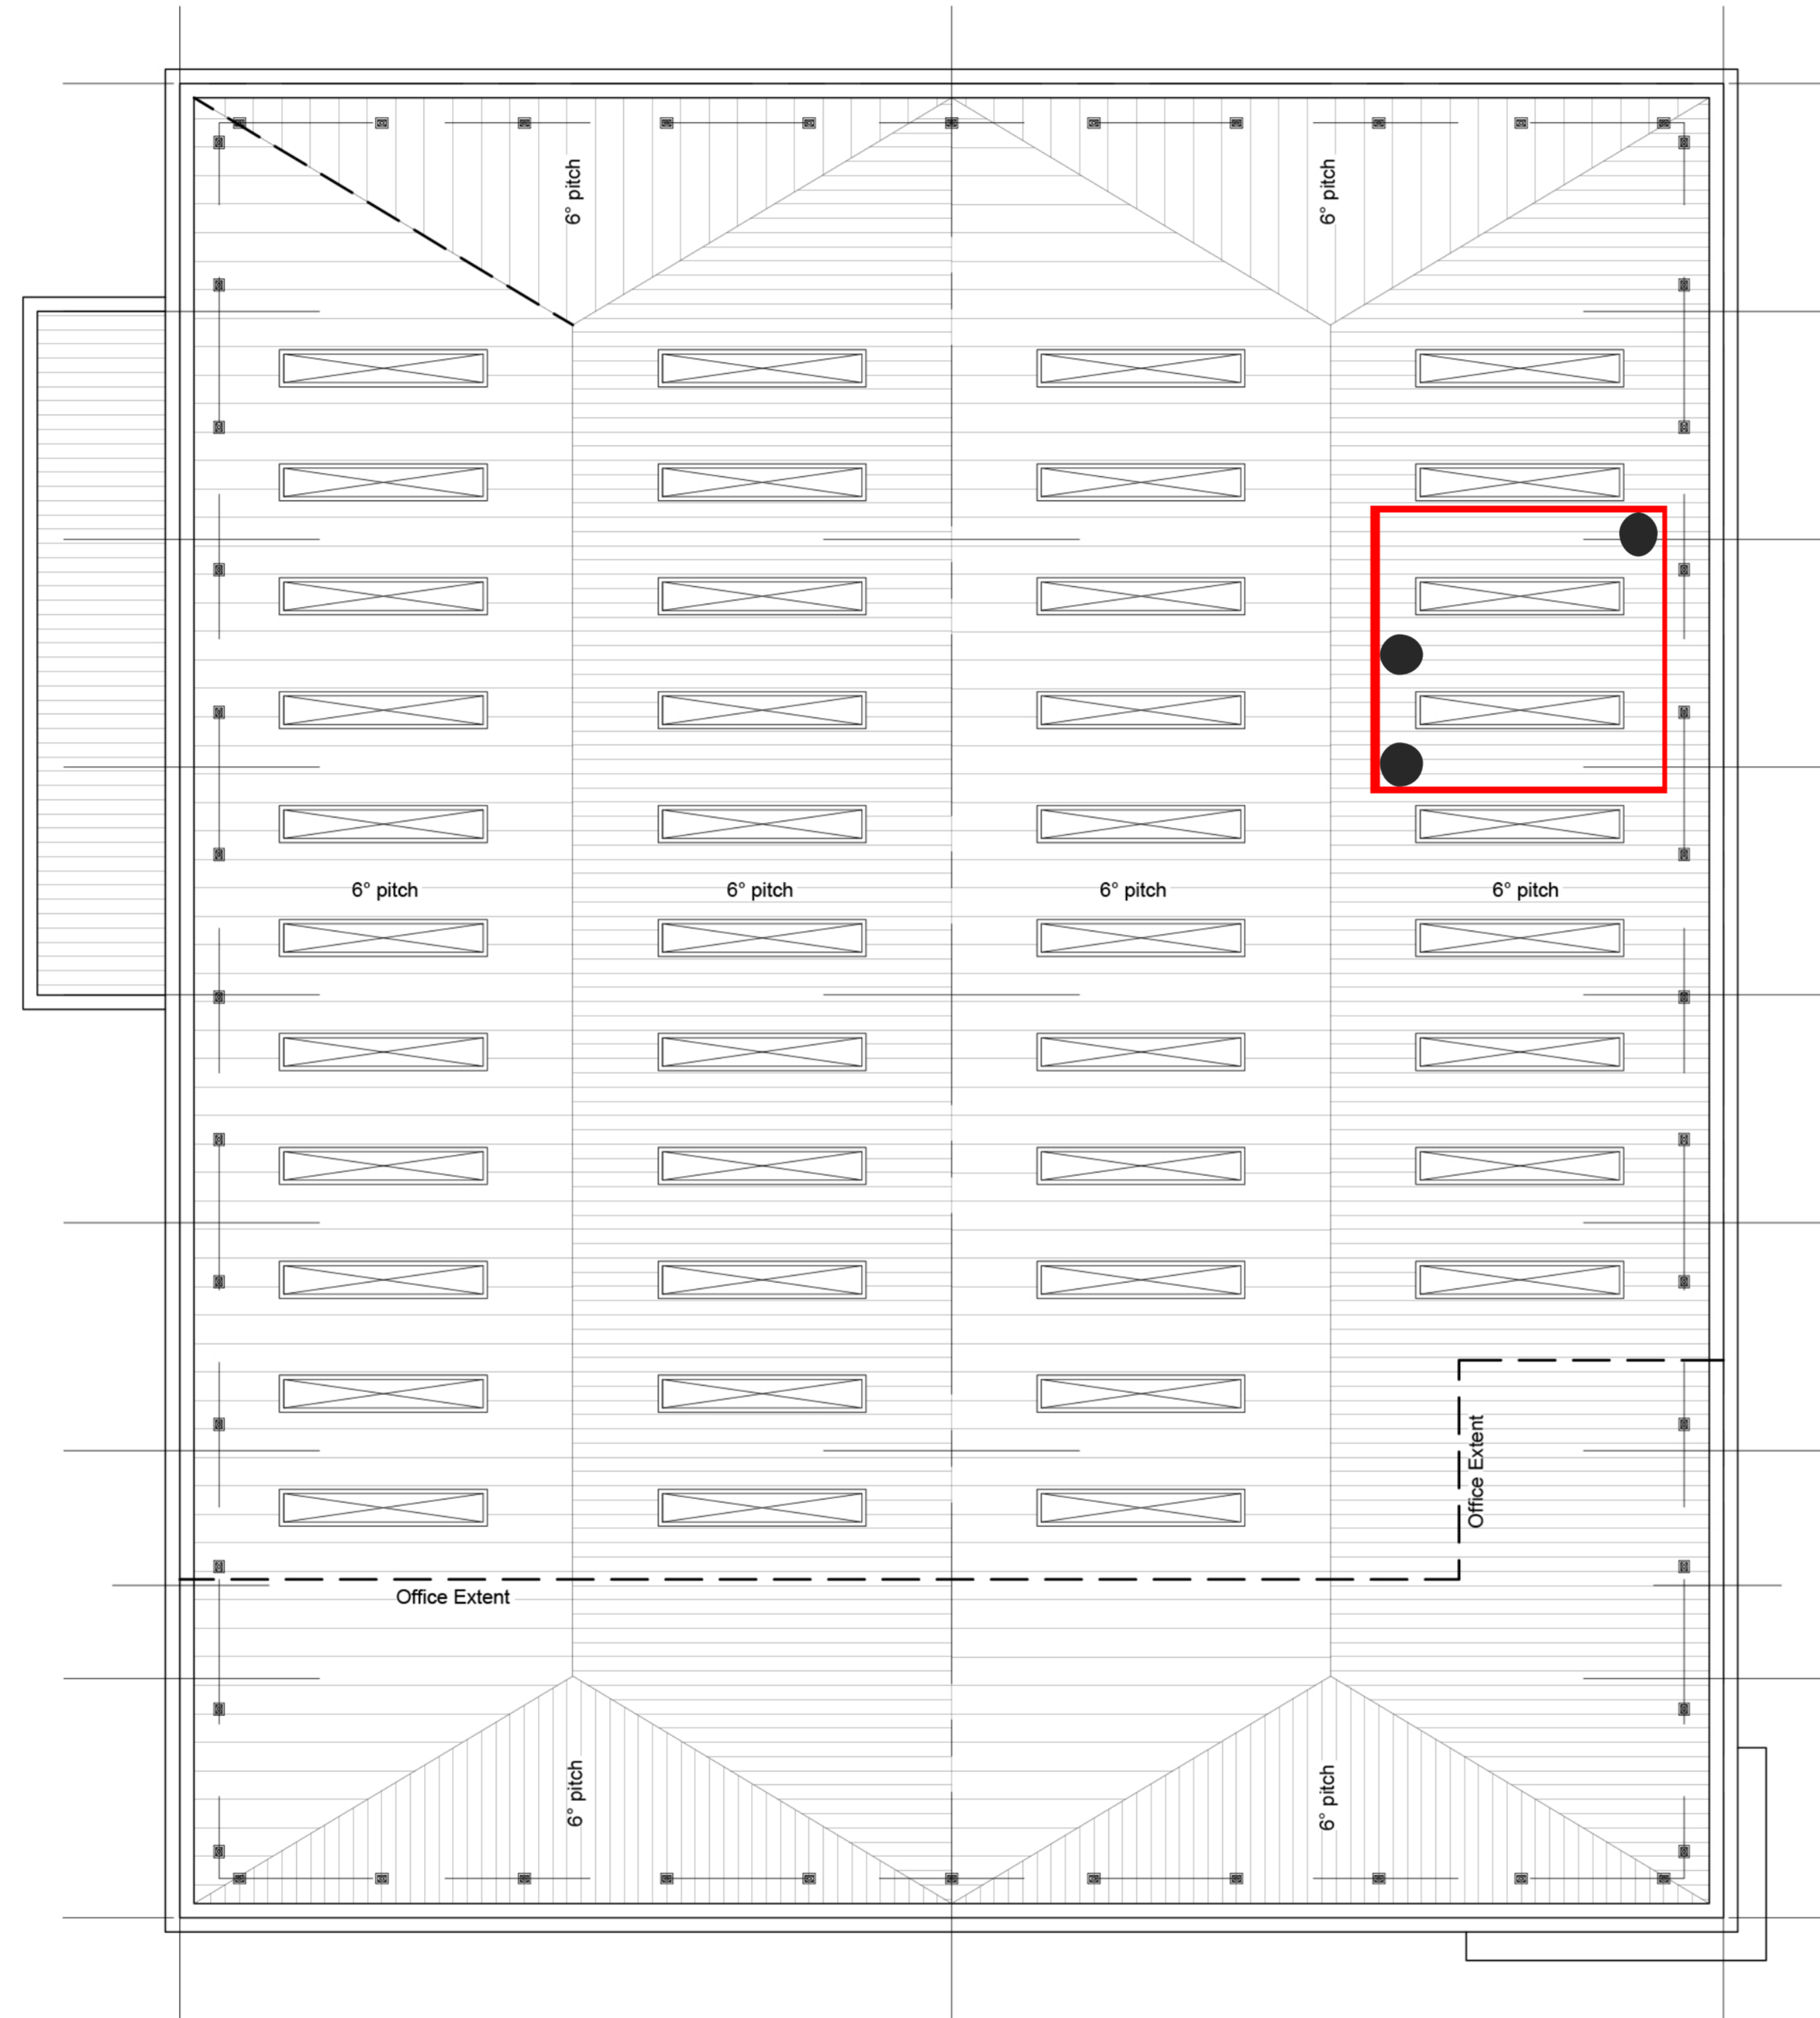


- Dimensions are in millimeters, unless stated otherwise.
- It is the recipient's responsibility to print this document to the correct scale.
- All relevant drawings and specifications should be read in conjunction with this drawing.

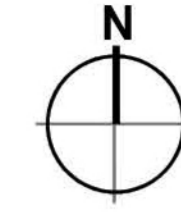

3 x flues

coop'ers
EST. 1983

Coopers Fire Ltd
Ignis House, Houghton Avenue,
Waterlooville
PO7 3DU

PLANNING

Roof Plan - 1:200

Drawing Number: COOP/PLN/006
Date: 29.06.21
Revision: 01