


A3 1:250
5m
10m
20m
30m

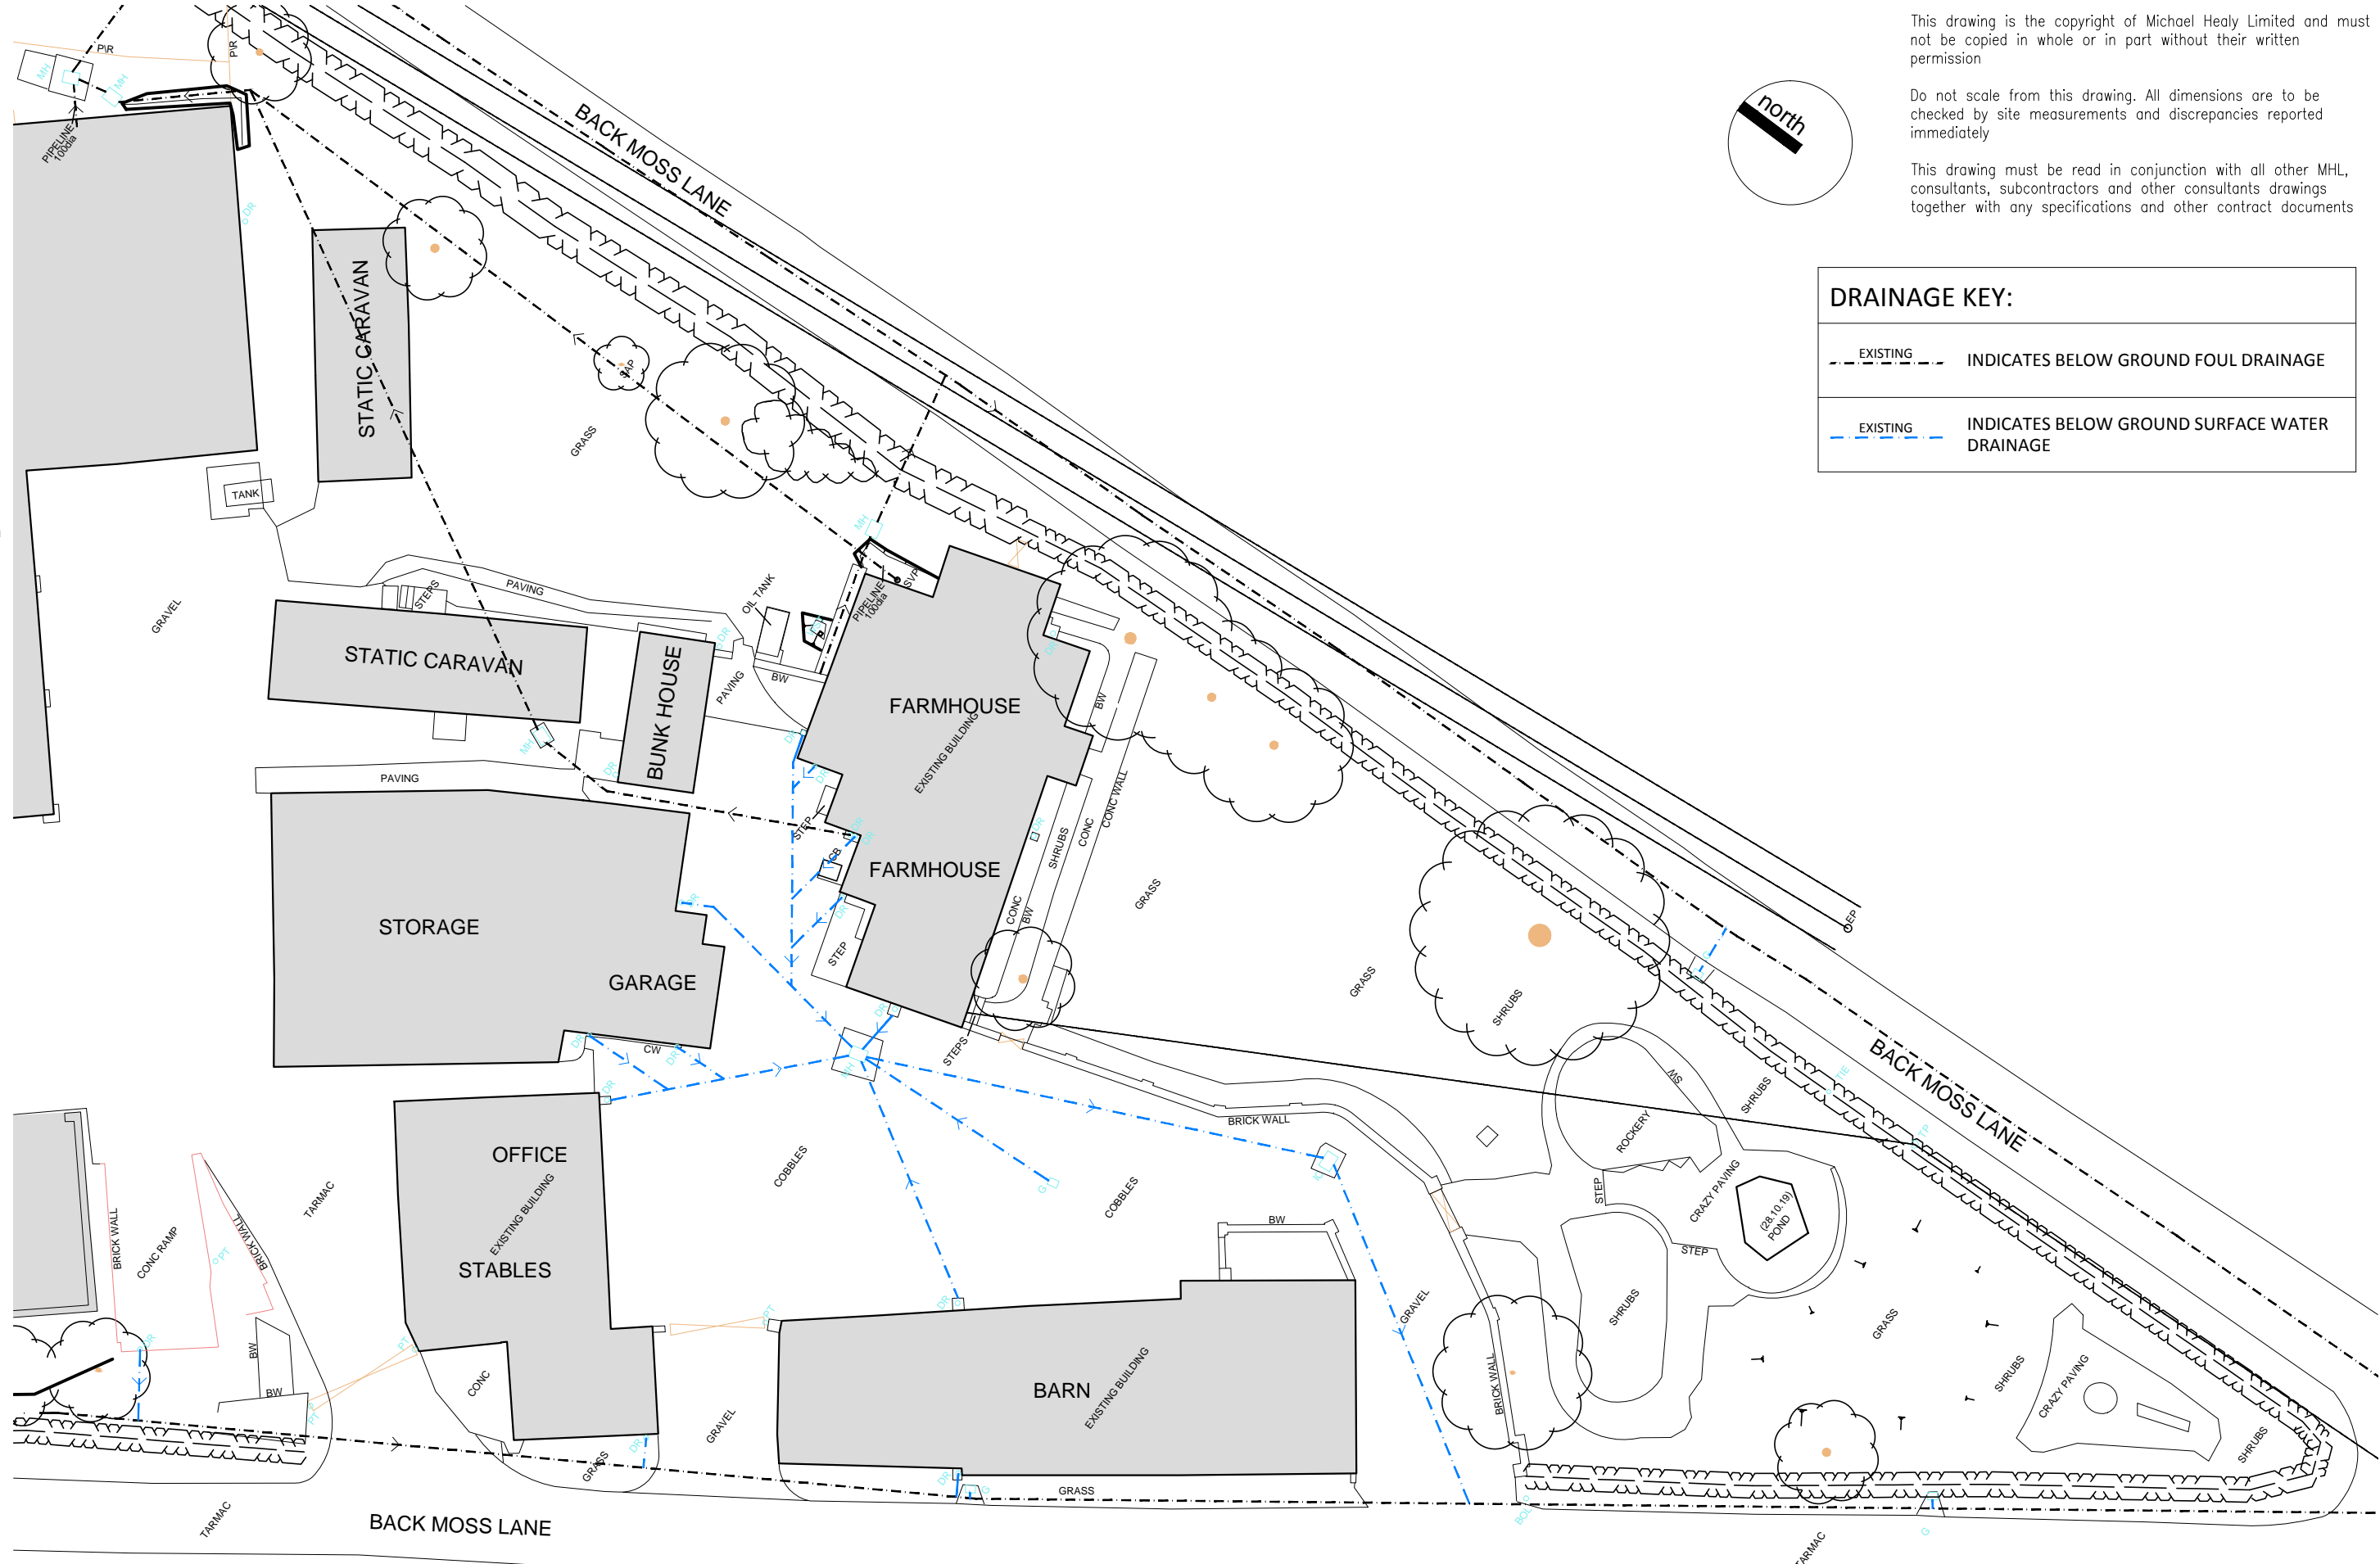

This drawing is the copyright of Michael Healy Limited and must not be copied in whole or in part without their written permission

Do not scale from this drawing. All dimensions are to be checked by site measurements and discrepancies reported immediately

This drawing must be read in conjunction with all other MHL, consultants, subcontractors and other consultants drawings together with any specifications and other contract documents

DRAINAGE KEY:	
	EXISTING INDICATES BELOW GROUND FOUL DRAINAGE
	EXISTING INDICATES BELOW GROUND SURFACE WATER DRAINAGE

michael healy limited
 architectural design + project management
 m : 07952 114756 e : info@michaelhealy.co.uk
 t : 01704 514751 w : www.michaelhealy.co.uk

Client Mr P Martin & Ms H Chen
 Project Proposed Barn Conversion at Back Moss Farm, Back Moss Lane, Burscough, Lancashire, L40

Scale 1:200 @ A3 Date July 2020
 Dwg Existing Site Plan & Indicative Drainage Layout

Rev	Description	Date

Issue PLANNING APPLICATION		
Project Ref	Drawing No.	Revision
1145	06	/