


COPYRIGHT ©
 FIGURED DIMENSIONS ONLY ARE TO BE USED. FOR OTHER DIMENSIONS REFER TO CA. ALL DIMENSIONS TO BE CHECKED ON SITE PRIOR TO THE COMMENCEMENT OF WORK. DISCREPANCIES, AMBIGUITIES OR DIFFERENCES BETWEEN DRAWINGS, AND BETWEEN DRAWINGS AND SPECIFICATION OR BILLS OF QUANTITIES TO BE REFERRED TO CA WITHOUT DELAY. DO NOT SCALE THIS DRAWING


GENERAL NOTES:

- THIS DRAWING MUST NOT BE USED FOR CONSTRUCTION PURPOSES OR INSTALLATION PURPOSES UNLESS EXPRESSLY STATED.
- DO NOT SCALE OFF THIS DRAWING. ALWAYS WORK TO NOTED DIMENSIONS.
- ALL DIMENSIONS MUST BE VERIFIED ON SITE BEFORE COMPLETING SHOP DRAWINGS OR SETTING OUT WORKS.
- ALL DRAWINGS MUST BE VERIFIED ON SITE BEFORE COMPLETING SHOP DRAWINGS OR SETTING OUT WORKS.
- THIS DRAWING IS TO BE READ IN CONJUNCTION WITH THE M&E SPECIFICATION PREPARED BY 'THE DESIGN COLLECTIVE'.
- THIS DRAWING IS TO BE READ IN CONJUNCTION WITH ALL ARCHITECTURAL & STRUCTURAL ENGINEERS DRAWINGS & ASSOCIATED DESIGN DRAWINGS PRODUCED BY 'THE DESIGN COLLECTIVE'.
- ALL DIMENSIONS IN MILLIMETRES (mm).
- THIS DRAWING IS UNDER COPYRIGHT AND AT NO TIME MUST ANY PORTION OF THIS DRAWING BE REPRODUCED OR COPIED IN ANY WAY WITHOUT THE PERMISSION OF 'THE DESIGN COLLECTIVE'.
- ALL WORKS ON SITE ARE TO COMPLY WITH THE RELEVANT BRITISH STANDARDS, CODES OF PRACTICE AND CURRENT BUILDING REGULATIONS.
- ANY DISCREPANCIES BETWEEN ALL WORKING DRAWINGS, SPECIFICATIONS & SCHEDULES OF ALL DISCIPLINES TO BE NOTIFIED TO 'THE DESIGN COLLECTIVE' FOR CLARIFICATION/CORRECTION PRIOR TO CONSTRUCTION.

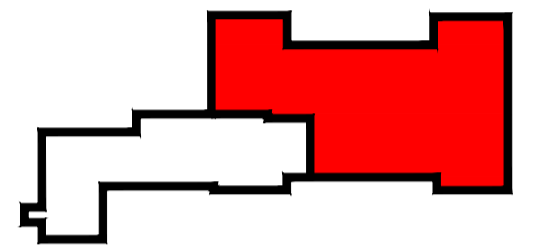

SEE SPECIFICATION FOR FULL DETAILS OF LUMINAIRE REFERENCE AND TYPES

E - DENOTES LUMINAIRE TO BE PROVIDED WITH 3 HOUR EMERGENCY BATTERY PACK

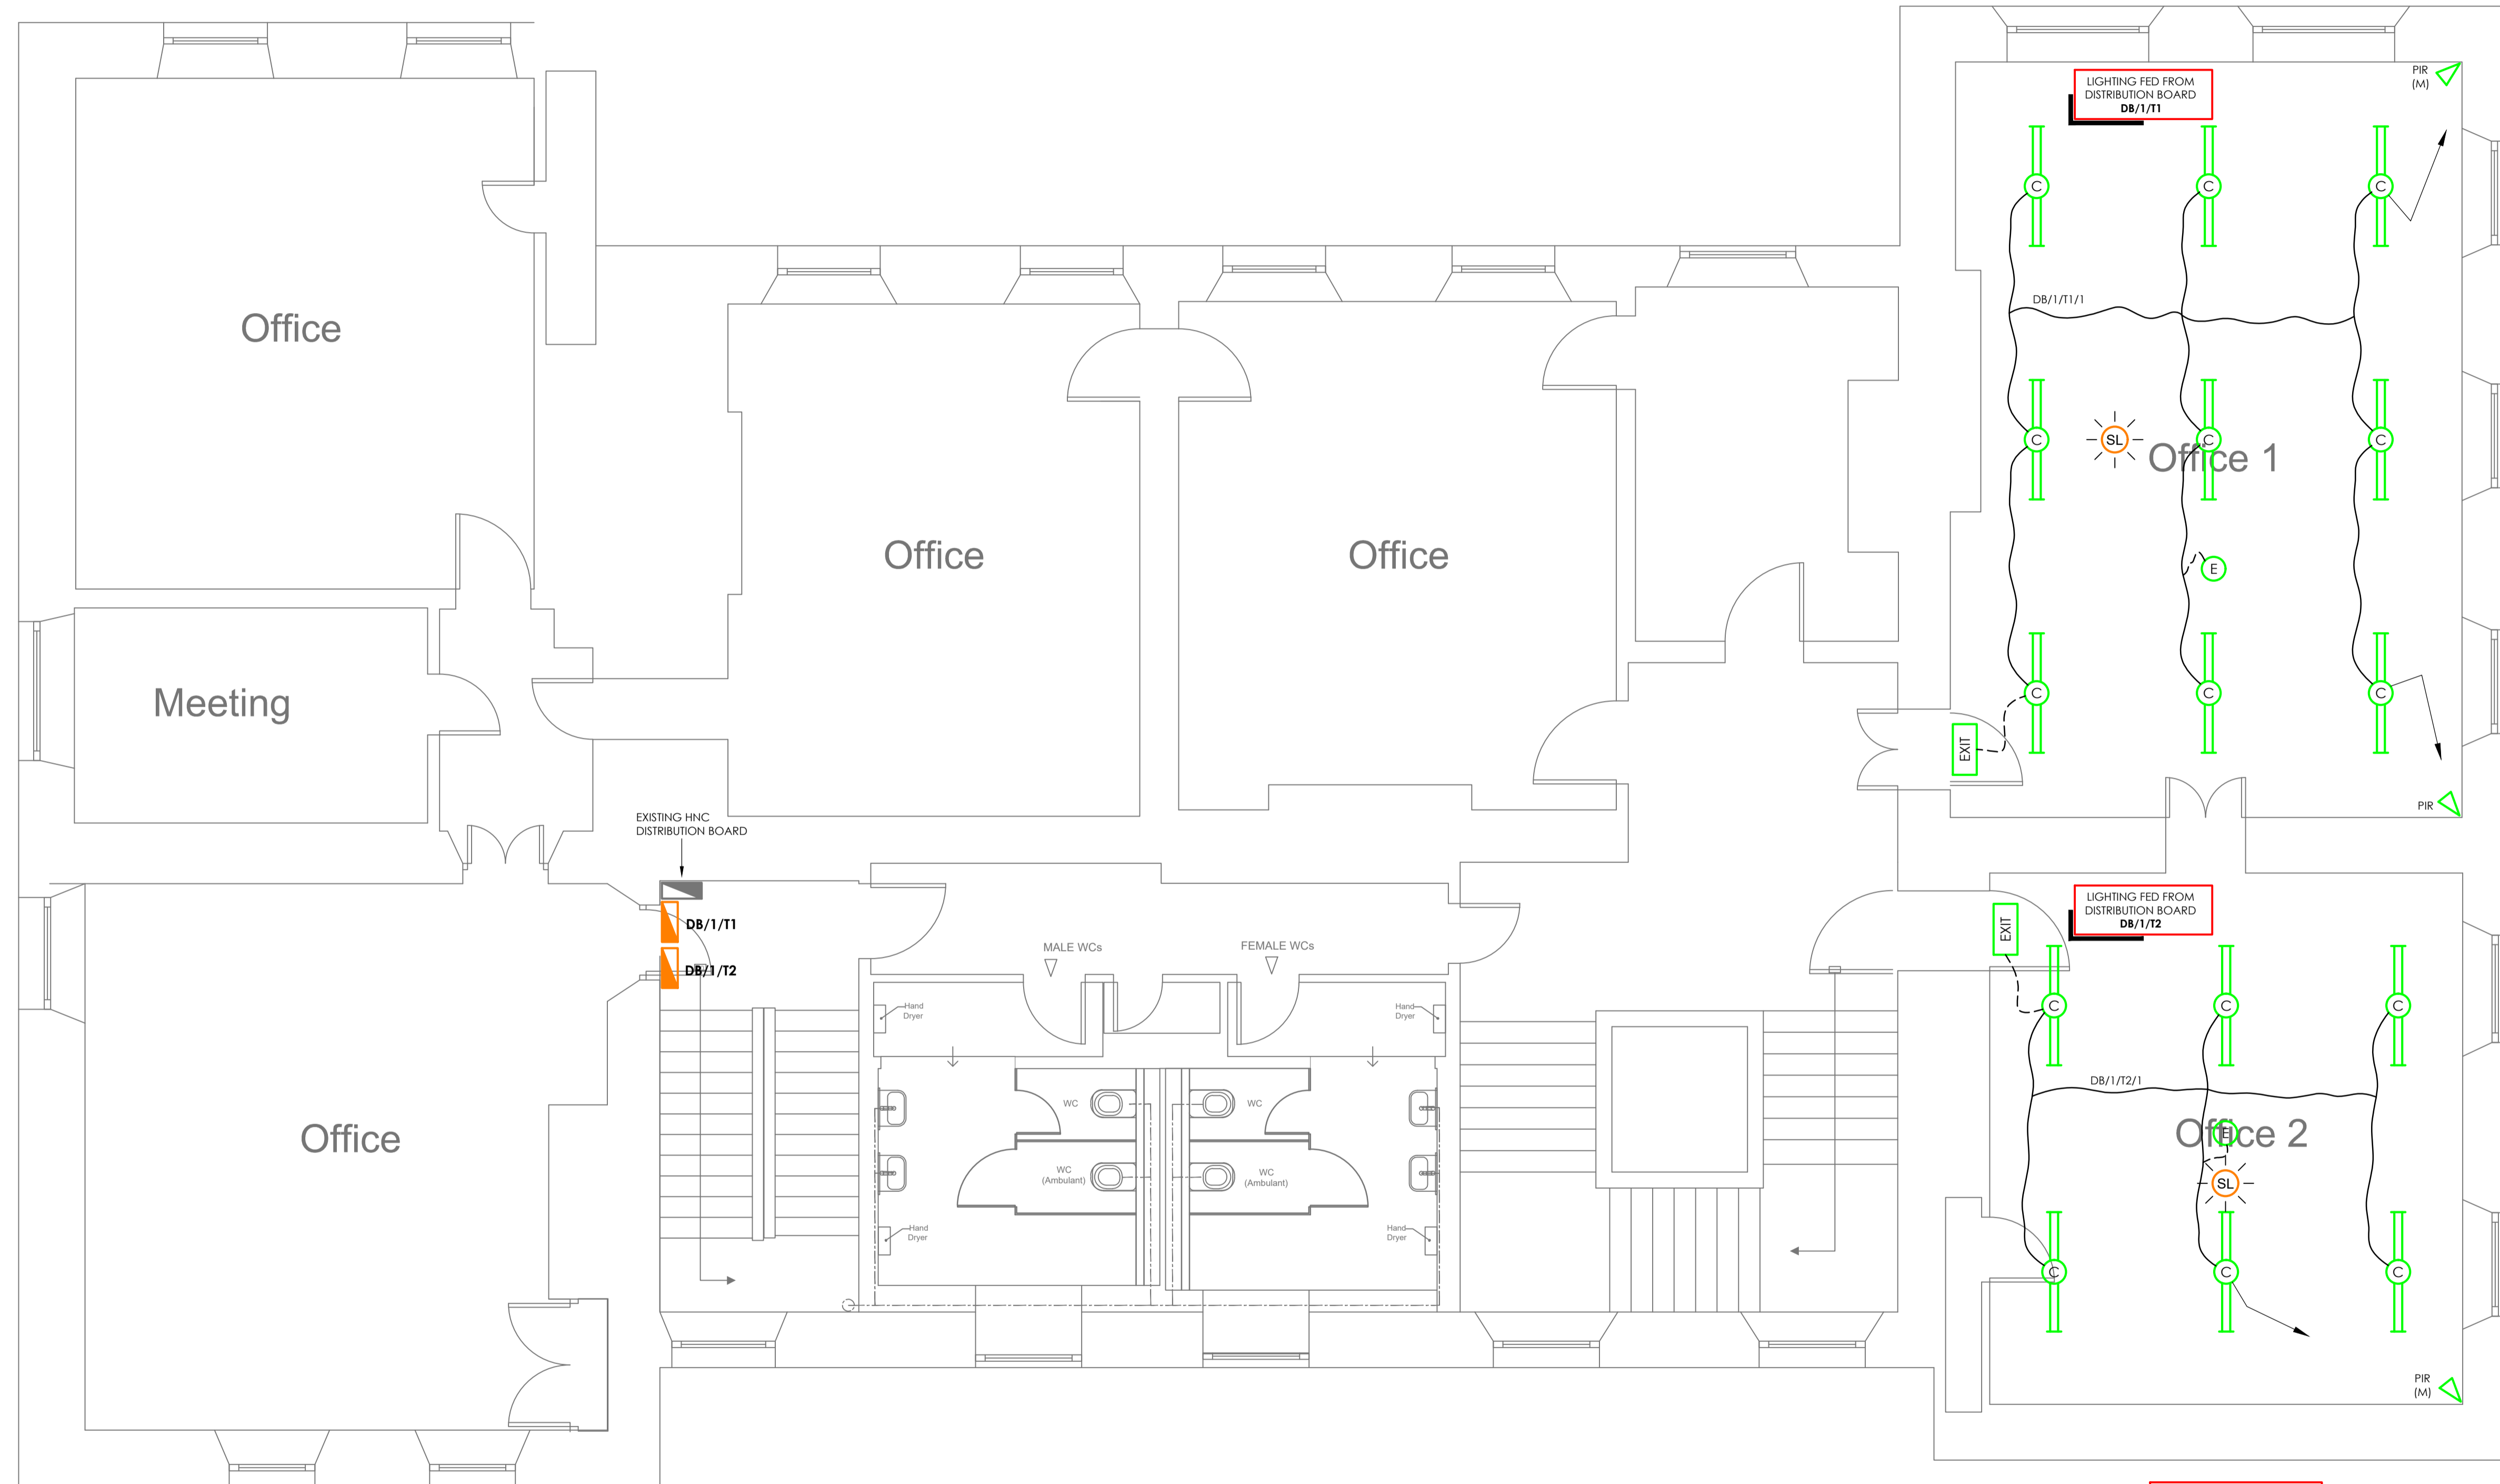

First Floor

EXISTING LIGHT SWITCH LOCATIONS TO BE FITTED WITH BLANKING PLATE

0	25.6.21	ISSUED FOR PRICING	JH/DS
Revision	Date	Description	Drawn/Checked
ARCHITECTS LAYOUTS			

THE DESIGN COLLECTIVE
 First Floor
 135 Red Lion Road
 Surbiton, Surrey
 KT6 7RQ
 Tel: 0208 391 5122
 E-Mail: info@thedesigndesigncollective.net
 Web: www.thedesigndesigncollective.net

PROJECT:
 TYTTENHANGER HOUSE



Title:
 GROUND FLOOR OFFICE 1 & 2
 PROPOSED LIGHTING LAYOUT

Scale 1:50@A1
Drawn. J.HOAD
Date. JUNE 2021

Dwg.No. TDC19060-ALL-01-E-1160

REVISION: 0