


 
LSI Ref | 20047-LSI-09-ZZ-M3-A-001
 20047 | _NCFC_Admin_Building_RR.pln

The copyright of the design remains with LSI Architects (Design) Ltd and may not be reproduced without their prior written consent

All dimensions are to be checked on site and the Contract Administrator notified of any discrepancies.

Drawing to be read in conjunction with the project specification

Do not scale from this drawing for Constructional purposes

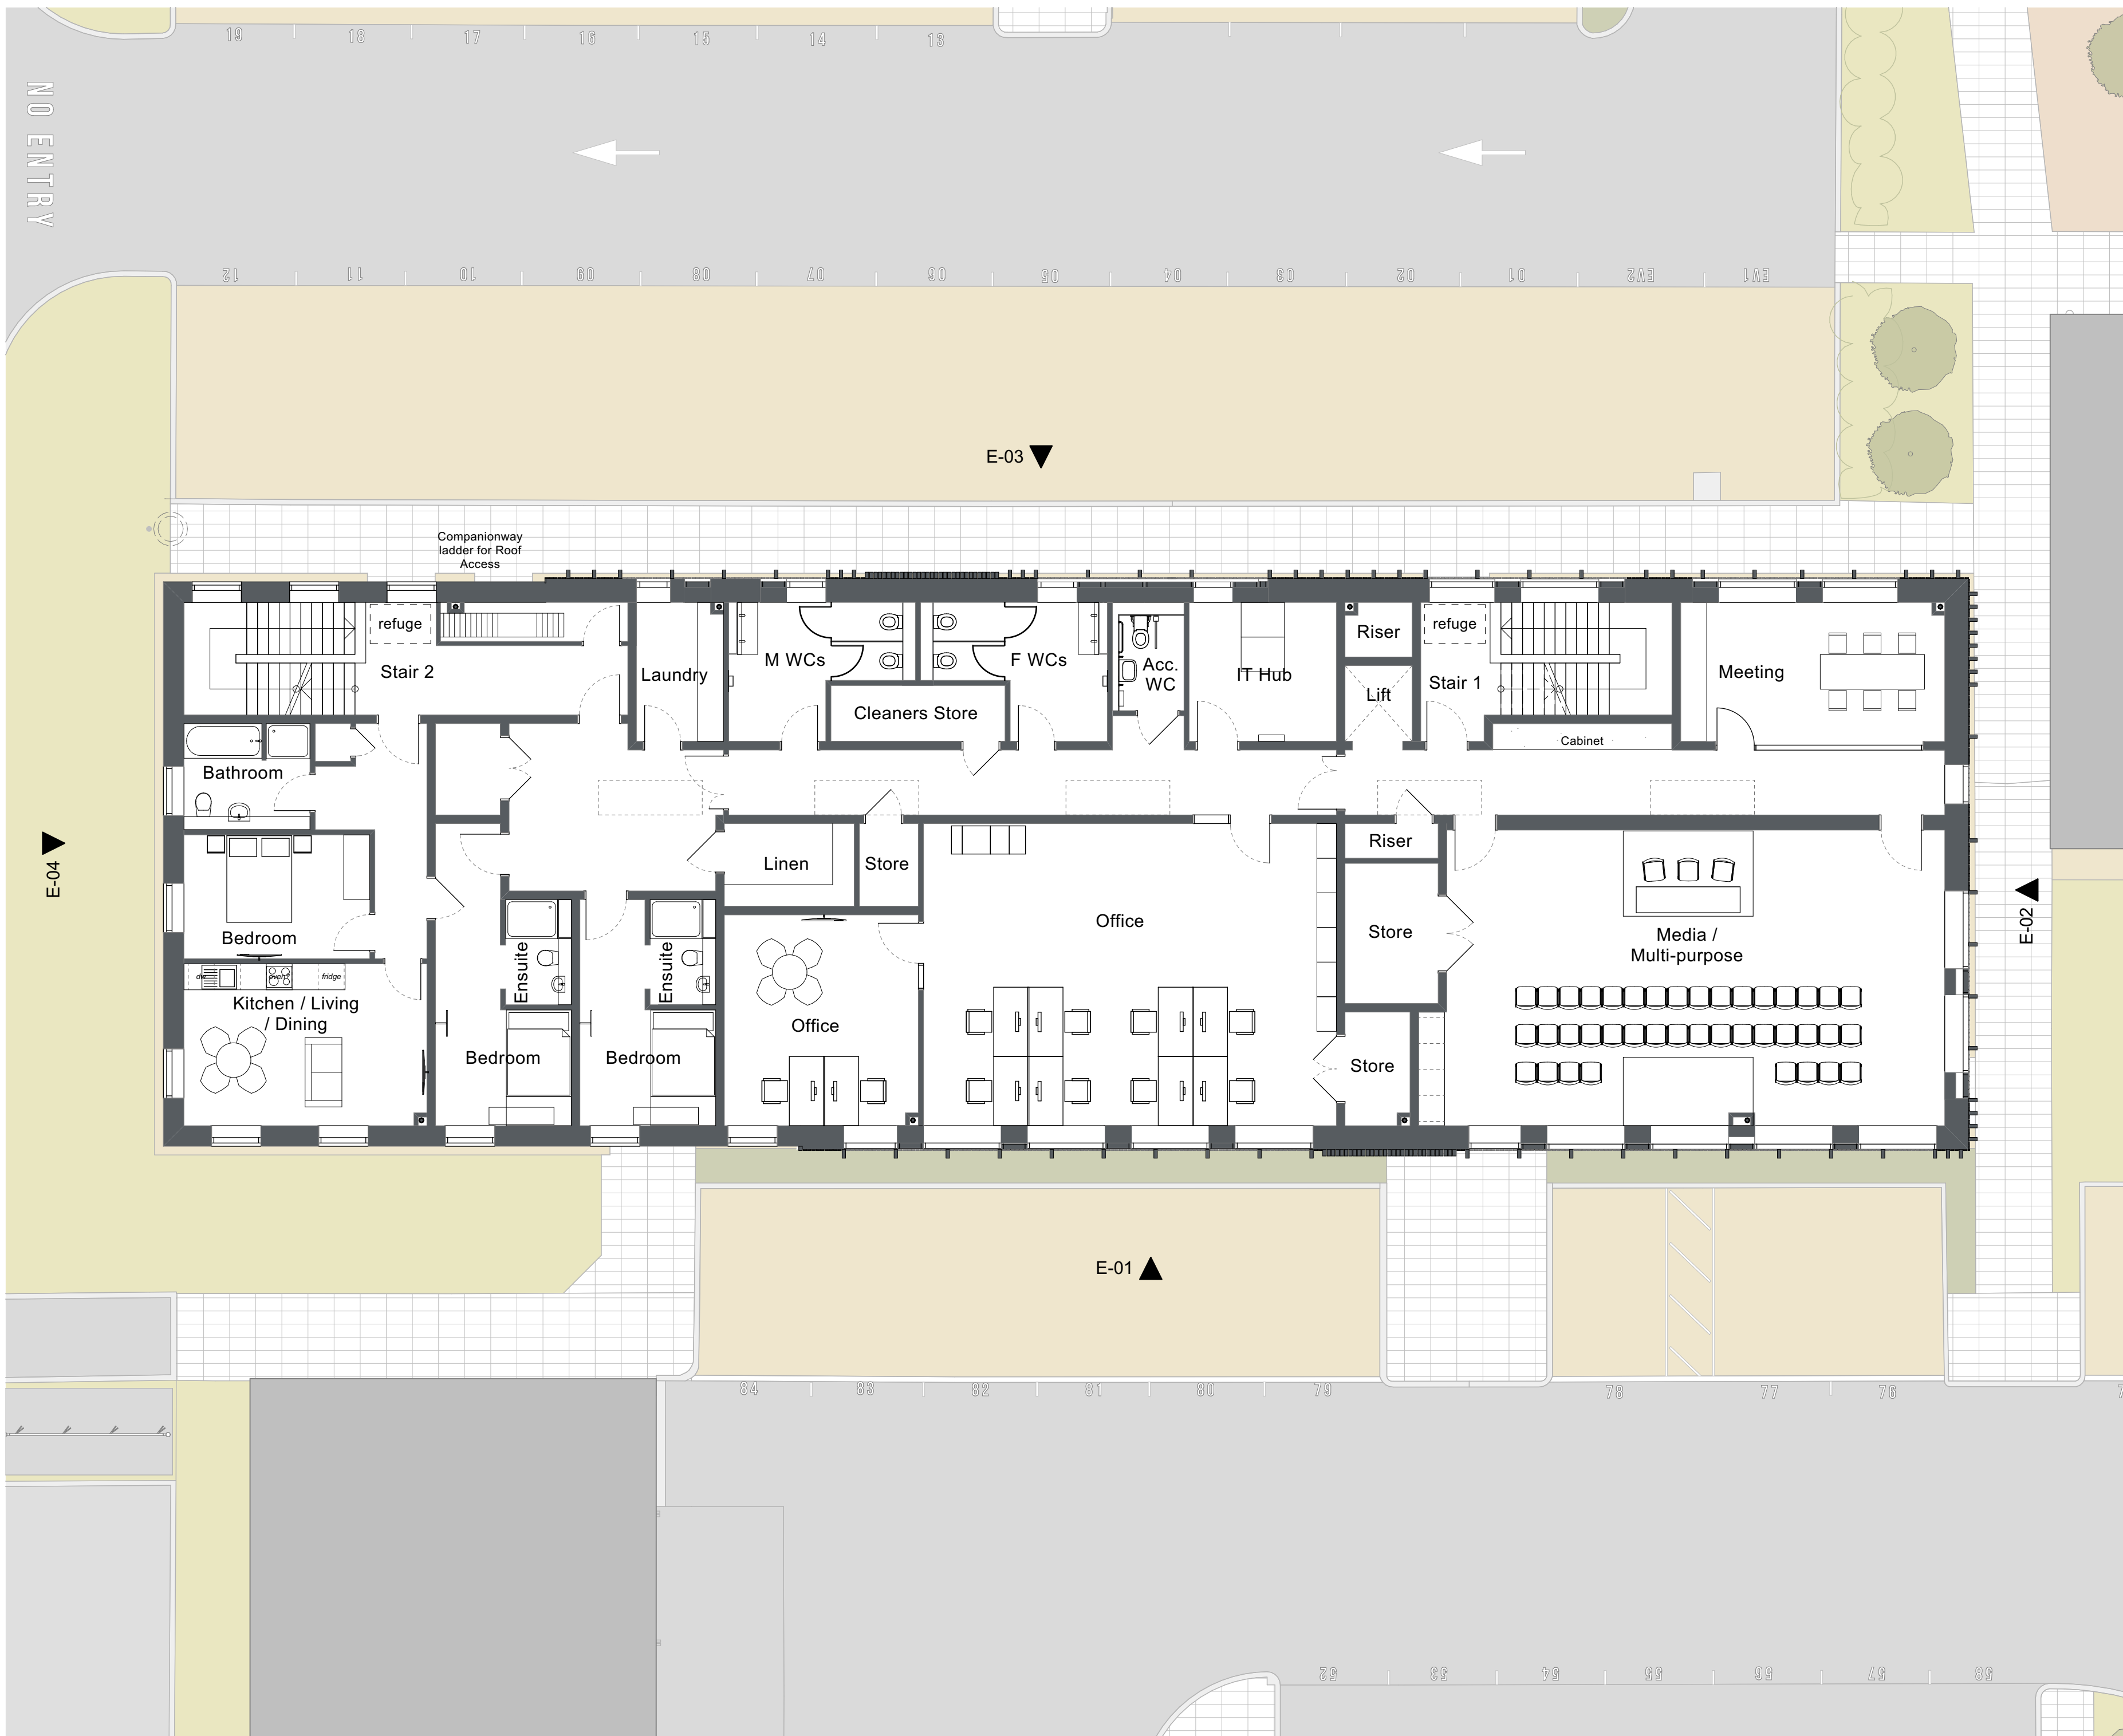

Issued for Planning: 26/08/2021

Rev	Init	Date	Revision

0m 1 2 3 4 5 6 7
 Scale 1:100

lsi
 ARCHITECTS

NORWICH
 The Old Drill Hall
 23a Cattle Market Street
 Norwich NR1 3DY
 +44(0)1603 660711

LONDON
 Floor 2
 50-54 Clerkenwell Road
 London EC1M 5PS
 +44(0)20 7278 1739
 www.lsiarchitects.co.uk

Client
 Norwich City Football Club

Project
 Administration and Media Building

Title
 PLANNING
 General Arrangement First Floor Plan

Scale @ A2	Date	Drawn
1:100	10/08/21	KBC

Purpose of issue		
Issued for Planning		
Drawing Code	Suit.	Rev.
20047-LSI-AB-01-DR-A-2001	S2	P01