
 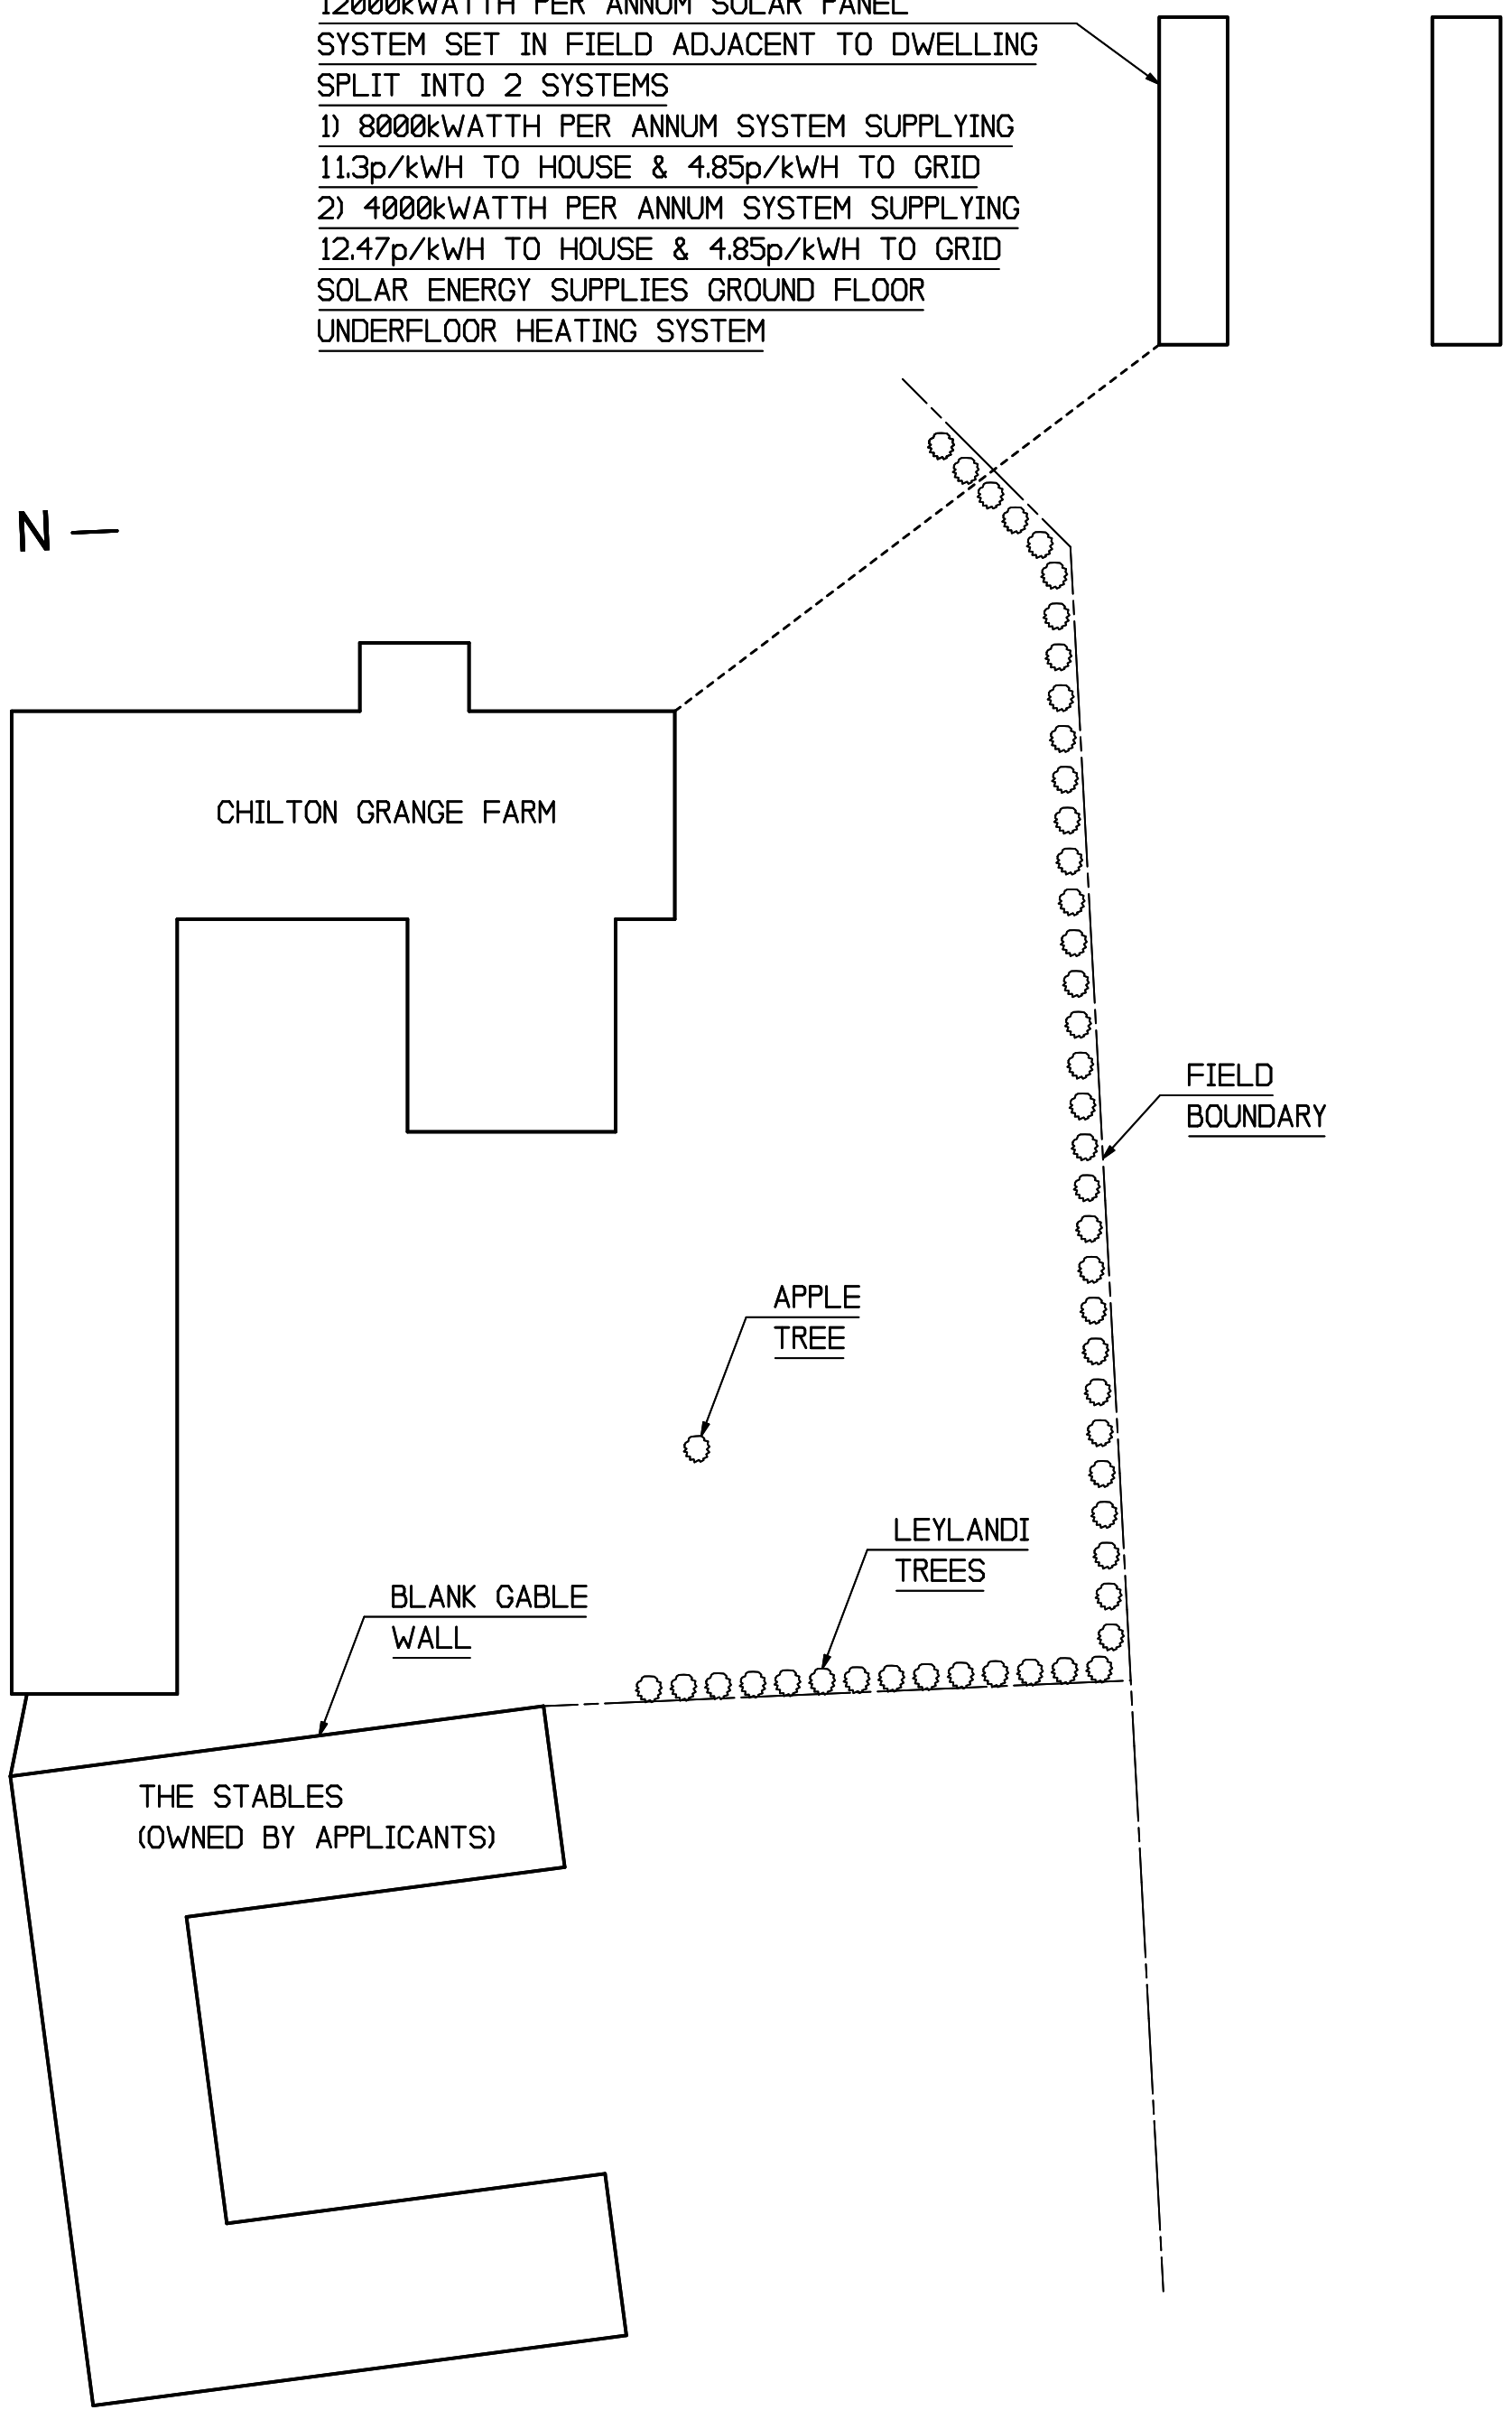


12000kWATTH PER ANNUM SOLAR PANEL
 SYSTEM SET IN FIELD ADJACENT TO DWELLING
 SPLIT INTO 2 SYSTEMS
 1) 8000kWATTH PER ANNUM SYSTEM SUPPLYING
 11.3p/kWH TO HOUSE & 4.85p/kWH TO GRID
 2) 4000kWATTH PER ANNUM SYSTEM SUPPLYING
 12.47p/kWH TO HOUSE & 4.85p/kWH TO GRID
 SOLAR ENERGY SUPPLIES GROUND FLOOR
 UNDERFLOOR HEATING SYSTEM



PROPOSED REAR EXTENSION TO CHILTON GRANGE FARM,
 GYPSY LANE, FERRYHILL, FOR MR & MRS M. COCKER
 DRG. No. 2: CENTRAL SITE PLAN
 A3: SCALE = 1:250 E. DINNING AUGUST 2021 RP-386