


**DRAINAGE NOTES / LEGEND**

- Denotes foul water sewer
- Denotes surface water drain
- Foul water laid to min. fall of 1:40 surface water laid to min. fall of 1:80
- Denotes new surface water soakaway / infiltration trench, all to the written approval of Scottish Water & Building Standards, N.L.C.
- Percolation testing to be carried out in accordance with BS6297-1983 & BS EN 752-4 1998 to determine suitability & design requirements.
- Denotes private foul water taken to septic tank / bio disc (by KLARGESTER or equal approved) with outlet to separate soakaway / infiltration trench via sampling chamber.
- All drains to be protected against loads and backfill, construction traffic and subsequent superimposed loading.
- All pipes to have long radius bend fitted to base.
- All drains to be 110mm UPVC, separate system.
- Denotes ACO channel to soakaway.

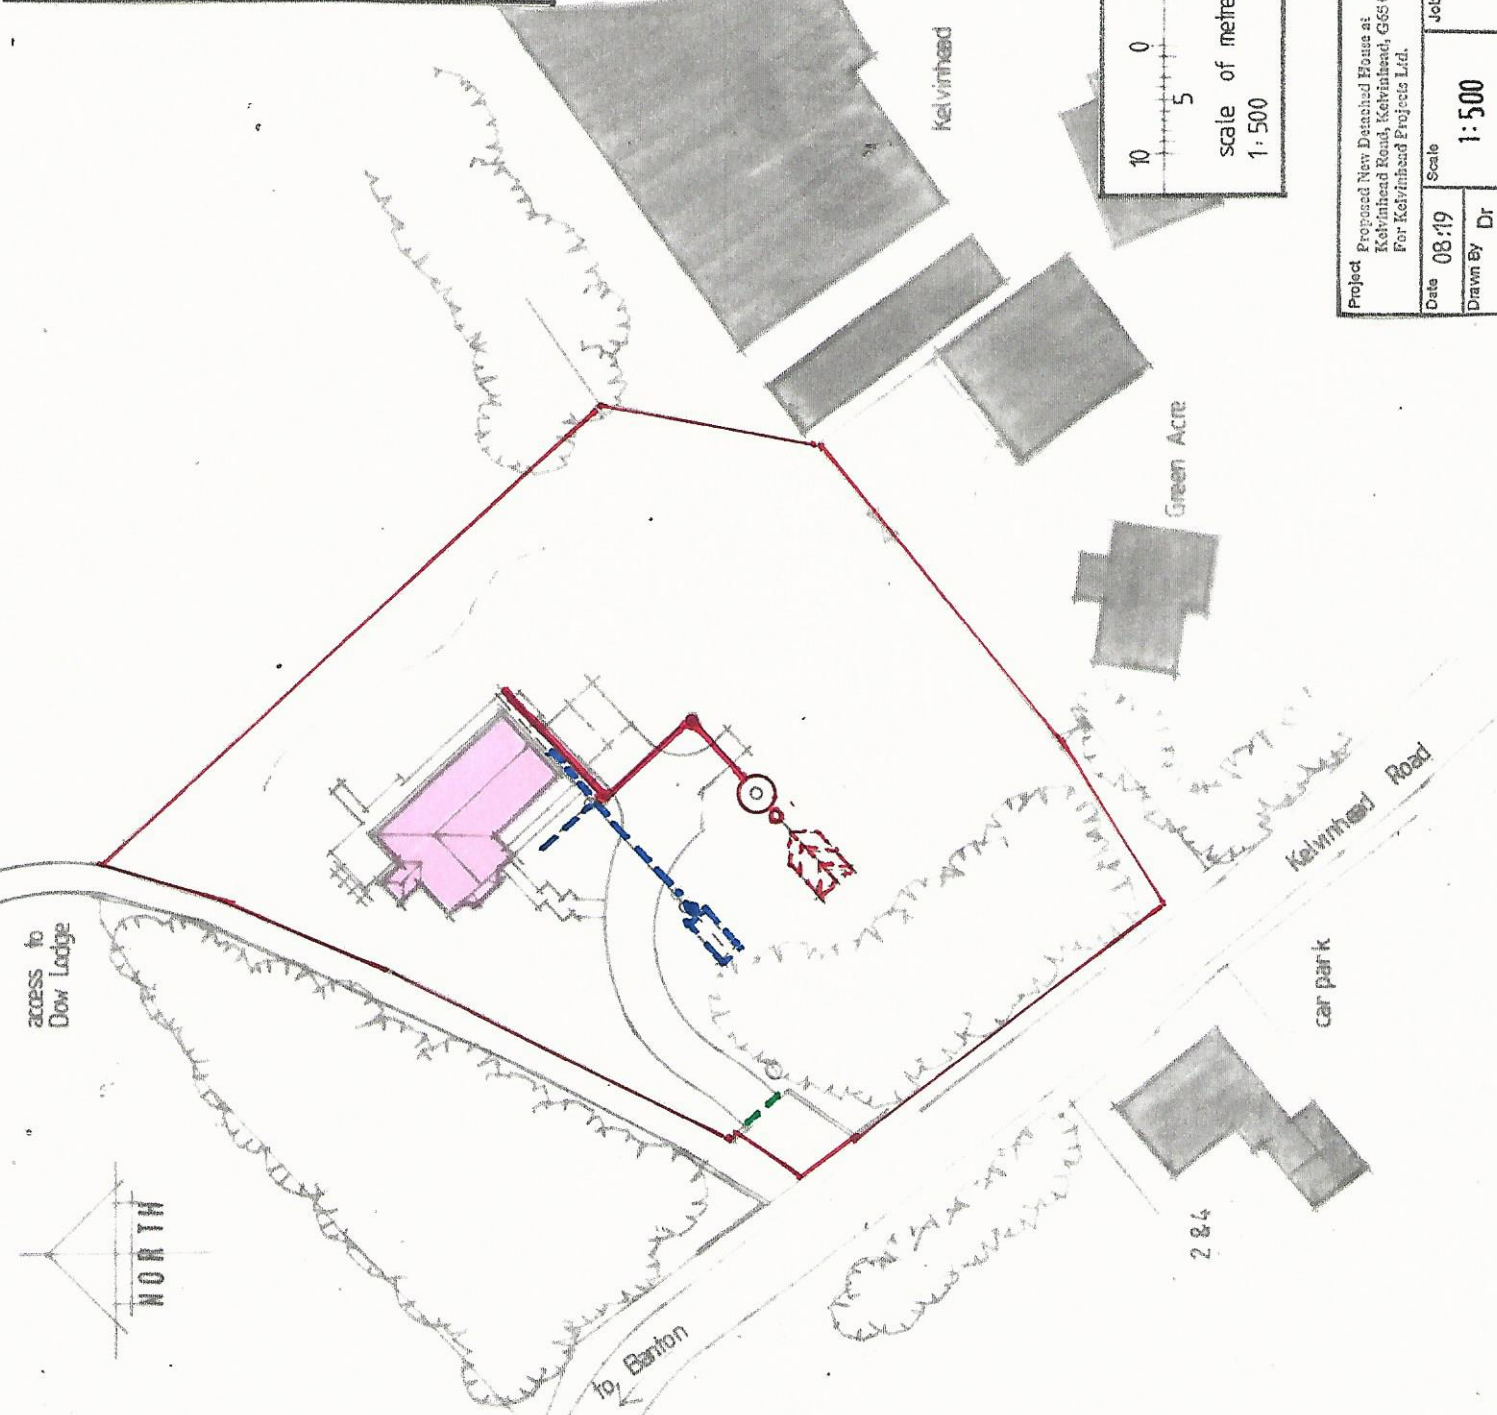

 <b>ADR (Design) Ltd</b> The Nurseries 5 Tak-Ma-Dooh Road KILSYTH G65 0RS Telephone/Fax 01236 827749	
<b>DRAINAGE LAYOUT</b>	
Project: Proposed New Detached House at Kelvinhead Road, Kelvinhead, G65 0QH For Kelvinhead Projects Ltd.	Drawing <b>377/08</b>
Date: 08/19 Drawn by: Dr	Job No.: 377 Drawing No.: 377/08 Rev.
Scale: <b>1:500</b>	