

GENERAL NOTES


ALL DIMENSIONS TO BE CHECKED ON SITE PRIOR TO COMMENCEMENT OF WORKS - PLEASE REPORT ERRORS OR OMISSIONS TO THE ARCHITECT.

THIS DRAWING HAS BEEN PRODUCED FOR THE PURPOSES OF PLANNING AND BUILDING REGULATIONS APPROVALS ONLY AND IS NOT INTENDED TO BE A FULL WORKING DRAWING.

THIS DRAWING IS TO BE READ IN CONJUNCTION WITH ANY WRITTEN SPECIFICATIONS, SCHEDULES OF WORK AND STRUCTURAL ENGINEERS DETAILS AS APPROPRIATE.

THIS DRAWING IS THE COPYRIGHT OF PUMP HOUSE DESIGNS AND ANY FURTHER REPRODUCTION OF THE PLAN IS NOT PERMITTED WITHOUT OBTAINING PRIOR CONSENT.

© CROWN COPYRIGHT - LICENCE NO. 100032237

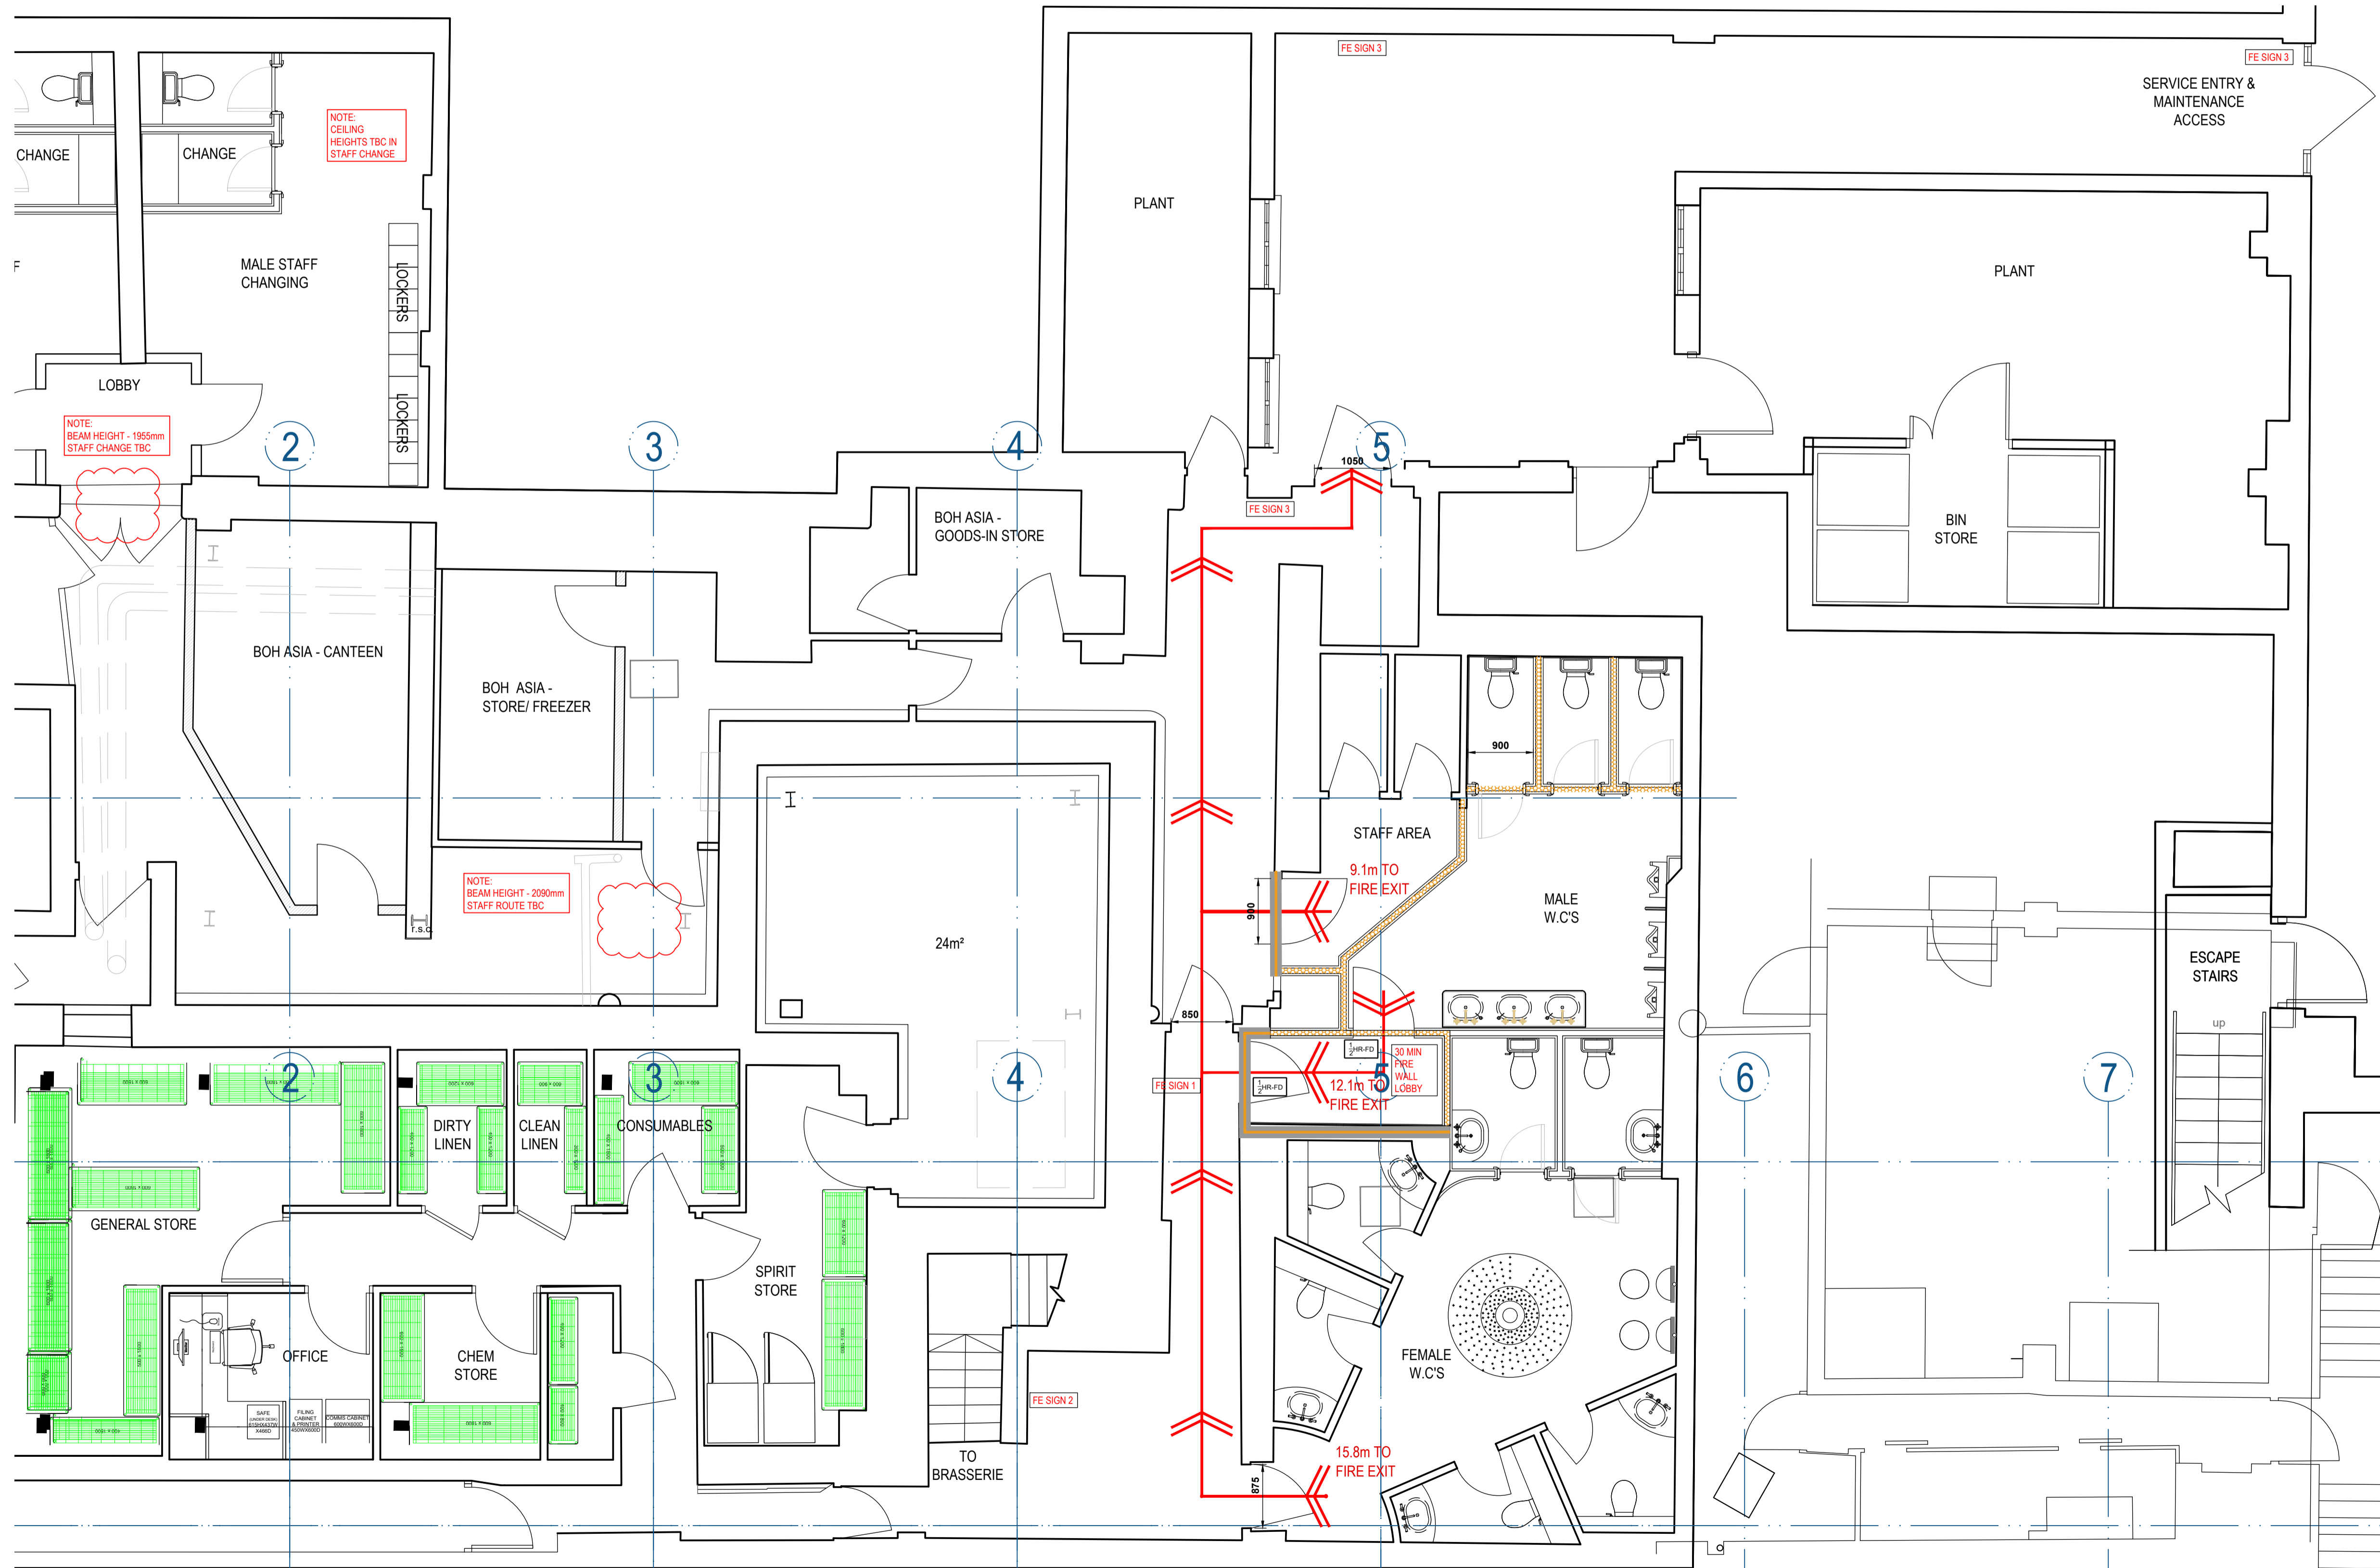

- REVISIONS**
FULL HEIGHT PARTITION TO BE CONSTRUCTED WITH 100mm STEEL STUDS AT 600MM C/C WITH BASE AND HEAD SECURED TO FLOOR SLAB AND STRUCTURAL SOFFIT ABOVE.
TO MANUFACTURERS RECOMMENDATIONS
 - NEW 30 MINUTE FIRE RATED PARTITION - FULL HEIGHT**
FULL HEIGHT PARTITION TO BE CONSTRUCTED WITH 100mm STEEL STUDS AT 600MM C/C WITH BASE AND HEAD SECURED TO FLOOR SLAB AND STRUCTURAL SOFFIT ABOVE.
TO MANUFACTURERS RECOMMENDATIONS
 - NEW ALUMINIUM FIRE RATED PARTITION - FULL HEIGHT**
FULL HEIGHT PARTITION TO BE CONSTRUCTED WITH 100mm STEEL STUDS AT 600MM C/C WITH BASE AND HEAD SECURED TO FLOOR SLAB AND STRUCTURAL SOFFIT ABOVE.
TO MANUFACTURERS RECOMMENDATIONS
 - EXISTING WALL LEASURED - FULL HEIGHT**
EXISTING WALLS TO BE UPGRADED TO ACHIEVE 30 MINUTE FIRE RATING
 - EXISTING WALL LEASURED - FULL HEIGHT**
EXISTING WALLS TO BE UPGRADED TO ACHIEVE 30 MINUTE FIRE RATING
 - FIRE PROTECTED LOBBY**
- FE SIGN 1**
FRONT OF HOUSE FIRE EXIT SIGNAGE
ILLUMINATED WALL MOUNTED FIRE EXIT SIGNAGE
PUSH P FRAME MINI CYLINDER WALL MOUNTED EXIT SIGN, FINISHED IN PINKY BRONZE, ARROW DIRECTION TO SUIT POSITION ON SITE.
 - FE SIGN 2**
FRONT OF HOUSE FIRE EXIT SIGNAGE
ILLUMINATED CEILING MOUNTED FIRE EXIT SIGNAGE
PUSH P FRAME MINI CYLINDER CEILING MOUNTED EXIT SIGN, FINISHED IN PINKY BRONZE, ARROW DIRECTION TO SUIT POSITION ON SITE.
 - FE SIGN 3**
BACK OF HOUSE FIRE EXIT SIGNAGE
ILLUMINATED FIRE EXIT SIGNAGE
PUSH P FRAME ALUMINIUM BOX SIGNAGE OR SIMILAR AS PER ELECTRICAL CONTRACTOR, ARROW DIRECTION TO SUIT POSITION ON SITE.

PumpHouse
DESIGNS
Architectural & Interior
Design Consultants

Pump House Yard
The Green
Sedlescombe
East Sussex
TN33 0QA
info@pumphousedesigns.co.uk
www.pumphousedesigns.co.uk

T: 01424 871120

F			
E			
D			
C			
B	RE-ISSUED WITH UPDATED GA	AG	05.08.21
IVY ASIA BRIGHTON 51 SHIP STREET BRIGHTON BN1 1AF			
PROPOSED FIRE STRATEGY PLAN - BASEMENT			
DRAWN BY - L KATZ DATE - JUNE 2021 SCALE - 1:50 @ A1			
DRAWING No. 6990 / 401			

BASEMENT FLOOR PLAN

