

**LIGHTING LEGEND**  
REFER TO LIGHTING SCHEDULE FOR ALL LIGHTING DETAILS

SYMBOL	DESCRIPTION	SPEC REF	SYMBOL	DESCRIPTION	LI
	LOBBY LIGHTS			SPOTS TO WC'S - PINHOLE EDGE 90 ACCENT GU10	LI-108
	TOILETS - BASIL LARGE FLUSH MOUNT	LI-001		GANTRY SPOTS - D4 MINIATURE DOWNLIGHT	LI-52
	CEILING LIGHTS - BESPOKE PALM CEILING	LI-02		BOH FLUSH MOUNT	LI-52
	CEILING LIGHTS - PALM CEILING	LI-03		LED TO COFFER	LI-116-A
	SPOTS TO RESTAURANT PERIMETER - EDGE 90 ACCENT TRIMLESS	LI-101		SPOTS - DIRECTIONAL ARTWORK SPOTLIGHT (SAME AS ST PAULS)	LI-055
	SPOTS TO RESTAURANT COFFER - EDGE 90 ACCENT TRIMLESS	LI-102		FLUSH MOUNT IN ANTIQUE BRASS (MALE WC AND DWC)	LI-009
	SPOTS TO CORRIDOR - EDGE 90 ACCENT TRIMLESS	LI-103		SPOTS - pinhole edge 90 accent	LI-50
	SPOTS TO STATUES AND SAMURAI'S - LOW GLARE RECESSED SPOTLIGHT WITH 6 DEGREES TILT AND NARROW BEAM	LI-106		SUSPENDED CEILING TILE LIGHT	

ALL POSITIONS OF SPEAKERS, VENTILATION & CCTV ARE TO BE CONFIRMED BY RELEVANT SPECIALISTS & DRAWINGS REVISED


**CEILING LEGEND - HEIGHTS IN RED**  
ALL NEW GRILLES, SPEAKERS, CAMERAS, EMERGENCY LIGHTS & EMERGENCY DETECTION TO BE IN LINE WITH LIGHTING LAYOUT

SYMBOL	SPECIFICATION	SYMBOL	SPECIFICATION
	PROPOSED MF CEILING, PLASTERBOARD FACED FINISHED WITH GOLD LEAF PAPER BY ADAM ELLIS GF HEIGHT - 2615mm BASEMENT HEIGHT - TBC		NEW SUSPENDED CEILING TILES ON NEW GRID HEIGHT - GROUND FL 3950mm/ FIRST FL 2200mm
	PROPOSED MF CEILING, PLASTERBOARD FACED FINISHED WITH GOLD LEAF PAPER BY ADAM ELLIS HEIGHT - FIRST FL - 3100mm		BAR GANTRY - PATINATED BRASS FINISH HEIGHT - 2090mm
	PROPOSED MF CEILING, PLASTERBOARD FACED FINISHED WITH GOLD LEAF PAPER BY ADAM ELLIS HEIGHT GROUND FLOOR - 3180mm		WALLPAPER - GOLD PAINT FINISH / RAL 1024 HEIGHT - 2350mm/ 2400mm
	PROPOSED MF CEILING, PLASTERBOARD FACED FINISHED WITH GOLD LEAF PAPER BY ADAM ELLIS HEIGHT GROUND FLOOR - 3505mm		POWDERCOATED ALUMINIUM LAY IN CEILING GRID WITH LIGHTING & PERFORATED TILES - BRONZE COLOUR TO MATCH RIMEX HEIGHT - TBC
	PROPOSED MF CEILING, PLASTERBOARD FACED FINISHED WITH GOLD FINISH - GOLD LEAF - 24 CARAT PURE GOLD HEIGHT - GROUND FL 3360mm/ FIRST FL 3100mm		PROPOSED MF CEILING, PLASTERBOARD FACED FINISHED WITH ADAM ELLIS ARTWORK (DRAGON ARTWORK TO MATCH IVY ASIA MANCHESTER) HEIGHT - TBC
	PROPOSED MF CEILING, PLASTERBOARD FACED FINISHED WITH GOLD FINISH - GOLD LEAF - 24 CARAT PURE GOLD HEIGHT - 3705mm		PROPOSED MF CEILING, PLASTERBOARD FACED FINISHED WITH BLACK PAINT MATT FINISH HEIGHT - 2570mm TBC
	PROPOSED MF CEILING, PAINTED BLACK HEIGHT - GROUND FL 2615mm/ FIRST FL 3235mm		EXISTING CEILING PAINTED BLACK HEIGHT - 3970mm
	PROPOSED P/B SUSPENDED CEILING PAINTED FIREFLY BY LITTLE GREEN. NOTE FEMALE TOILETS TO HAVE CORNICE DETAIL FEMALE LOBBY - 2445mm CUBICLE - 2295mm		SUSHI BAR GANTRY - RIMEX SEE SUSHI DETAIL FOR SPOTLIGHT POSITIONS HEIGHT - 1970mm
	PROPOSED MF CEILING, PAINTED BLACK HEIGHT - GROUND FLOOR NEW CEILING HEIGHT ABOVE BOH STAIR 4020mm		PROPOSED P/B SUSPENDED CEILING PAINTED FARROW & BELL WHITE TIE (PT-13) WITH PLASTER BEADING TO FORM LATTICE PATTERN - TO ALLOW DUCTING TO PASS THROUGH VOID BASEMENT MALE TOILETS/ LOBBY - 2165mm
	EXISTING CEILING MAINTAINED: FACED FINISHED WITH GOLD LEAF PAPER BY ADAM ELLIS HEIGHT - GROUND FLOOR DOUBLE HEIGHT AREA: 6210/6075mm		

**CORNICE LEGEND**

SYMBOL	SPECIFICATION
	PLASTER CORNICE SPECIFICATION: GEORGE JACKSON KENILWORTH CN0504 PAINT FINISH
	COFFER DETAIL TO MATCH IVY ASIA ST PAUL'S
	PLASTER CORNICE SPECIFICATION: GEORGE JACKSON 'BISHOPS CN 0803' PAINT FINISH
	PLASTER CORNICE TO MATCH EXISTING SPECIFICATION: GEORGE JACKSON SOMERTON CN0510
	PROPOSED CORNICE TO WC'S (AS IVY CARDIFF)

**GENERAL NOTES**  
ALL DIMENSIONS TO BE CHECKED ON SITE PRIOR TO COMMENCEMENT OF WORKS - PLEASE REPORT ERRORS OR OMISSIONS TO THE ARCHITECT.  
THIS DRAWING HAS BEEN PRODUCED FOR THE PURPOSES OF PLANNING AND BUILDING REGULATIONS APPROVALS ONLY AND IS NOT INTENDED TO BE A FULL WORKING DRAWING.  
THIS DRAWING IS TO BE READ IN CONJUNCTION WITH ANY WRITTEN SPECIFICATIONS, SCHEDULES OF WORK AND STRUCTURAL ENGINEERS DETAILS AS APPROPRIATE.  
THIS DRAWING IS THE COPYRIGHT OF PUMP HOUSE DESIGNS AND ANY FURTHER REPRODUCTION OF THE PLAN IS NOT PERMITTED WITHOUT OBTAINING PRIOR CONSENT.  
© CROWN COPYRIGHT - LICENCE NO. 100032237

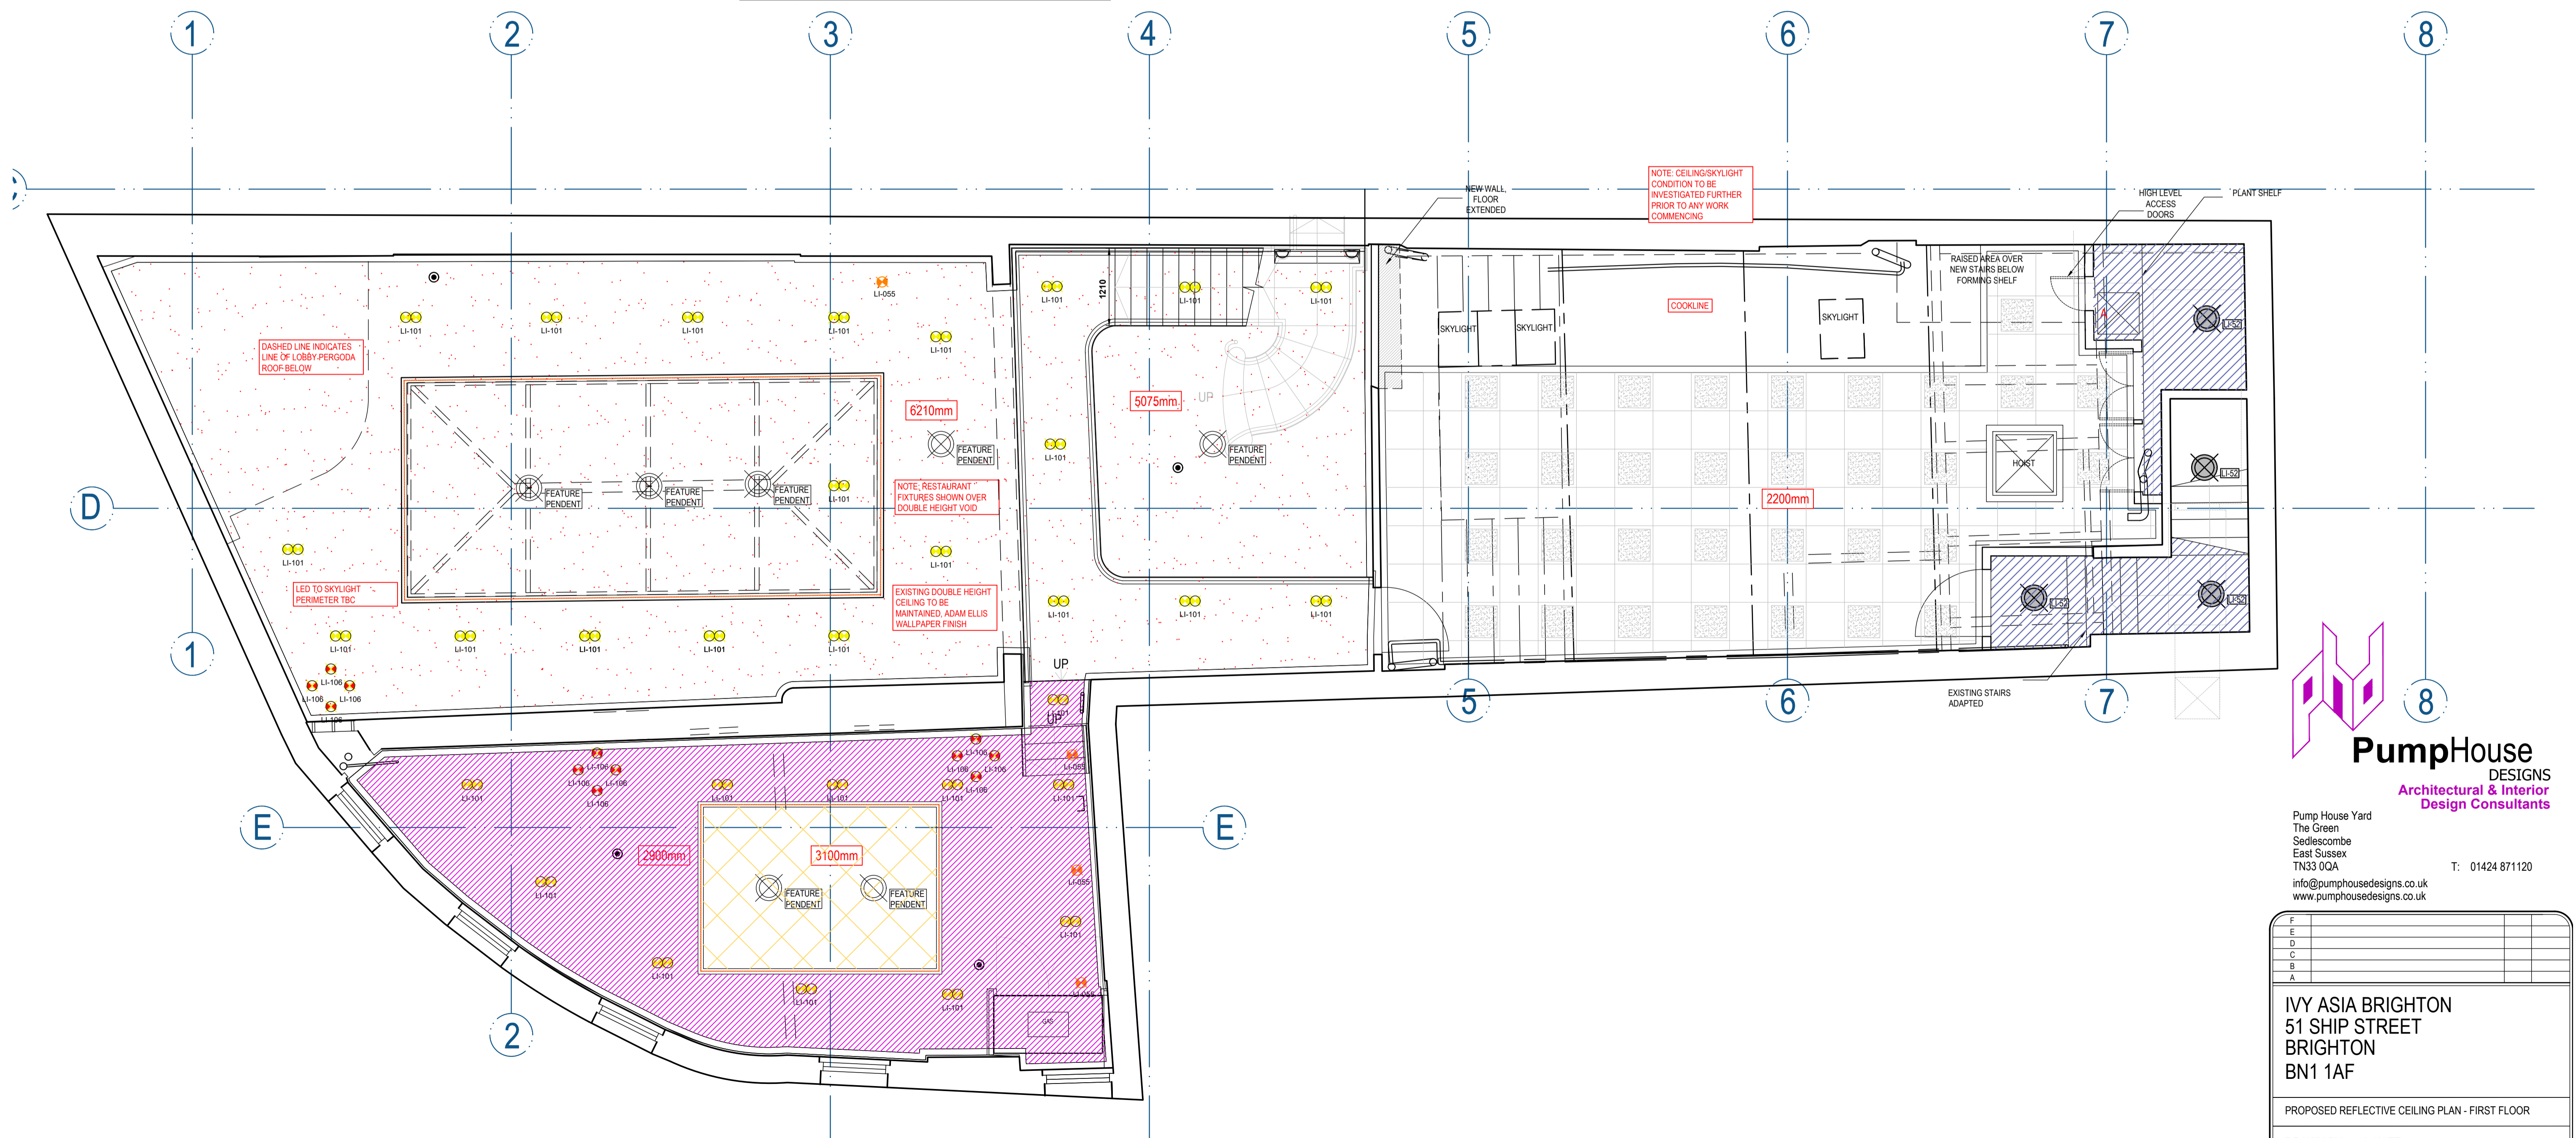

**PumpHouse**  
DESIGNS  
Architectural & Interior  
Design Consultants

Pump House Yard  
The Green  
Sedlescombe  
East Sussex  
TN33 0QA  
info@pumphousedesigns.co.uk  
www.pumphousedesigns.co.uk

T: 01424 871120

F			
E			
D			
C			
B			
A			

IVY ASIA BRIGHTON  
51 SHIP STREET  
BRIGHTON  
BN1 1AF

PROPOSED REFLECTIVE CEILING PLAN - FIRST FLOOR

DRAWN BY - L KATZ  
DATE - JUNE 2021  
SCALE - 1:50 @ A1  
DRAWING No. 6990 / 303

