 



Elevation A



Metres

Scale: 1:100

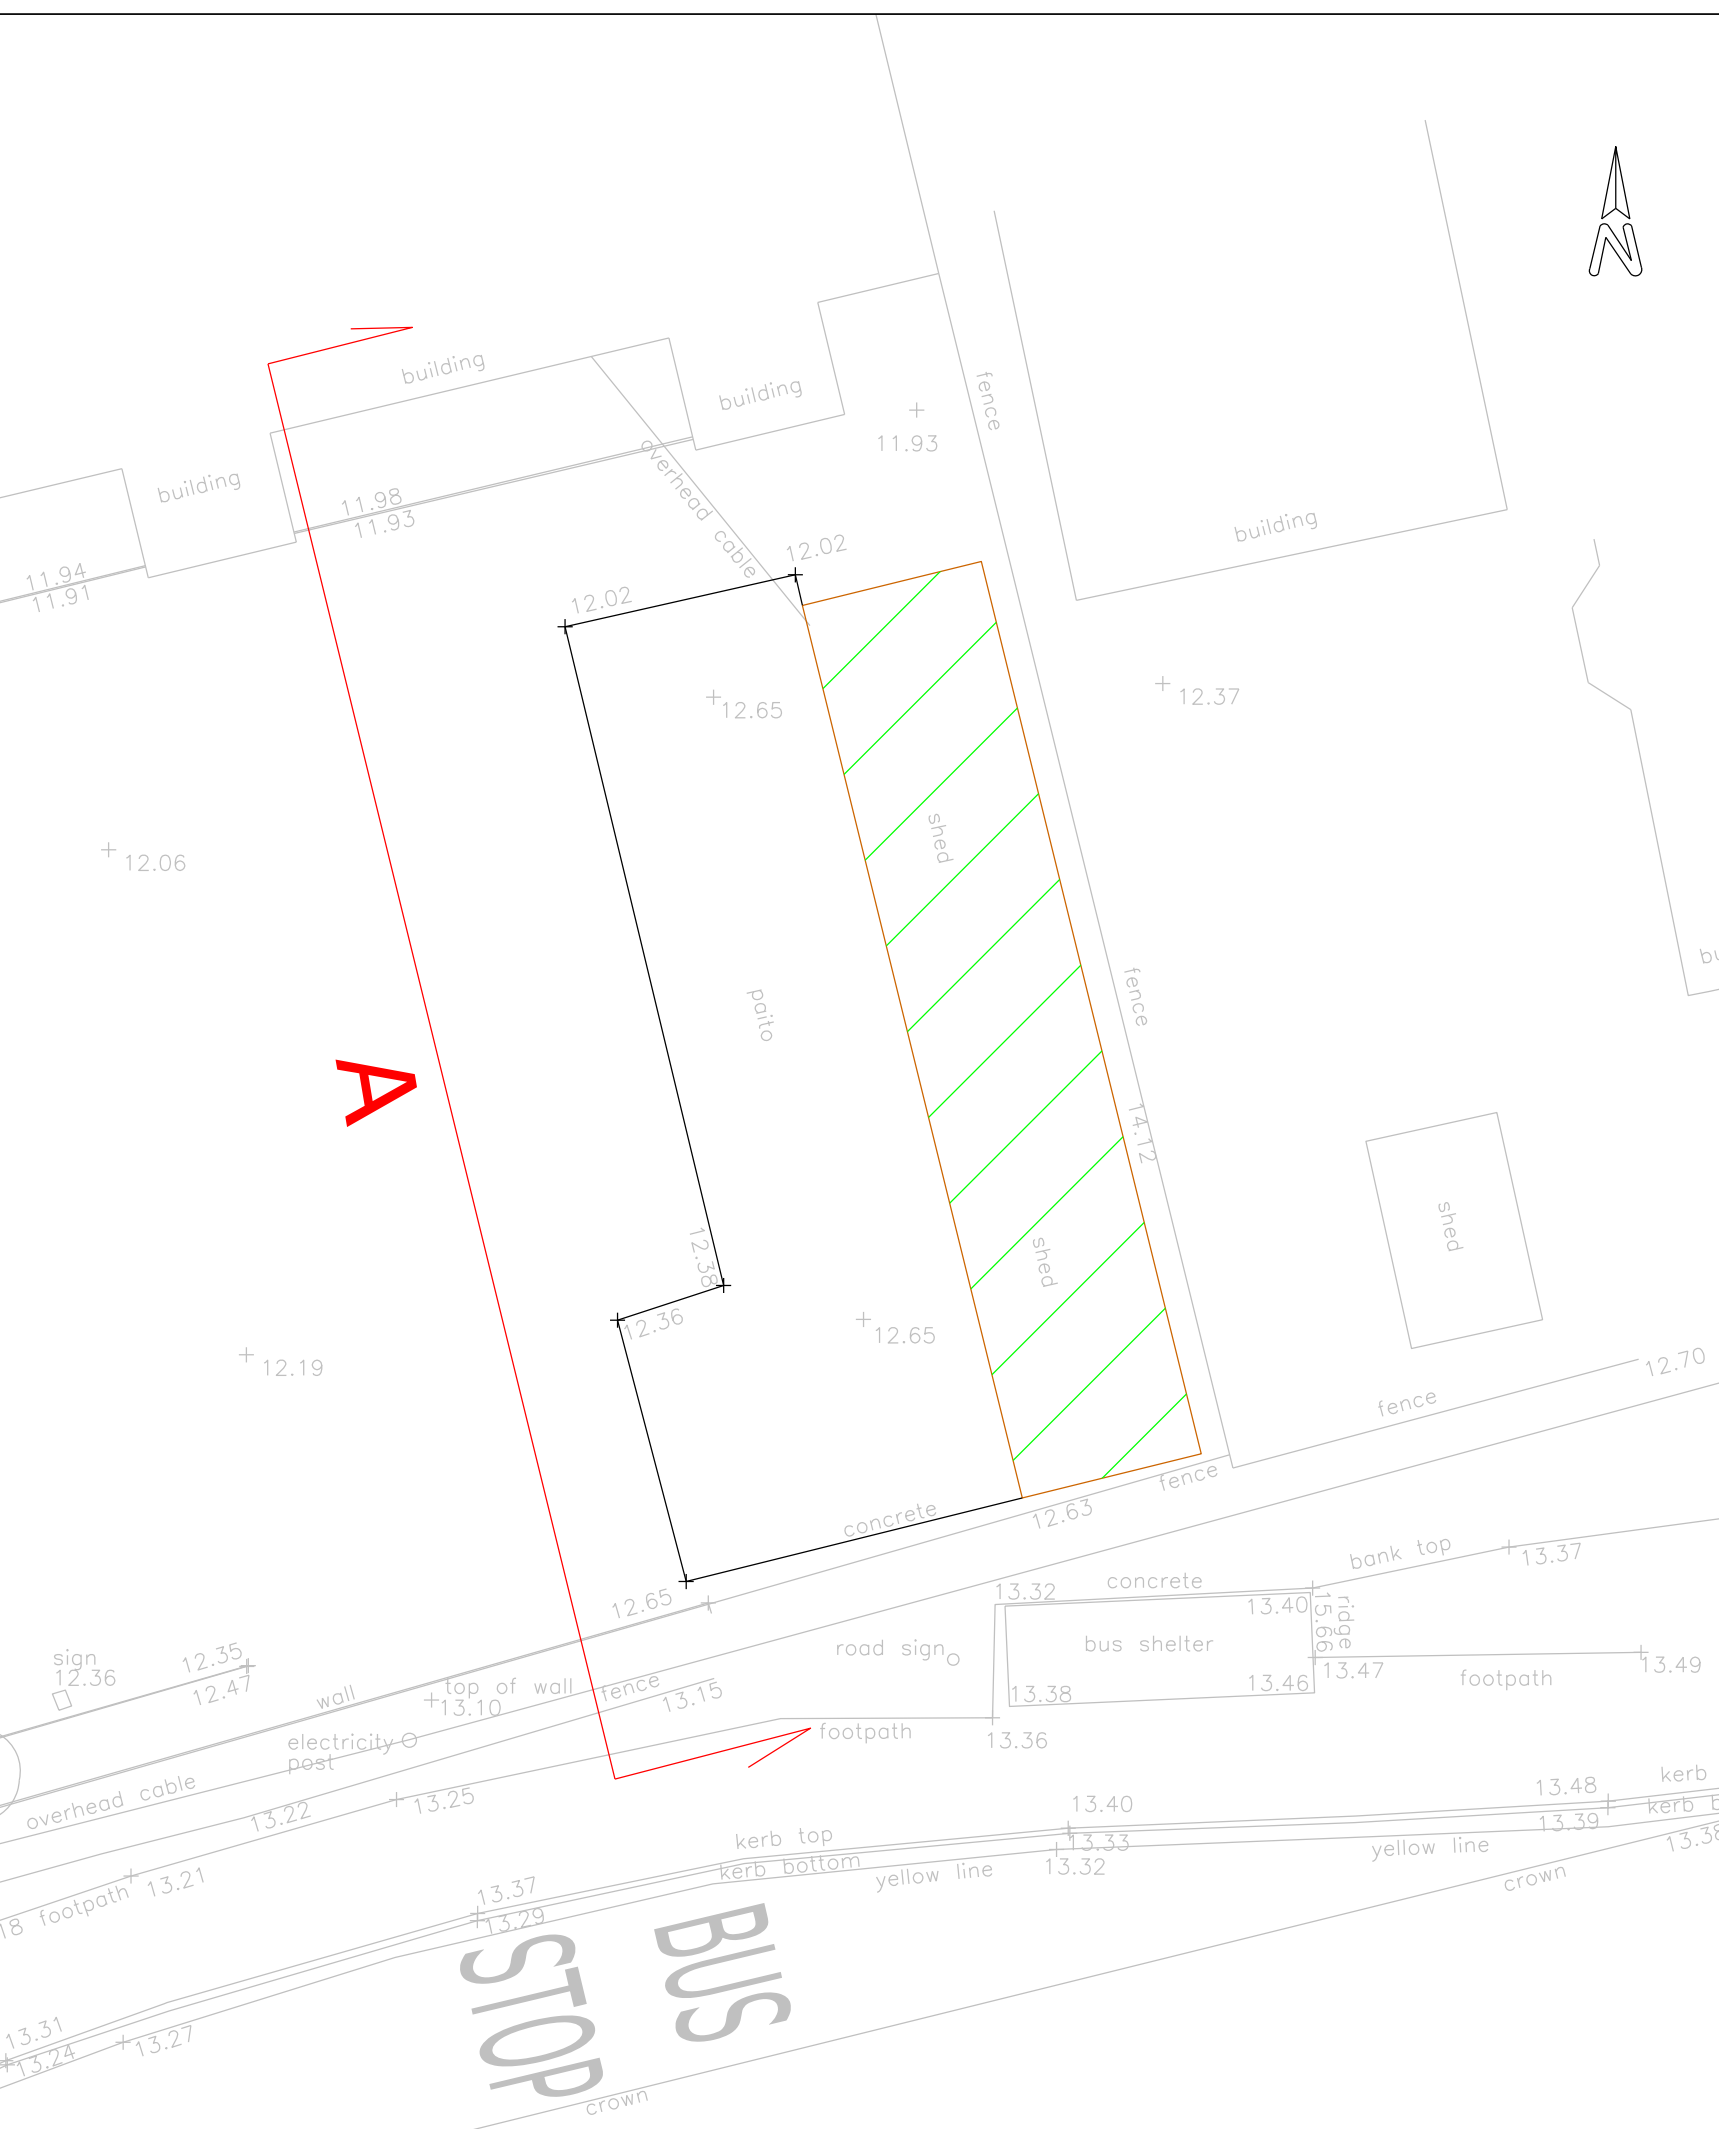

NOTES
 The location and/or identification of a service will not necessarily indicate whether it is live or dead.
 The fact that a service has not been located or identified does not necessarily imply that it does not exist or is dead, however their presence should be anticipated.
 Before mechanical plant is used, the actual position of mains and services must be established and verified on site.

NOTES
 GRID - ORDNANCE SURVEY NATIONAL GRID (OSTN15)
 LEVELS - ORDNANCE SURVEY (OSGM15)
 SCALE FACTOR REMOVED

SURVEYED BY
GEO CART LTD
 SITE ENGINEERING
 GEO CART LTD
 Sunnyhill House
 3-7 Sunnyhill Road
 London
 SW16 2UG
 T: 0739 722 3267
 e: office@geocart.co.uk

CLIENT
 The Bay View Hotel

SITE
 The Bay View Hotel
 287 Leysdown Road
 Sheerness

TITLE
 Elevation A

1:100 (A3)	DATE 14 SEP 2021
DRAWING No. 1	JOB No.