




VISUAL SCALE 1:100 @ A1

NOTES
Do not scale from this drawing. Only figured dimensions are to be taken from this drawing.
The contractor must verify all dimensions on site before commencing any work or shop drawings. The contractor must report any discrepancies to the designer before commencing work. If this drawing exceeds the quantities taken in any way, the designer is to be informed before the work is initiated.
Work within The Construction (Design and Management) Regulations 1994 is not to start until a Health and Safety Plan has been produced.

© Copyright
All rights prescribed in Chapter IV of the Copyright and Patents Act 1988 have been generally asserted.

Rev.	Description	By	Date	Chd	Chd Date

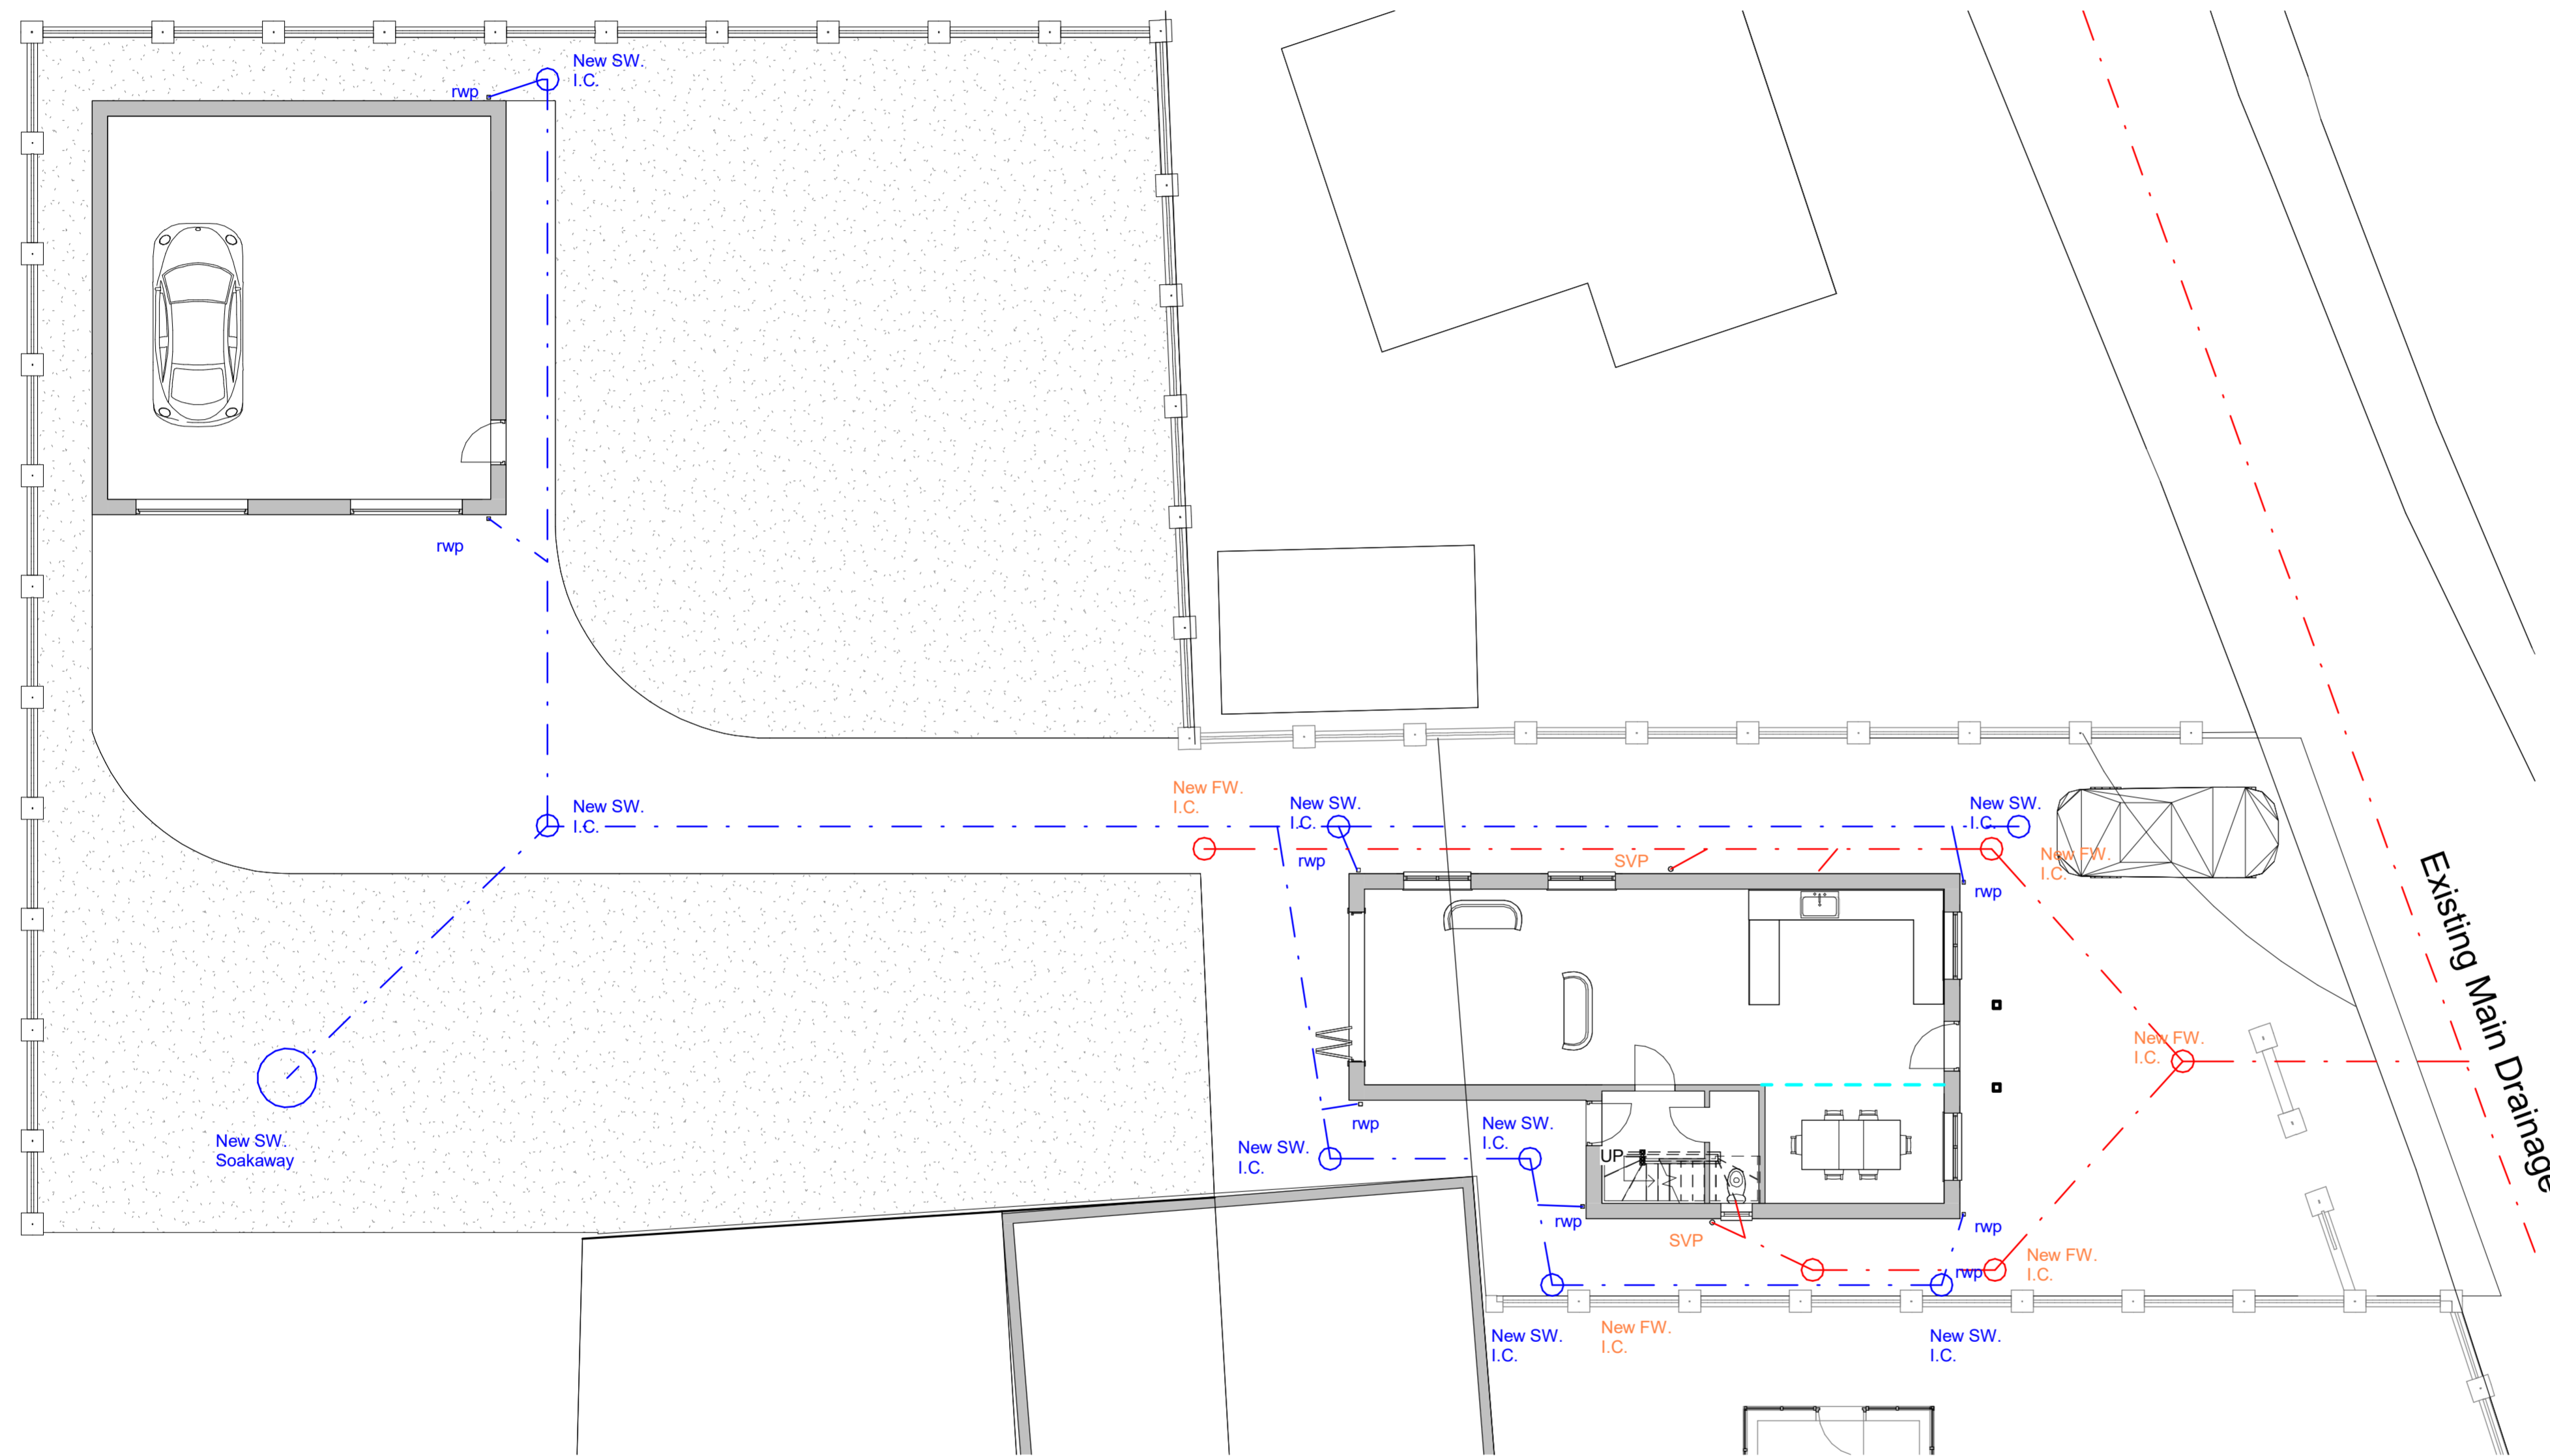

Drainage Layout
1 : 100

CLIENT: Mr. D. Smith
PROJECT: Erection of Detached Dwelling on Land North Of Street View, Asselby, East Yorkshire

DWG. TITLE: Proposed Drainage Layout

SCALE: 1 : 100
DRAWING STATUS: Feasibility
DRAWN: HAJB
DATE: 12-01-18
PROJECT No: 18022
DWG. No: P104
REV: E

STUDIO OFFICE: Briar Cottage, Clementhorpe Road, Giberdyke, Brough East Yorkshire, HU15 2UB.
Tel: 01430 448365 Mob: 07870903730

Email: info.aebarchitecture@gmail.com
Web: www.aebarchitectureanddesign.com

